



Republic of the Philippines
Department of Public Works and Highways
REGIONAL OFFICE NO. VIII
Government Center, Baras, Palo, Leyte

C.Y. 2024 PROJECT
PLAN FOR

**CONSTRUCTION OF INNOVATION INCUBATION CENTER BUILDING-
PALOMPON INSTITUTE OF TECHNOLOGY**

BRGY. GUIWAN II, PALOMPON, LEYTE

11°03'05.3"N 124°23'11.7"E
11.051468, 124.386594

SUBMITTED:


LUCAS N. BACSAL
CHIEF, MAINTENANCE DIVISION
DATE: 

RECOMMENDED:


MA. MARGARITA C. JUNIA, D.M.
ASSISTANT REGIONAL DIRECTOR
DATE: 

APPROVED:


EDGAR B. TABACON, CESO IV
REGIONAL DIRECTOR
DATE: 

CONCURRED:


DENNIS A. DEL PILAR, Ed.D.
UNIVERSITY PRESIDENT
DATE: 



Republic of the Philippines
Department of Public Works and Highways
REGIONAL OFFICE NO. VIII
Government Center, Baras, Palo, Leyte

C.Y. 2024 PROJECT
PLAN FOR

**CONSTRUCTION OF INNOVATION INCUBATION CENTER BUILDING-
PALOMPON INSTITUTE OF TECHNOLOGY**

BRGY. GUIWAN II, PALOMPON, LEYTE

11°03'05.3"N 124°23'11.7"E
11.051468, 124.386594

SPECIFICATION REFERENCE:

**DPWH STANDARD SPECIFICATIONS VOLUME III 1995, BUILDINGS, PORTS & HARBORS,
FLOOD CONTROL & DRAINAGE STRUCTURES & WATER SUPPLY SYSTEM.**

DPWH STANDARD SPECIFICATIONS 2013 VOLUME II, HIGHWAYS, BRIDGES AND AIRPORTS.

 Republic of the Philippines DEPARTMENT OF PUBLIC WORKS AND HIGHWAYS REGIONAL OFFICE NO. VIII GOVERNMENT CENTER, BARAS, PALO, LEYTE	PROJECT TITLE: CONSTRUCTION OF INNOVATION INCUBATION CENTER BUILDING- PALOMPON INSTITUTE OF TECHNOLOGY	SHEET CONTENTS: GENERAL COVER PAGE	PREPARED BY: AS. PAUL L. CONDE, UAP ARCHITECT	SUBMITTED BY: LUCAS N. BACAL CITY/SECTORAL DIVISION	RECOMMENDED BY: MA. MARGARITA C. JUNIA, D.M. REGIONAL REGIONAL DIRECTOR	APPROVED BY: EDUAR B. TABACON, CESO IV REGIONAL DIRECTOR	CONCURRED BY: DENNIS A. DELA CRUZ, Ed.D. UNIVERSITY REPRESENTATIVE	SET NO. GCP 1/3	SHEET NO. 1 101
	LOCATION: BRGY. GUIWAN II, PALOMPON, LEYTE		DATE:	DATE:	DATE:	DATE:	DATE:		



Republic of the Philippines
Department of Public Works and Highways
REGIONAL OFFICE NO. VIII
Government Center, Baras, Palo, Leyte

SUMMARY OF QUANTITIES

Item No.	Description	Unit	Quantity
Part B	OTHER GENERAL REQUIREMENTS, DPWH Standard Specification for Public Works Structures (Vol. III)		
B.3(1)	Permits and Clearances	L.S.	1.0
B.5(1)	Project Billboard/Signboard	Each	4.0
B.7(1)	Occupational Safety and Health	L.S.	1.0
B.9(1)	Mobilization / Demobilization	L.S.	1.0
Part C	EARTHWORK - DPWH Standard Specification for Public Works Structures (Vol. III), Division I - General		
801(1)	Removal of Structures and Obstructions	L.S.	1.0
803(1)a	Structure Excavation, Common Soil	Cu.M.	850.2
804(1)a	Embankment, from Roadway/Structure Excavation, Common Soil	Cu.M.	662.3
804(1) 2 a)	Embankment, From Borrow	Cu.M.	1257.6
804(7)	Gravel Fill	Cu.M.	16.2
Part D	REINFORCED CONCRETE - DPWH Standard Specification for Public Works Structures (Vol. III), Division I - General		
900(1)d	Structural Concrete, 4000 psi, Class A, 28 Days	Cu.M.	487.0
900(1) c	Structural Concrete, 3000 psi, 28 Days	Cu.M.	82.1
901(1)	Lean Concrete	Cu.M.	46.0
902(1) a1	Reinforcing Steel (Deformed), Grade 40	kgs	50,866.8
902(1) a2	Reinforcing Steel (Deformed), Grade 60	kgs	29,237.5
903(2)	Formworks and Falseworks	Sq.M.	2,934.1
PART E	FINISHINGS & OTHER CIVIL WORKS - DPWH Standard Specification for Public Works Structures (Vol. III), Division II - Buildings		
1001	Storm Drainage and Sewerage System		
1001(6)	Catch Basin	L.S.	1.0
1001(8)	Sewer Line Works	L.S.	1.0
1001(9)	Storm Drainage and Downspout	L.S.	1.0
1001(11)	Septic Vault/Tank, Concrete/CHB	L.S.	1.0
1002	Plumbing Works		
1002(4)	Plumbing Fixtures	L.S.	1.00
1002(24)	Cold Water Lines	L.S.	1.00
1003	Carpentry and Joinery Works		
1003(1)a1	Ceiling, 4.5 mm, Metal Frame, Fiber Cement Board	Sq.M.	737.80
1003(2)a4	Wall, 10mm, Metal Frame, Fiber Cement Board	Sq.M.	54.55
1003(17)	Carpentry and Joinery Works	L.S.	1.00
1003(11) a1	Fascia Board, 19mm, Fiber Cement Board	M	56.80
1008	Finishing Hardware		
1004(2)	Finishing Hardware	L.S.	1.00
1008	Aluminum Glass Windows		

Item No.	Description	Unit	Quantity
1007(1) a	Aluminum Framed Glass Door, Sliding Type	Sq.M.	37.80
1007(1) b	Aluminum Framed Glass Door, Swing Type	Sq.M.	15.12
1008(1)a	Aluminum Glass Windows, Sliding Type	Sq.M.	6.30
1008(1)c	Aluminum Glass Windows, Awning Type	Sq.M.	45.48
1008(1)d	Aluminum Glass Windows, Fixed Type	Sq.M.	164.37
1010	Wooden Doors and Windows		
1010(1)	Frames, Jambs, Sills, Head, Transoms and Mullions	set	59.00
1010(2)a	Doors, Flush	Sq.M.	2.52
1010(2)b	Doors, Wood Panel	Sq.M.	40.74
1014	Prepainted Metal Sheets		
1014(1)b2	Prepainted Metal Sheets above 0.427mm, Rib Type, Long Span	Sq.M.	109.82
1016	Waterproofing		
1016(1) a	Waterproofing, Cement Base	Sq.M.	807.90
1018	Ceramic/Granite Tiles		
1018(1)	Glazed Tiles and Trims	Sq.M.	1,493.64
1018(2)	Unglazed Tiles	Sq.M.	767.78
1018(3)	Granite Tiles	Sq.M.	204.00
1027	Cement Plaster Finish		
1027(1)	Cement Plaster Finish	Sq.M.	2,463.27
1030	Acoustical Ceiling		
1030(1)	Acoustical Ceiling Panel	Sq.M.	354.00
1032	Painting, Varnishing and other Related Works		
1032(1)a	Painting Works, Masonry/Concrete	Sq.M.	3,377.98
1032(1)c	Painting Works, Steel	Sq.M.	244.79
1046	Masonry Works		
1046(2) a1	CHB Non Load-Bearing (including Reinforcing Steel), 100 mm	Sq.M.	474.48
1046(1) a2	CHB Load Bearing (including Reinforcing Steel), 150 mm	Sq.M.	929.92
1047	Metal Structures		
1047(4) a	Metal Structure Accessories (Bolts and Rods)	Each	198.00
1047(5) d	Metal Structure Accessories (Steel Plates)	Kg.	388.58
1047(8) a	Structural Steel, Trusses	Kg.	1,677.63
1051	Railings		
1051(1) a	Railing	LS	1.0
PART F	ELECTRICAL - DPWH Standard Specification for Public Works Structures (Vol. III), Division II - Buildings		
1101(33)	Conduits, Boxes and Fittings, (Conduit Works/Conduit Rough-in)	L.S.	1.0
1101(33)	Wires and Wiring Devices	L.S.	1.0
1102(1)	Panelboard with Main & Branch Breakers	L.S.	1.0
1102(18)	Solar Panel with Inverter, Battery, and Other Devices	L.S.	1.0
1103(1)	Lighting Fixtures	L.S.	1.0



Republic of the Philippines
DEPARTMENT OF PUBLIC WORKS AND HIGHWAYS
REGIONAL OFFICE NO. VIII
GOVERNMENT CENTER, BARAS, PALO, LEYTE

PROJECT TITLE:
CONSTRUCTION OF INNOVATION INCUBATION CENTER BUILDING
PALORPON INSTITUTE OF TECHNOLOGY
LOCATION: BRIS, QUEMIA, PALORPON, LEYTE

SHEET CONTENTS:
SUMMARY OF QUANTITIES

PREPARED BY:
ANNE PAUL L. CONDE, UAP
ARCHITECT
DATE: 10/10/2023

SUBMITTED BY:
LUCAS R. BACSA
CHIEF ARCHITECTURAL ENGINEER
DATE: 10/10/2023

RECOMMENDED BY:
RA. MARGARITA C. JENIA, D.E.
HONORARY REGIONAL DIRECTOR
DATE: 10/10/2023


APPROVED BY:
EDGAR R. TABACON, CESO IV
REGIONAL DIRECTOR
DATE: 10/10/2023

CONCURRED BY:
DENNIS A. DELA CRUZ, Ed.D.
UNIVERSITY CHAIRMAN
DATE: 10/10/2023

SET NO. 2
SHEET NO. 101



1 LOCATION MAP
GCP DRAWN NOT TO SCALE

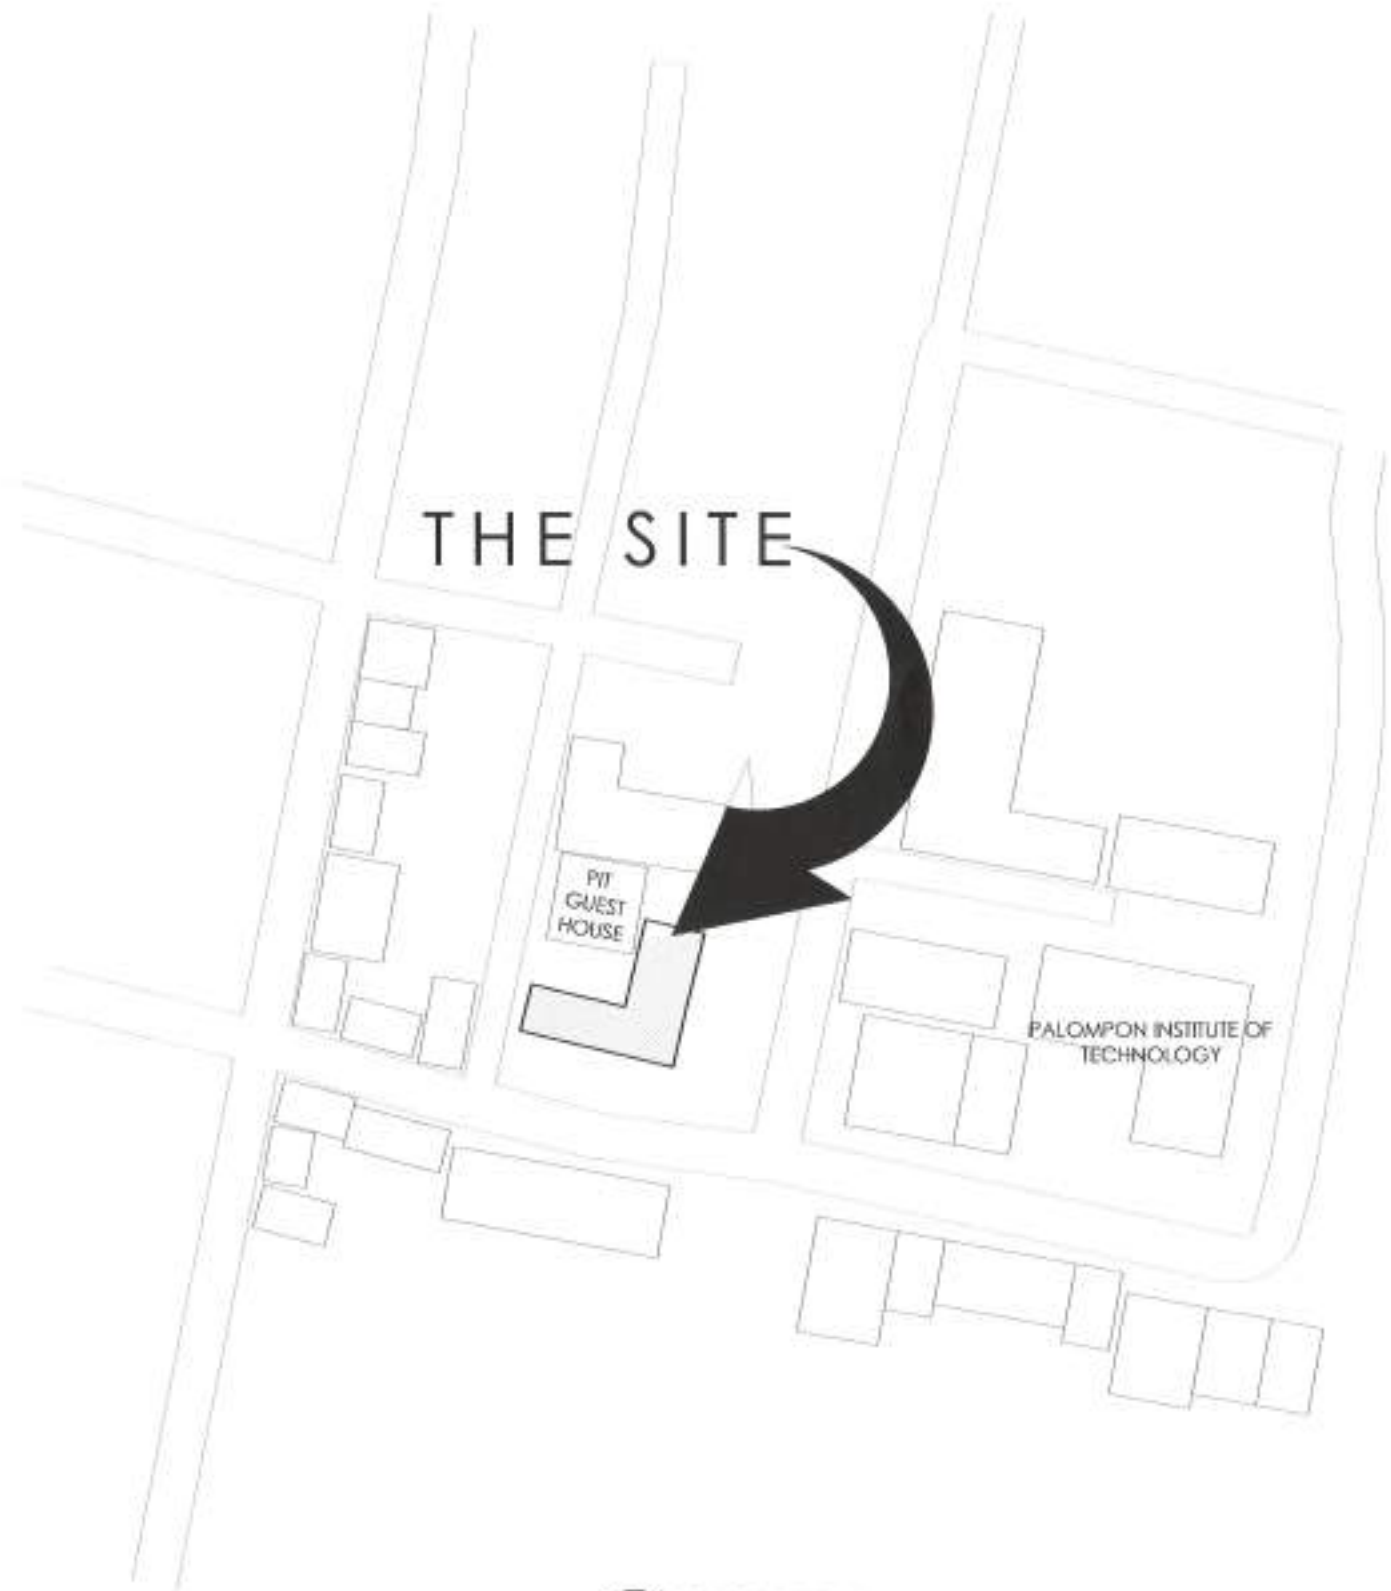

2 VICINITY MAP
GCP DRAWN NOT TO SCALE



Republic of the Philippines
DEPARTMENT OF PUBLIC WORKS AND HIGHWAYS
REGIONAL OFFICE NO. VIII
GOVERNMENT CENTER, SARAS, PALO LEYTE

PROJECT TITLE:
CONSTRUCTION OF INNOVATION INCUBATION CENTER BUILDING-
PALOMPON INSTITUTE OF TECHNOLOGY
LOCATION: BPOZ GUWAW & PALOMPON, LEYTE

SHEET CONTENTS:
LOCATION MAP
VICINITY MAP

PREPARED BY:
AR. PAUL L. CONDE, UAP
ARCHITECT
DATE:

SUBMITTED BY:
LUCAS N. BADOAL
CHIEF, MAINTENANCE DIVISION
DATE:

RECOMMENDED BY:
MA. MARGARITA C. JIMIN, U.P.
ASSISTANT REGIONAL ENGINEER
DATE:


APPROVED BY:
EDGAR B. TABACON, CESO IV
REGIONAL DIRECTOR
DATE:

CONCURRED BY:
DENNIS A. DELA PLATA, E.O.D.
UNIVERSITY ASSESSOR
DATE:

SHEET NO.	SHEET NO.
GCP 3 5	3 101



1 PERSPECTIVE
A-1

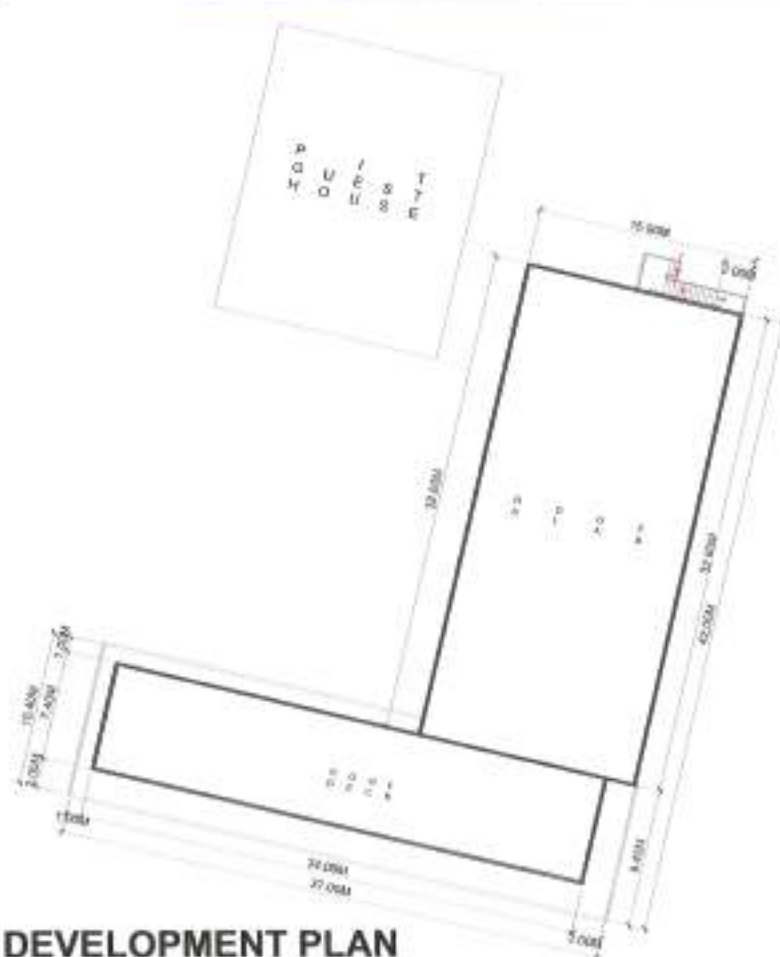

2 SITE DEVELOPMENT PLAN
A-1 SCALE: 1:400 MTS.



2 SITE DEVELOPMENT PLAN
A-1 SCALE: 1:400 MTS.

REPUBLIC OF THE PHILIPPINES
DEPARTMENT OF PUBLIC WORKS AND HIGHWAYS
OFFICE OF THE BUILDING OFFICIAL

RECOMMENDING APPROVAL

HEAD ARCHITECTURAL SECTION DATE

APPROVED BY

BUILDING OFFICIAL DATE

LAND USE & ZONING

BUILDING OFFICIAL DATE

LINE & GRADE

BUILDING OFFICIAL DATE

ARCHITECTURAL

BUILDING OFFICIAL DATE

STRUCTURAL

BUILDING OFFICIAL DATE

PLUMBING

BUILDING OFFICIAL DATE

ELECTRICAL

BUILDING OFFICIAL DATE

MECHANICAL

BUILDING OFFICIAL DATE



Republic of the Philippines
DEPARTMENT OF PUBLIC WORKS AND HIGHWAYS
REGIONAL OFFICE NO. VIII
GOVERNMENT CENTER, DAVAO PALO DUYTE

PROJECT TITLE:
CONSTRUCTION OF INNOVATION INCUBATION CENTER (ICIC)-
PALOMPON INSTITUTE OF TECHNOLOGY
LOCATION: BRGY. BUNYAN, PALOMPON, DAVAO

SHEET CONTENTS:
PERSPECTIVE
LOCATION MAP
VICINITY MAP

PREPARED:
AR. RAUL L. CONDE, UAP
ARCHITECT
DATE:

SUBMITTED:
LUCAS N. BACSA
CHIEF ARCHITECTURAL SECTION
DATE:

RECOMMENDED:
MA. MARGARITA C. JUNGCO, M.
ASSISTANT REGIONAL DIRECTOR
DATE:

APPROVED:
EDGAR D. TABACON, CESO IV
REGIONAL DIRECTOR
DATE:

CONCURRED:
DENNIS A. DELA CRUZ, ELD,
LAWYER
DATE:

SET NO. SHEET NO.
A 4
1 24 101



Republic of the Philippines
DEPARTMENT OF PUBLIC WORKS AND HIGHWAYS
REGIONAL OFFICE NO. VIII
GOVERNMENT CENTER, DAVAO, PALOYE

1. 2002年10月1日起实施的《中华人民共和国道路交通安全法》第119条第4款规定：“非机动车，是指以人力或者畜力驱动，上道路行驶的交通工具，以及虽有动力装置驱动但设计最高时速、空车质量、外形尺寸符合有关国家标准的残疾人机动轮椅车、电动自行车等交通工具。”

GROUND FLOOR PLAN

AR. PAUL L. CONDE, UAP

LUCAS N. BACAL


M.A. MAGOMEDOVA, D.J.

EDGAR B. TABACON, CEO IN
REGIONAL DIRECTOR

DENNIS A. DEFLAR, Esq.


5

101

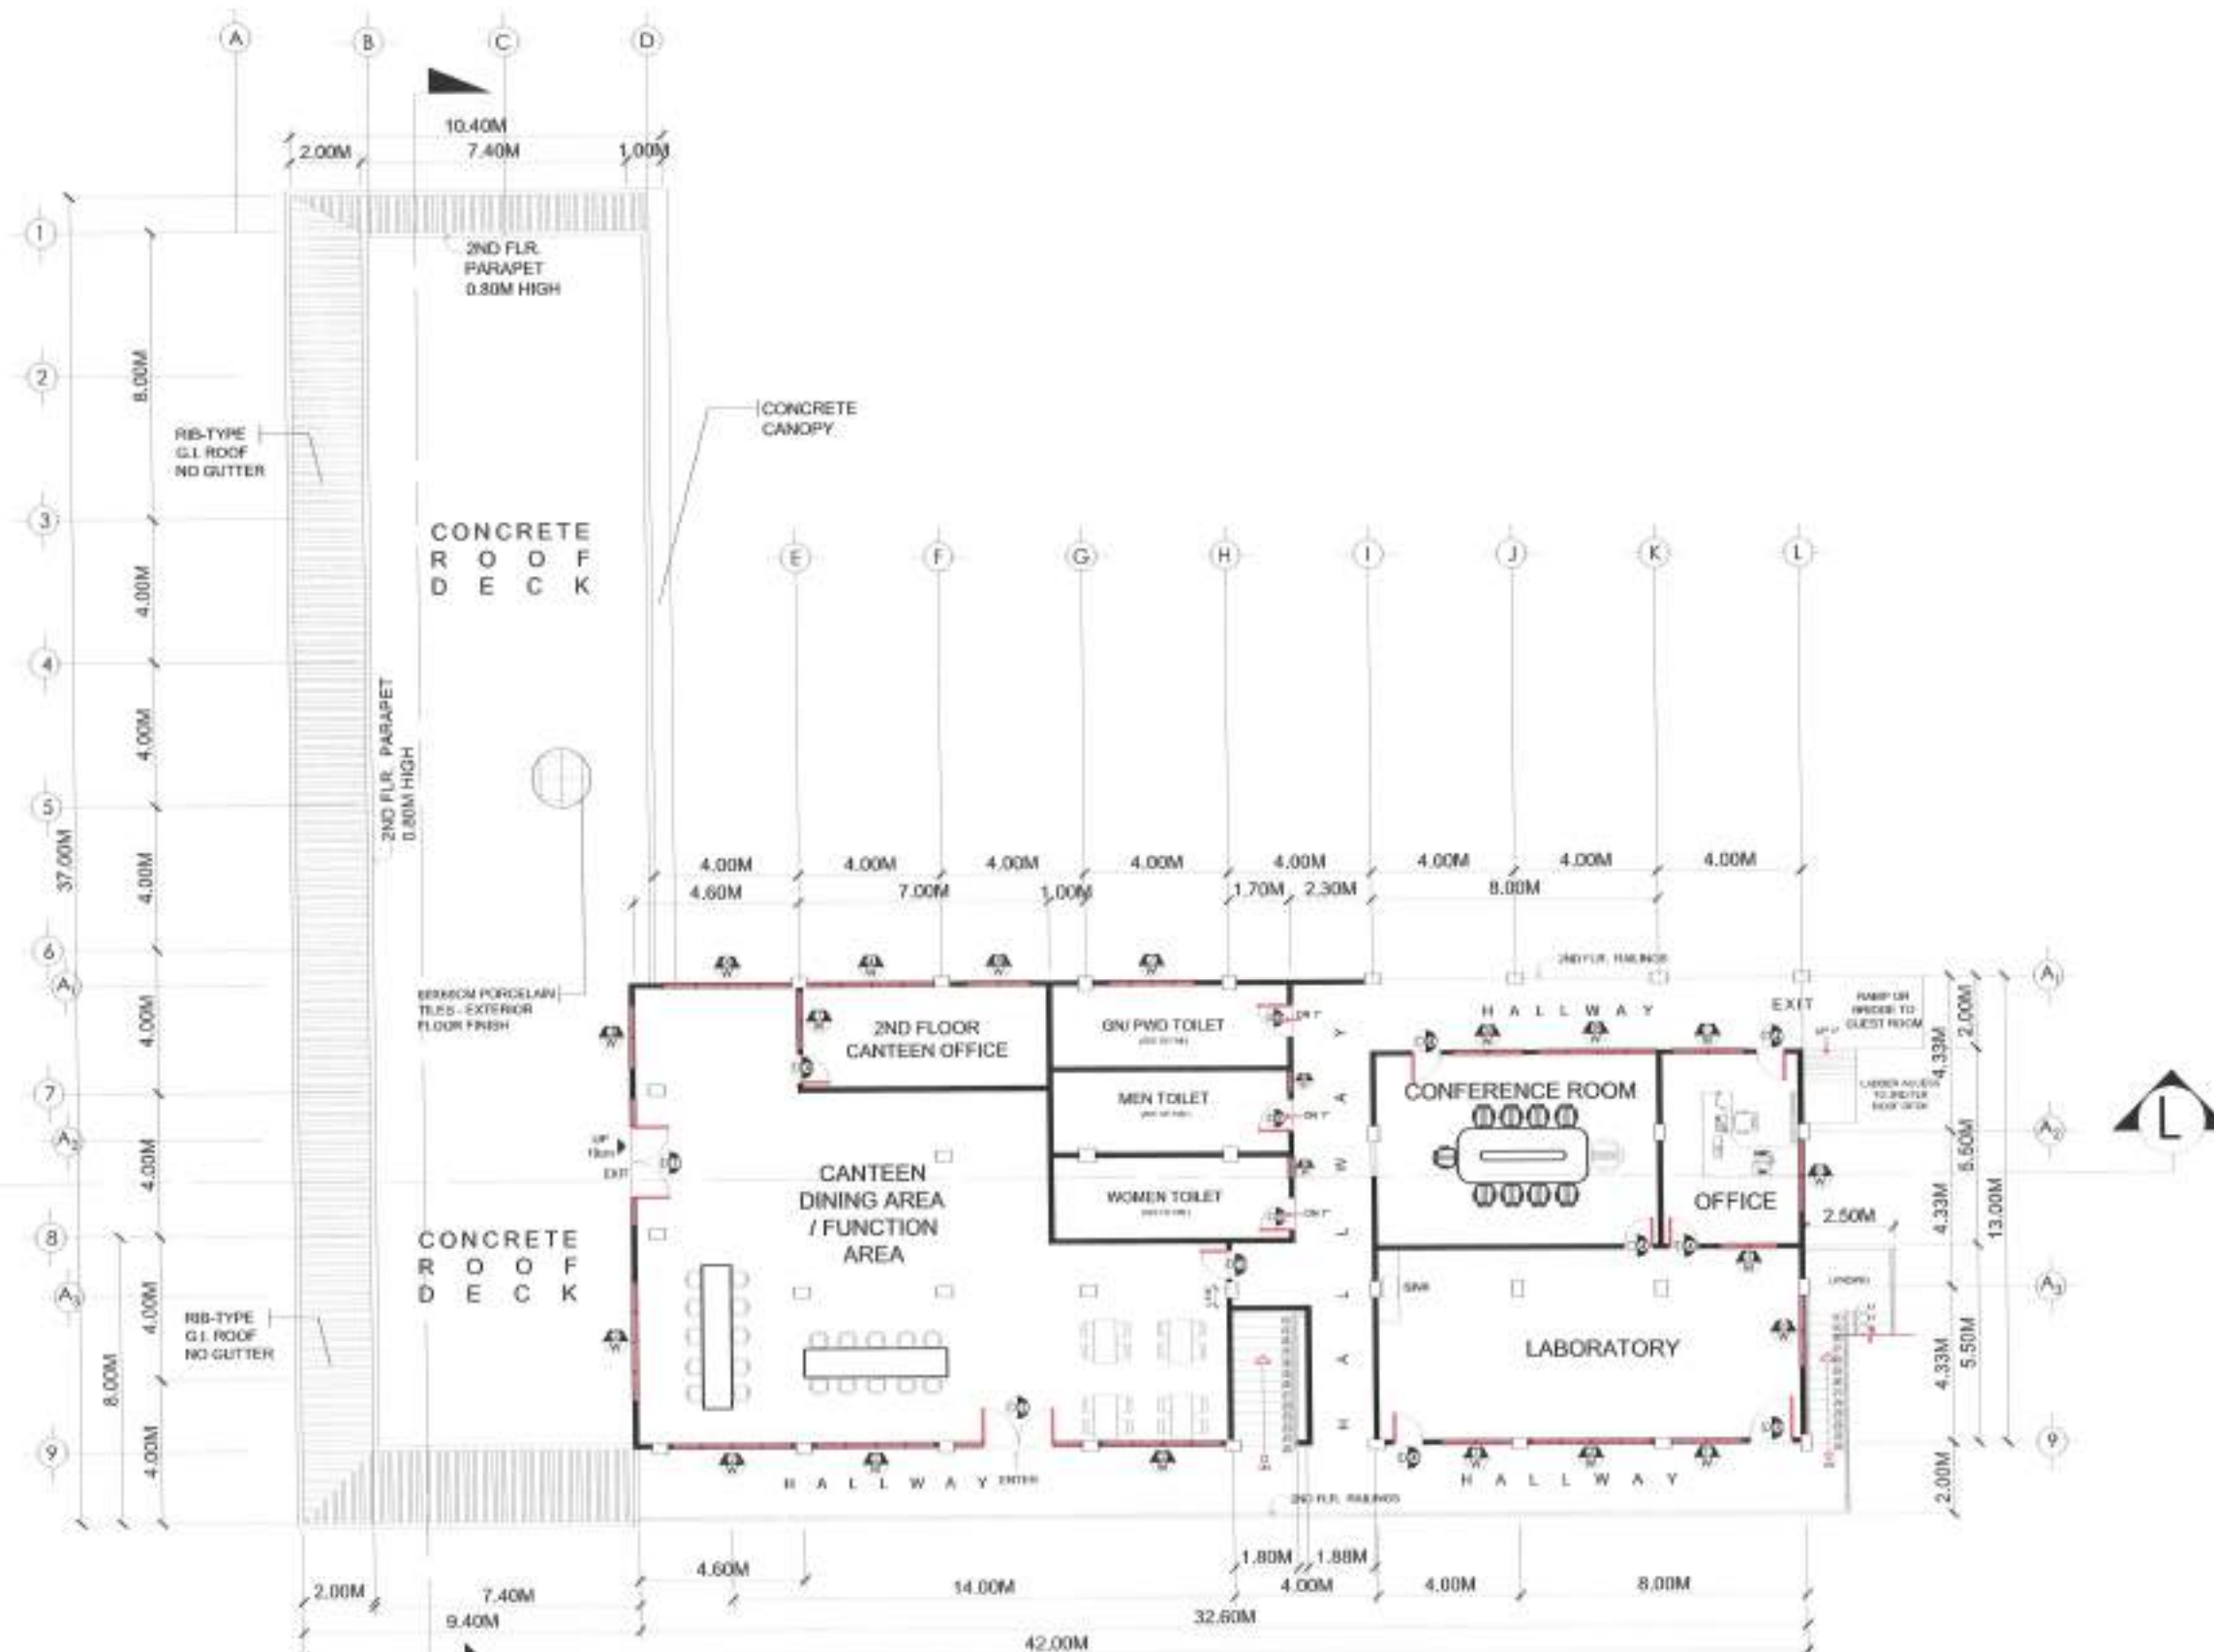


1 SECOND FLOOR PLAN
A - 3 SCALE: 1:200 MTS.

 Republic of the Philippines DEPARTMENT OF PUBLIC WORKS AND HIGHWAYS REGIONAL OFFICE NO. VIII GOVERNMENT CENTER, ERAS, PALO LEYTE	PROJECT TITLE: CONSTRUCTION OF INNOVATION INCUBATION CENTER BUILDING PALOMPON INSTITUTE OF TECHNOLOGY LOCATION: WIDE LORAN S. PALOMPON LEYTE	SHEET CONTENTS: SECOND FLOOR PLAN	DESIGNED BY: MR. PAUL L. CONDE, UAP ARCHITECT	SUBMITTED BY: LUCAS M. SACSAI CIVIL ENGINEER	RECOMMENDED BY: MA. MARGARITA E. JUNIA, D.M. CIVIL ENGINEER	APPROVED BY: EDUAR B. TABACON, CESO IV REGIONAL DIRECTOR	CONCURRED BY: DENNIS A. DELA CRUZ, E.D. UNIVERSITY REPRESENTATIVE	SHEET NO.: 3 SHEET NO.: 101
--	--	---	--	---	--	---	--	---



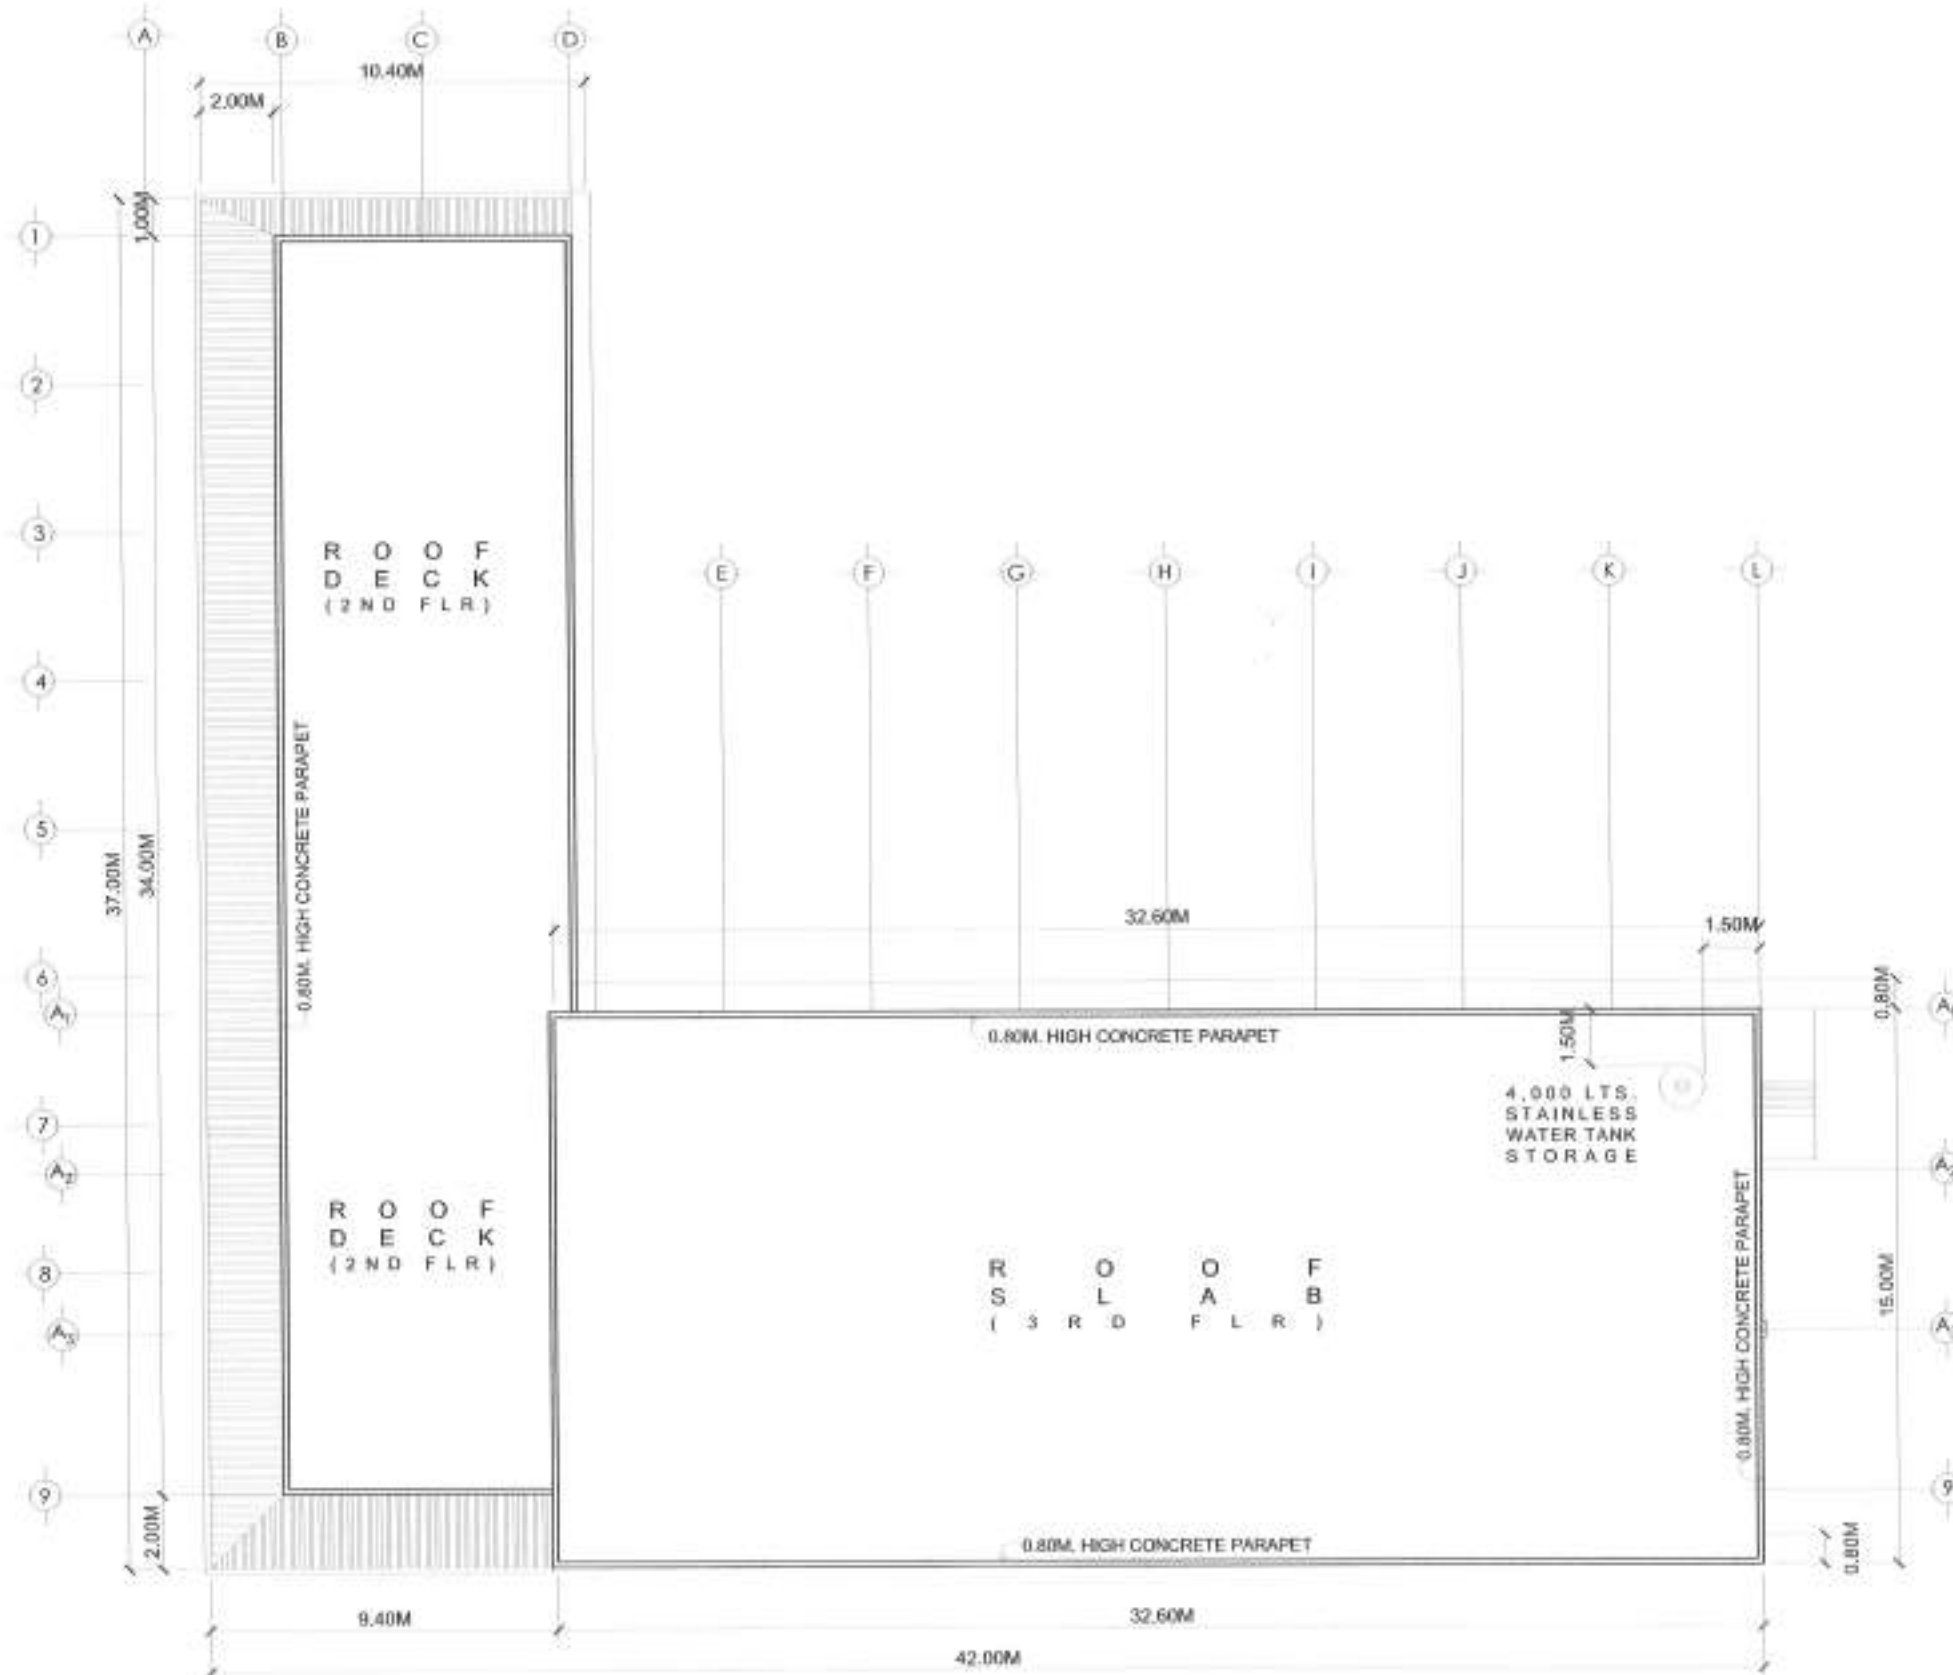



1 ROOF DECK PLAN
A - 4 SCALE: 1:200 MTS.

 Republic of the Philippines DEPARTMENT OF PUBLIC WORKS AND HIGHWAYS REGIONAL OFFICE NO. VIII GOVERNMENT CENTER, DAVAO PALDIENTE	PROJECT TITLE: CONSTRUCTION OF INNOVATION INCUBATION CENTER BUILDING, PALOMPON INSTITUTE OF TECHNOLOGY LOCATION: WSP GUINAYAN CAMPUS 12770	SHEET CONTENTS: ROOF DECK PLAN	PREPARED BY: AN RAUL L. CONDE, UAP ARCHITECT	SUBMITTED BY: LUCAS N. BALSAL CHIEF ARCHITECT/DESIGN	RECOMMENDED BY: NA. MARGARITA C. JONIA, D.M. ROOSTER/DESIGN	APPROVED BY: EDUARDO B. TABACON, CESO IV REGIONAL DIRECTOR	CONCURRED BY: DENNIS A. DELA LARA, Ed.D. UNIVERSITY REPRESENTATIVE	SET NO. 4 24 SHEET NO. 101
--	--	---	---	---	--	---	---	--

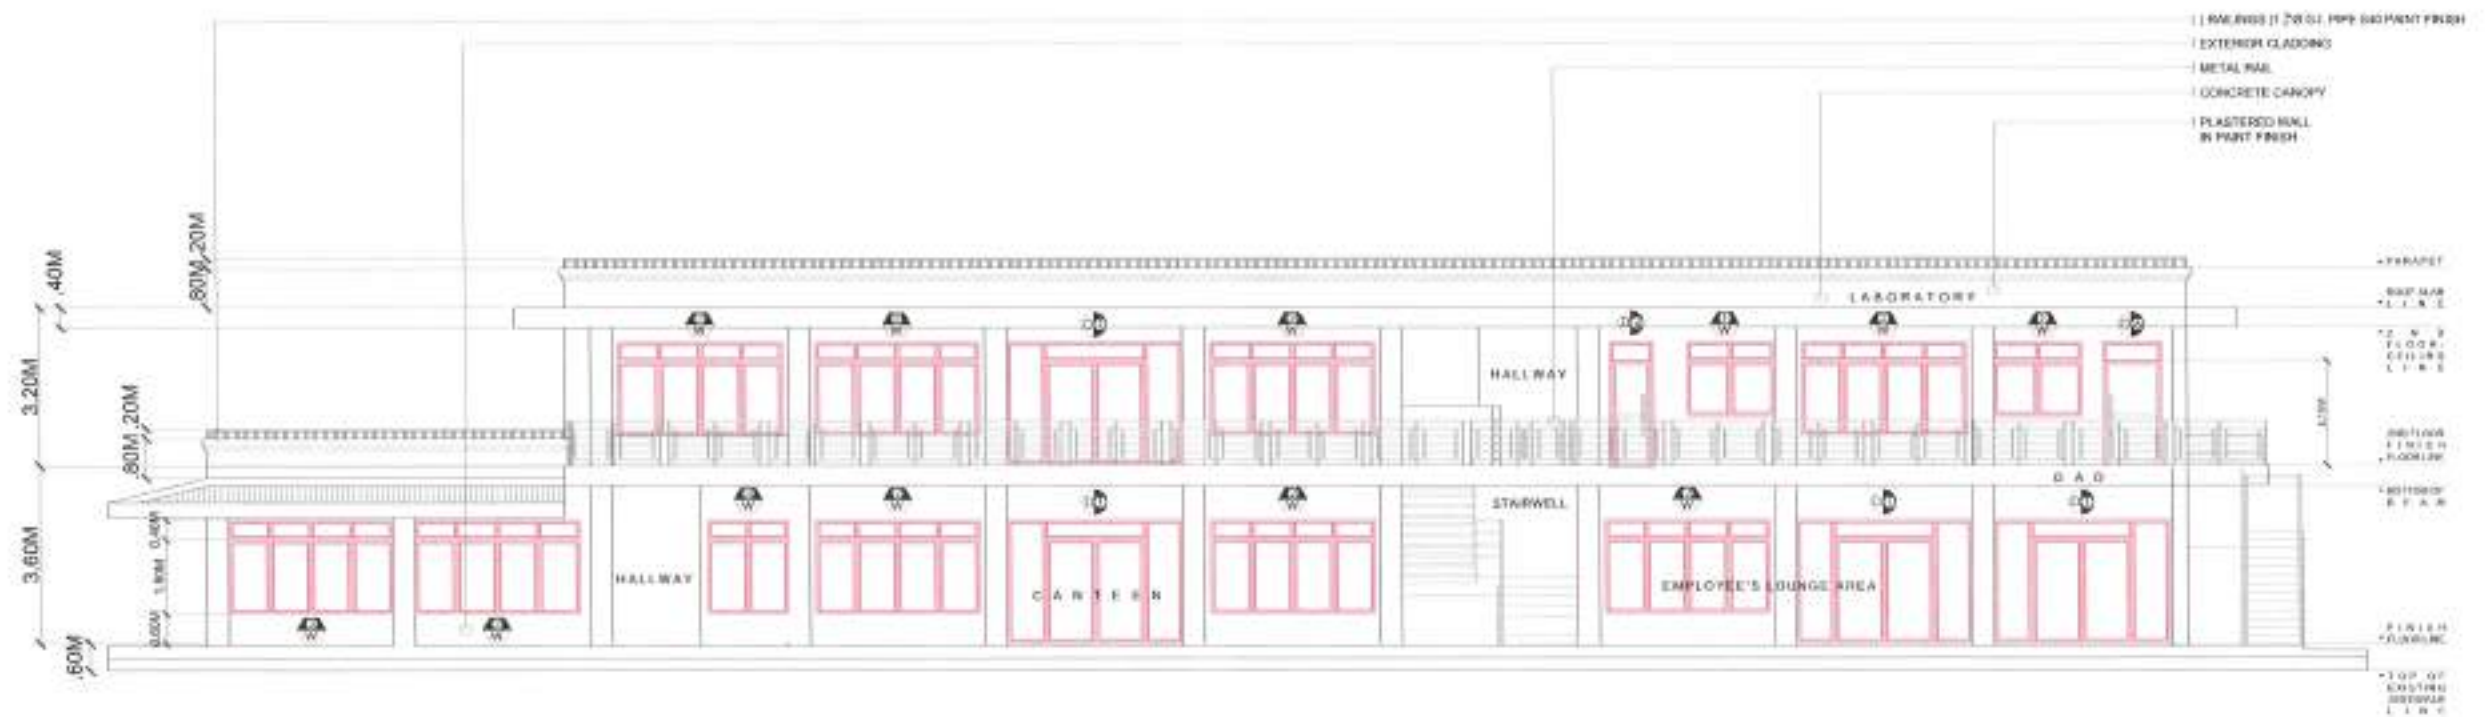

   1 FRONT ELEVATION
A - 5 SCALE: 1:200 MTS.

 Republic of the Philippines DEPARTMENT OF PUBLIC WORKS AND HIGHWAYS REGIONAL OFFICE NO. VIII GOVERNMENT CENTER, SARAO, PALO LITTE	PROJECT TITLE: CONSTRUCTION OF INNOVATION INCUBATION CENTER BUILDING - PALOMPAN INSTITUTE OF TECHNOLOGY LOCATION: STREET, SARAO, PALO LITTE	SHEET CONTENTS: FRONT ELEVATION	PREPARED:  AR. PAUL L. CONDE, UAP ARCHITECT	SUBMITTED:  LUCAS N. BACSAI CIVIL ENGINEER	RECOMMENDED:  NA. MARIBELITA C. JUNIA, DM ASSISTANT REGIONAL DIRECTOR	APPROVED:  EDGAR R. TABACON, CESO IV REGIONAL DIRECTOR	CONCURRED:  DENNIS A. VILLAR, Ed.D. UNIVERSITY CHIEF	SRT NO. A 5 24	SHEET NO. II 101
---	--	--	---	--	---	--	--	--	--

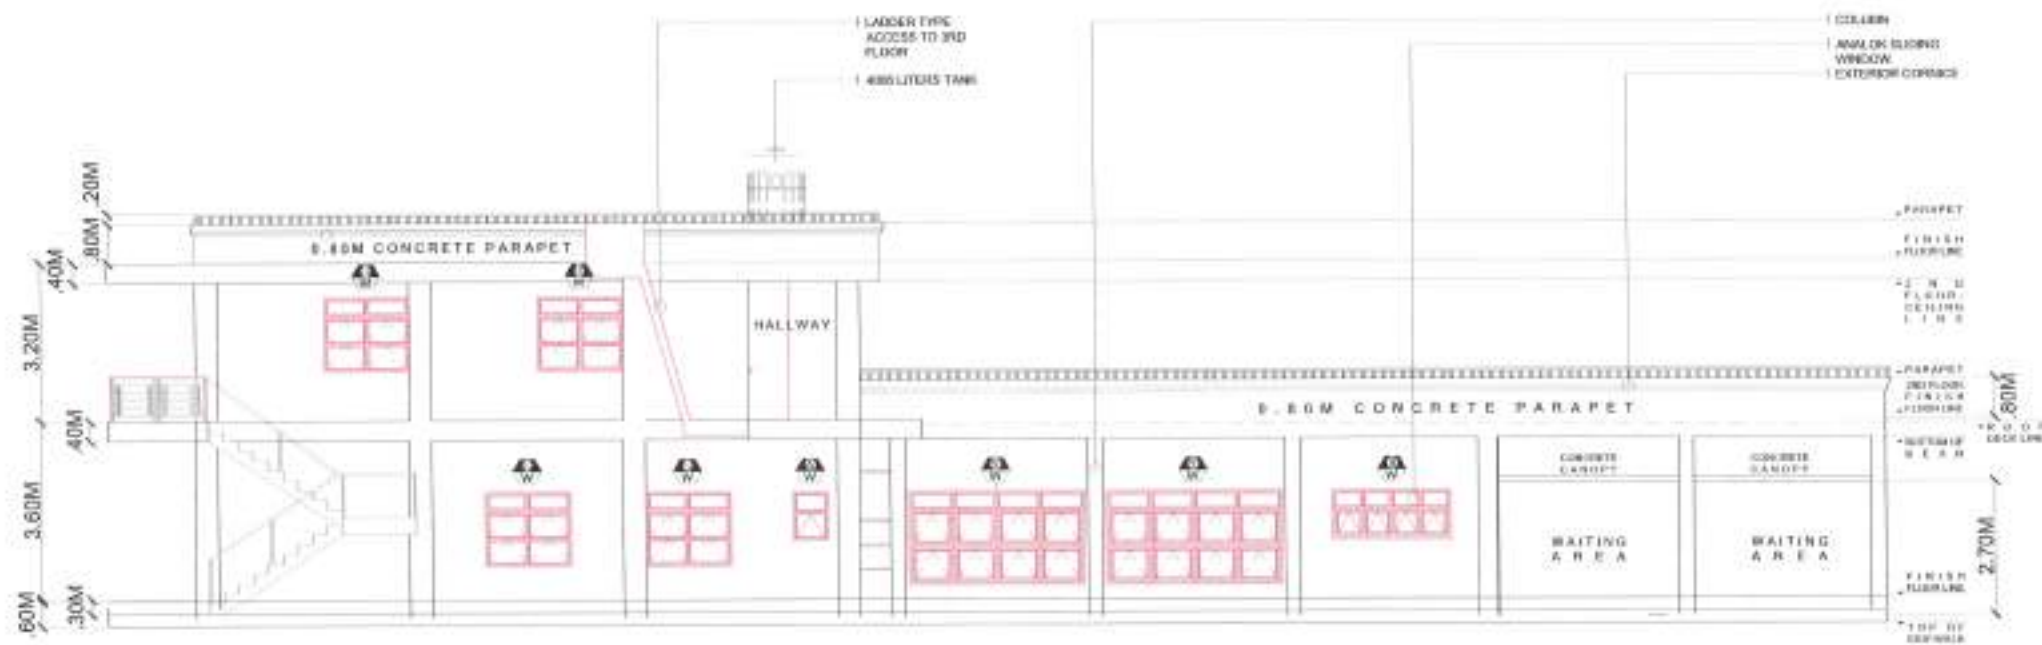


1 RIGHT-SIDE ELEVATION
A - 6 SCALE: 1:200 MTS.




 Republic of the Philippines DEPARTMENT OF PUBLIC WORKS AND HIGHWAYS REGIONAL OFFICE NO. VIII GOVERNMENT CENTER, MARAL PALLETES	PROJECT TITLE: CONSTRUCTION OF INNOVATION INCUBATION CENTER BUILDING- PALORPOR INSTITUTE OF TECHNOLOGY LOCATION: BICD, QUEZON & PALORPOR, COTABATO	SHEET CONTENTS: RIGHT-SIDE ELEVATION	PREPARED:  AR. PAUL L. CONDE, UAP ARCHITECT	SUBMITTED:  LUCAS N. BACSAI CHIEF MAINTENANCE DIVISION	RECOMMENDED:  NA, MARGARITA C. LUNA, D.M. ASSISTANT REGIONAL DIRECTOR	APPROVED:  EDMAR B. TABACON, CESO IV REGIONAL DIRECTOR	CONCURRED:  DENNIS A. VILLAR, Ed.D. UNIVERSITY REPRESENTATIVE	SET NO. A 6 24	SHEET NO. 9 101
--	---	--	--	---	--	---	--	-----------------------------	------------------------------




 Republic of the Philippines DEPARTMENT OF PUBLIC WORKS AND HIGHWAYS REGIONAL OFFICE NO. VIII GOVERNMENT CENTER, BANGAL, PALO-LEYTE	PROJECT TITLE:	SHEET CONTENTS:	PREPARED BY:	SUBMITTED BY:	RECOMMENDED BY:	APPROVED BY:	CONCURRED BY:	SET NO.	SHEET NO.
	CONSTRUCTION OF INNOVATION INCUBATION CENTER BUILDING- PALORONIA INSTITUTE OF TECHNOLOGY	REAR ELEVATION	AR. PAUL L. CONDE, CAP PROJECT	LUCAS N. BACSA CERD, MARITIMAG, LUNEPH	MA. MARGARITA C. JUMA, D.M. REGISTERED DESIGNER, DIRECTOR	EDGAR S. TABACON, CESO IV REGISTERED ARCHITECT	DENIS A. PILLAR, E.D. REGISTERED ARCHITECT	A 7 34	10 101
	LOCATION: BRGY. CUDANGAL, PALORONIA, LEYTE		DATE:	DATE:	DATE:	DATE:	DATE:		



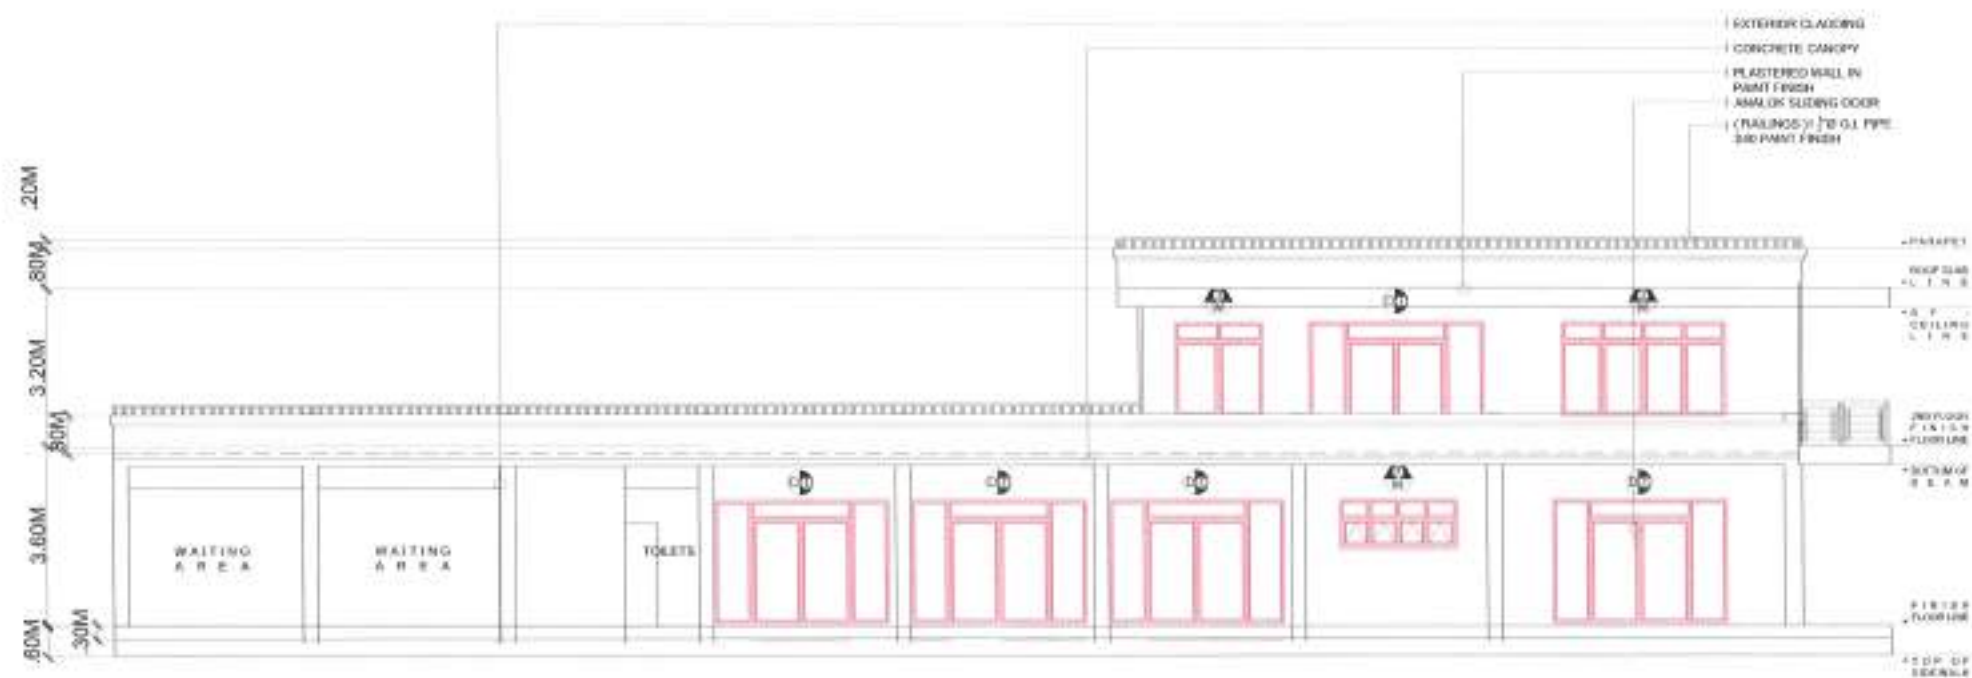


   
1 LEFT-SIDE ELEVATION
A - 8 SCALE: 1:200 MTS.

 Republic of the Philippines DEPARTMENT OF PUBLIC WORKS AND HIGHWAYS REGIONAL OFFICE NO. VIII GOVERNMENT CENTER, SARAY, PALO DUTRA	PROJECT TITLE: CONSTRUCTION OF INNOVATION INCUBATION CENTER SUB-DIV. PALAMPON INSTITUTE OF TECHNOLOGY LOCATION: BRGY. GORRAL, PALAMPON, LETE	SHEET CONTENTS: LEFT-SIDE ELEVATION	PREPARED:  AB. RAUL L. CONDE, WAP PROJECT DATE:	SUBMITTED:  LUCAS N. BACAL CHIEF, IMPROVEMENT DIVISION DATE:	RECOMMENDED:  MA. MARGARITA C. JONIA, R.M. ASSISTANT REGIONAL DIRECTOR DATE:	APPROVED:  EDGAR B. TABACON, CESO IV REGIONAL DIRECTOR DATE:	CONCURRED:  DENNIS A. DEL PILAR, E.O.D. UNIVERSITY PRESIDENT DATE:	SET NO. A 8 24	SHEET NO. 11 101
---	---	---	---	--	--	--	--	-----------------------------	-------------------------------

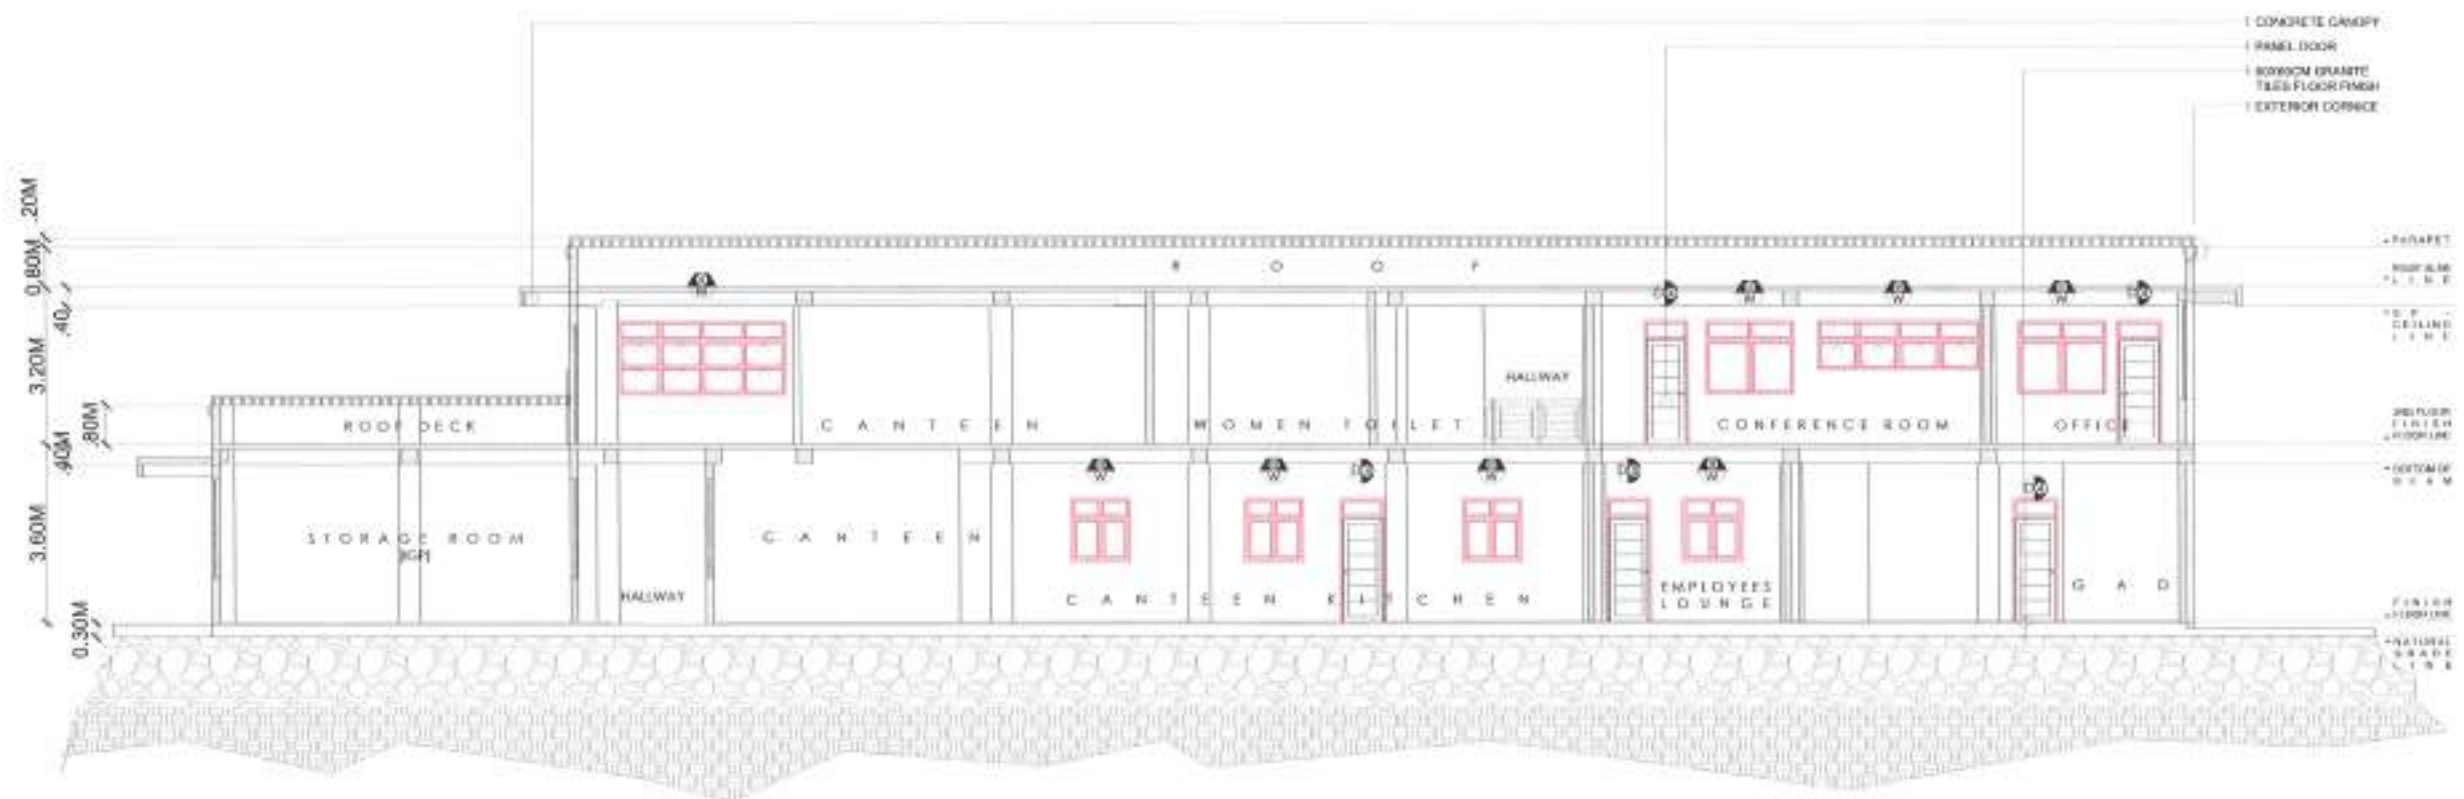


   1 LONGITUDINAL SECTION
A - 9 SCALE: 1:200 MTS.

 Republic of the Philippines DEPARTMENT OF PUBLIC WORKS AND HIGHWAYS REGIONAL OFFICE NO. VIII GOVERNMENT CENTER, SARAS, PALO LITTE	PROJECT TITLE: CONSTRUCTION OF INNOVATION INCUBATION CENTER BUILDING- PALOMPON INSTITUTE OF TECHNOLOGY LOCATION: BRID 2550M/5, PALOMPON, LITTE	SHEET CONTENTS: LONGITUDINAL SECTION	PREPARED:  AR PAUL L. CONDE, UAP ARCHITECT	SUBMITTED:  LUCKS K. BACSAI CHIEF, MAINTENANCE DIVISION	RECOMMENDED:  MA. MARGHERITA C. JUMA, D.M. ASSISTANT REGIONAL DIRECTOR	APPROVED:  EDGAR B. TABACON, CESO IV REGIONAL DIRECTOR	CONCURRED:  DENNIS A. PEAR, E&E UNIVERSITY ATTENDANT	SET NO. A 9 24	SHEET NO. 12 101
---	---	---	--	---	--	--	--	--	--

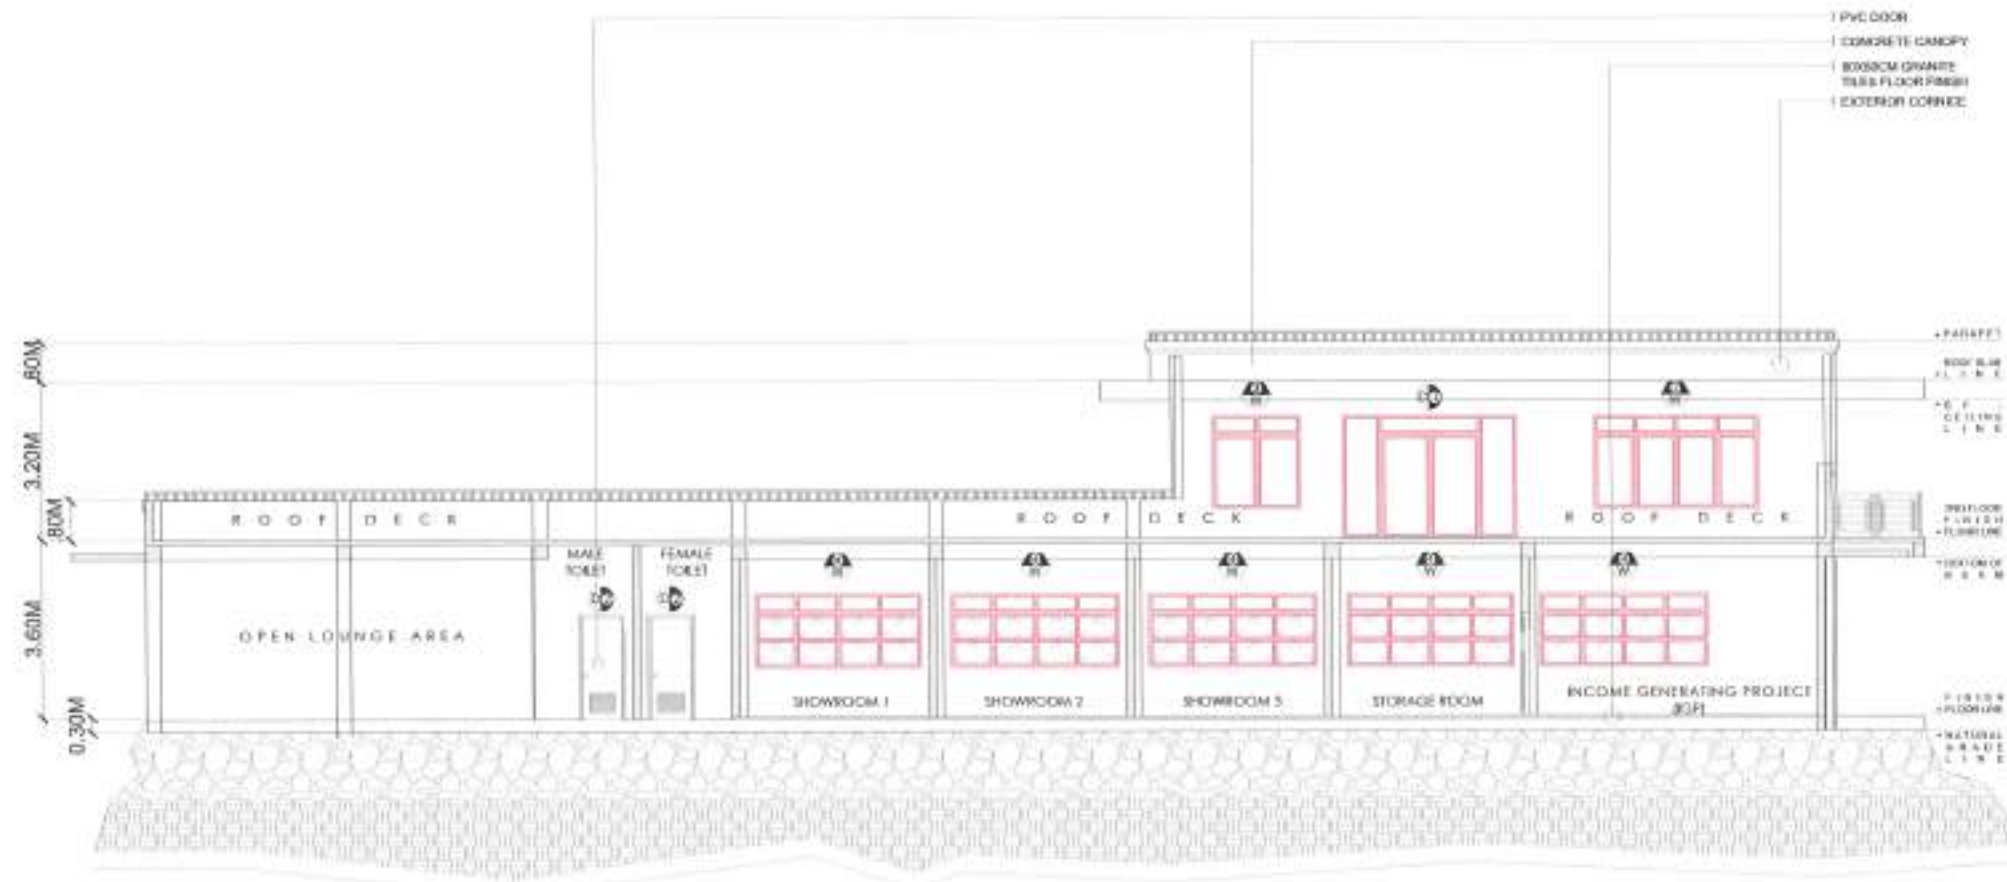

1 CROSS SECTION
A-10 SCALE: 1:200 MTS.

  Republic of the Philippines DEPARTMENT OF PUBLIC WORKS AND HIGHWAYS REGIONAL OFFICE NO. VIII GOVERNMENT CENTER, DAVAO, PALO CUYTE	PROJECT TITLE: CONSTRUCTION OF INNOVATION INCUBATION CENTER BUILDING- PALOMPON INSTITUTE OF TECHNOLOGY LOCATION: DRY, CORNER LIPALAN/QUESTE	SHEET CONTENTS: CROSS SECTION	PREPARED:  AR. PAUL L. CONDE, UAP ARCHITECT	SUBMITTED:  LUCAN H. BACSA CIVIL ENGINEER (RCE)	RECOMMENDED:  MA. MARGARITA C. JUNA, UAP ASSISTANT REGIONAL DIRECTOR	APPROVED:  EDGAR B. TARADON, CESO IV REGIONAL DIRECTOR	CONCLUDED:  DENNIS A. PILAR, Ed.D. UNIVERSITY PRESIDENT	SET NO. A 10/24	SHEET NO. 13 101
---	--	---	---	---	--	--	---	------------------------------	-------------------------------

SCHEDULE OF WINDOWS			
WINDOW 1	WINDOW 2	WINDOW 3	WINDOW 4
1.70M .85M .85M 40M 1.10M 1.00M F.F.L. TRANSOM F F F F	3.40M .85M .85M .85M .85M 40M 1.50M 0.60M F.F.L. TRANSOM F F F F F F F F	1.60M .80M .80M 40M 1.50M .60M F.F.L. TRANSOM F F F S	3.40M .85M .85M .85M .85M 40M 1.10M 1.00M F.F.L. TRANSOM F F F F F F F F F F F F F F F F
W-1 FIXED WINDOW, 2 PANELS W/ FIXED TRANSOMS ALUMINUM POWDER COAT WHITE LOCATION: LAB. OFFICE, CANTEEN OFFICE, LABORATORY	W-2 FIXED WINDOWS, 4 PANELS W/ FIXED TRANSOMS ALUMINUM POWDER COAT WHITE LOCATION: IGP, CANTEEN DINING AREA, EMPLOYEES LOUNGE, LABORATORY	W-3 FIXED & SLIDING WINDOW 2 PANELS W/ FIXED TRANSOMS ALUMINUM POWDER COAT WHITE LOCATION: CANTEEN DINING AREA	W-4 AWNING TYPE WINDOWS 8 PANELS W/ FIXED TRANSOMS ALUMINUM POWDER COAT WHITE LOCATION: IGP ROOM & STORAGE, SHOWROOMS, CANTEEN OFFICE & DINING AREA
5-SETS	11-SETS	3 SETS	7-SETS

1 SCHEDULE OF DOORS & WINDOWS
A-11 SCALE: 1:50 MTS.

SCHEDULE OF WINDOWS

WINDOW 5	WINDOW 6	WINDOW 7	WINDOW 8
W-5 AWNING TYPE WINDOWS 2 PANELS W/ FIXED TRANSOMS ALUMINUM POWDER COAT WHITE LOCATION: TOILETS, CONFERENCE RM. 5-SETS	W-6 AWNING TYPE WINDOWS SINGLE PANEL 60X60 W/ FIXED TRANSOMS ALUMINUM POWDER COAT WHITE LOCATION: TOILETS 5-SETS	W-7 AWNING TYPE WINDOWS 4 PANELS W/ FIXED TRANSOMS ALUMINUM POWDER COAT WHITE LOCATION: IGP STORAGE, GN/PWD TOILET 2-SETS	W-8 2 PANELS WINDOW 1 SLIDE, 1 FIXED W/ TRANSOMS ALUMINUM POWDER COAT WHITE LOCATION: EMPLOYEES LOUNGE PANTRY, CANTEEN OFFICE, CANTEEN KITCHEN 5-SETS

1 SCHEDULE OF DOORS & WINDOWS

A-12

SCALE: 1:50

MTS.

DEPARTMENT OF PUBLIC WORKS AND HIGHWAYS REGIONAL OFFICE NO. VIII GOVERNMENT CENTER, BANGAL, PALI, LAYTE	PROJECT TITLE:	SHEET CONTENTS:	PREPARED:	SUBMITTED:	RECOMMENDED:	APPROVED:	CONCLUDED:	SET NO.	SHEET NO.
	CONSTRUCTION OF INNOVATION INCUBATION CENTER BUILDING- PALAMPON INSTITUTE OF TECHNOLOGY	SCHEDULE OF DOORS & WINDOWS	AR. RAUL L. CORDE, UAP ARCHITECT	LUCAS N. BACAL CHIEF ARCHITECT	MA. MARGARITA C. JUMAY, D.M. ASSISTANT REGIONAL DIRECTOR	EDGAR B. TABACON, CESO IV REGIONAL DIRECTOR	REMMS A. DELA CRUZ, E.D. INTEGRITY ASSISTANT	12	15
	LOCATION: IGP STORAGE, GN/PWD, TOILET								

SCHEDULE OF WINDOWS		SCHEDULE OF DOORS	
WINDOW 9	WINDOW 10	DOOR 1	DOOR 2
W-9 AWNING TYPE WINDOW 4 PANELS W/ FIXED TRANSOMS ALUMINUM POWDER COAT WHITE LOCATION: CONFERENCE ROOM	W-10 AWNING TYPE WINDOW 4 PANELS W/ FIXED TRANSOMS ALUMINUM POWDER COAT WHITE LOCATION: GAD, LAB. OFFICE, LABORATORY	D-1 2-SLIDING DOORS, 2-FIXED DOORS @ SIDES W/ FIXED TRANSOMS ALUMINUM POWDER COAT WHITE W/ CLEAR GLASS LOCATION: SHOWROOMS, IGP ROOM, GF CANTEN ENTRANCE, 2F CANTEN ENTRANCE & EXIT, GAD ENTRANCE, EMPLOYEES LOUNGE	D-2 2-SWING TYPE GLASS DOORS W/ CLEAR GLASS W/ FIXED TRANSOMS ALUMINUM POWDER COAT WHITE LOCATION: 2ND ENTRANCE CANTEN DINING AREA (ADJACENT TO STAIRS)
1 SET	4 SETS	9-SETS	1-SET

1
A-13 **SCHEDULE OF DOORS & WINDOWS**
SCALE: 1:50 MTS.

	PROJECT TITLE:	SHEET CONTENTS:	PREPARED:	SUBMITTED:	RECOMMENDED:	APPROVED:	CONCURRED:	SET NO.	SHEET NO.
	CONSTRUCTION OF INNOVATION INCUBATION CENTER BUILDING - PALAMPOR INSTITUTE OF TECHNOLOGY	SCHEDULE OF DOORS & WINDOWS	ARJUNAL L. COMDE, UAP	LUCAS N. BACAL	MA. MARGARITA C. JUNA, D.M.	EDGAR B. TABACON, CESO IV	DENNIS A. PILAR, E.D.	13	101

SCHEDULE OF DOORS				
DOOR 3	DOOR 4	DOOR 5	DOOR 6	DOOR 7
D-3 SWING TYPE GLASS DOOR W/ CLEAR GLASS W/ FIXED TRANSOMS ALUMINUM POWDER COAT WHITE LOCATION:2ND. FLOOR CANTEEN ENTRANCE, GAD, CANTEEN EXIT	D-4 WOOD PANEL DOOR SWING TYPE W/ FIXED TRANSOM LOCATION:IGP STORAGE, GAD EXIT, LAB. OFFICE ENTRANCE & EXIT, CANTEEN OFFICE, CANTEEN KITCHEN EXIT, LABORATORY EXIT, GN/PWD TOILETS, EMPLOYEES LOUNGE, CONFERENCE ROOM	D-5 WOOD PANEL DOOR SWING TYPE W/ FIXED TRANSOM LOCATION:TOILETS MALE & FEMALE,CANTEEN STORAGES	D-6 GLASS DOOR SWING TYPE ALUMINUM POWDER COAT WHITE DOOR LOCATION:LABORATORY ENTRANCE	D-7 FLUSH DOOR W/ FIXED TRANSOM LOCATION:GAD CR, EMPLOYEES LOUNGE CR
4-SETS	13-SETS	8-SETS	1-SET	2-SETS

1 SCHEDULE OF DOORS & WINDOWS



GROUND FLOOR CANTEEN
1
A-15 **DETAIL OF PUBLIC TOILET**
 SCALE: 1:40 MTS.



Republic of the Philippines
 DEPARTMENT OF PUBLIC WORKS AND HIGHWAYS
 REGIONAL OFFICE NO. VIII
 GOVERNMENT CENTER, PAMANG, PANGasinan

PROJECT TITLE:
 CONSTRUCTION OF INNOVATION INCUBATION CENTER BUILDING-
 PALCAMPON INSTITUTE OF TECHNOLOGY
 LOCATION: BAYAN, PANGASINAN

SHEET CONTENTS:
 DETAIL OF PUBLIC TOILET

PREPARED:
 AIR. PAUL L. CONDE, MAP
 ARCHITECT
 DATE:


SUBMITTED:
 LUCAS N. BACSAI
 CIVIL ENGINEER
 DATE:

RECOMMENDED:
 MA. MARGHERITA C. JUAN, S.M.
 ASSISTANT REGIONAL DIRECTOR
 DATE:

APPROVED:
 EDUAR B. TARACON, CESO IV
 REGIONAL DIRECTOR
 DATE:

CONCURRED:
 DENNIS A. MANIPLAR, E.S.O.
 UNIVERSITY RESEARCH
 DATE:

SET NO. SHEET NO.
 A 18
 15 24 101

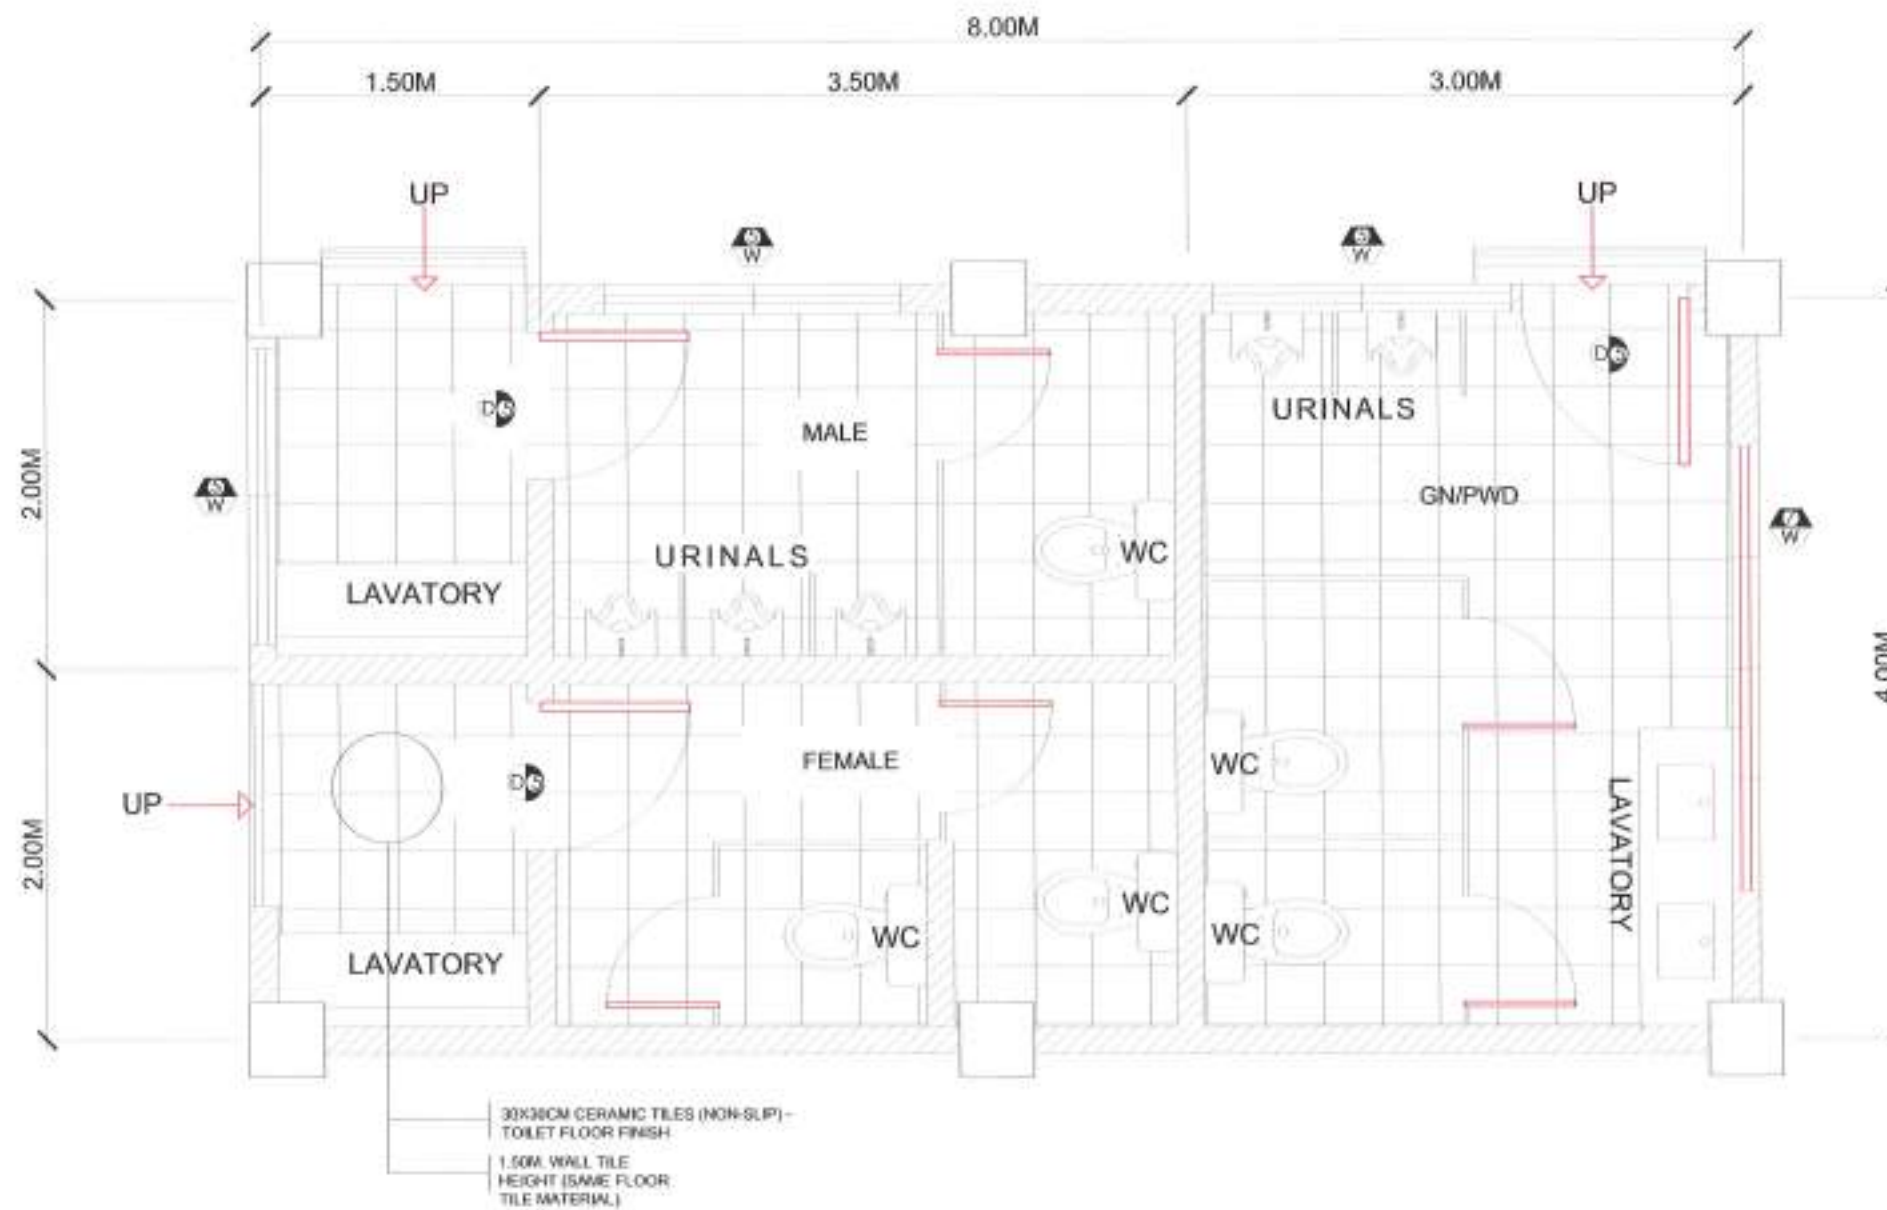

GROUND FLOOR OPEN LOUNGE AREA
1
A-16 **DETAIL OF PUBLIC TOILET**
SCALE: 1:40 MTS.



Republic of the Philippines
DEPARTMENT OF PUBLIC WORKS AND HIGHWAYS
REGIONAL OFFICE NO. VIII
GOVERNMENT CENTER, NARAYAN, PALO CUYE

PROJECT TITLE:
CONSTRUCTION OF INNOVATION INCUBATION CENTER BUILDING-
PALOMPON INSTITUTE OF TECHNOLOGY
LOCATION: 0007, SUBAN (PALOMPON SITE)

SHEET CONTENTS:
DETAIL OF PUBLIC TOILET

PREPARED:
AR. PAUL L. CONDE, UAP
ARCHITECT


SUBMITTED:
LUCAS N. BACAL
CITY ARCHITECT

RECOMMENDED:
MA. MARGARITA C. JUNA, UAP
ASSISTANT REGIONAL DIRECTOR

APPROVED:
EDGAR S. TABACON, CESO IV
REGIONAL DIRECTOR


CONCURRED:
DENNIS A. DELA LARA, Ed.D.
UNDER SECRETARY

SET NO. 11
101

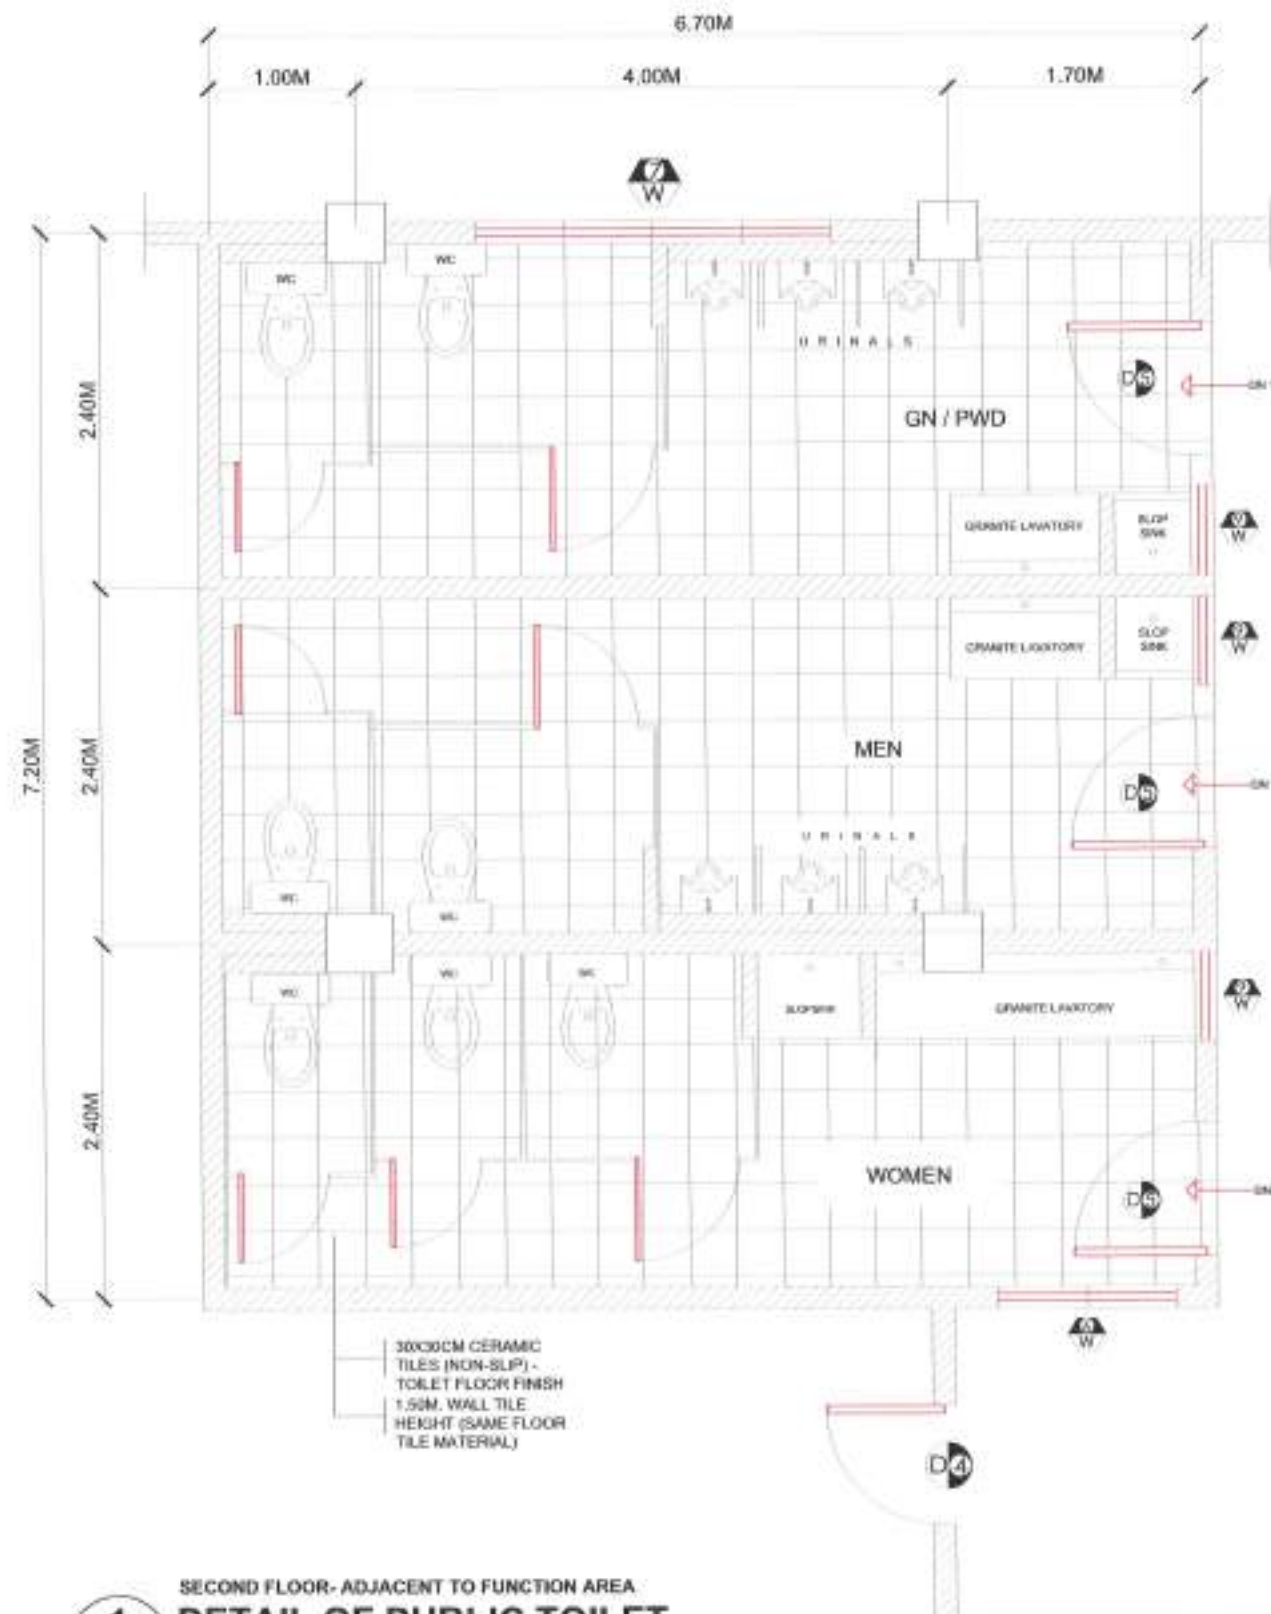

1
A-17
SECOND FLOOR- ADJACENT TO FUNCTION AREA
DETAIL OF PUBLIC TOILET
SCALE: 1:40
MTS.


 Republic of the Philippines DEPARTMENT OF PUBLIC WORKS AND HIGHWAYS REGIONAL OFFICE NO. VIII GOVERNMENT CENTER, MARIC, PALO LITTE	PROJECT TITLE: CONSTRUCTION OF INNOVATION ACQUISITION CENTER BUILDING HALOPOPO INSTITUTE OF TECHNOLOGY LOCATION: BRP, ALONSOY, PALORIN, 12110	SHEET CONTENTS: DETAIL OF PUBLIC TOILET	PREPARED: AIR PAUL L. CONDE, UAP ARCHITECT	SUBMITTED: LUCAS N. BACSA DEPT. ARCHITECTURE DIVISION	RECOMMENDED: RIA MARGORITA C. JUAN, O.M. ASSISTANT REGIONAL DIRECTOR	APPROVED: EDUAR E. TABACON, CESO IV REGIONAL DIRECTOR	CONCURRED: JENNIS A. DELA CRUZ, Ed.D. UNIVERSITY PRESIDENT	SHEET NO. A 17/24	SHEET NO. 20 101
--	---	--	---	--	---	--	---	----------------------------------	---------------------------------

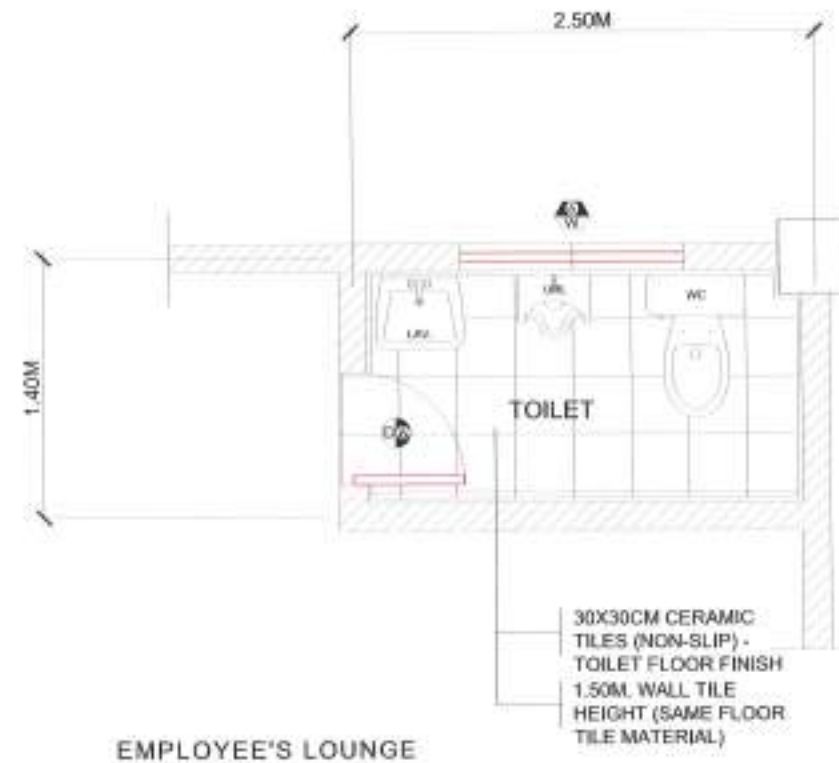


EMPLOYEE'S LOUNGE

EMPLOYEE'S LOUNGE
1
A-18 **DETAIL OF PUBLIC TOILET**
 SCALE: 1:40 MTS.


 Republic of the Philippines DEPARTMENT OF PUBLIC WORKS AND HIGHWAYS REGIONAL OFFICE NO. VIII ENVIRONMENT CENTER, BARRIO PALO LUYTE	PROJECT TITLE	SHEET CONTENTS	PREPARED	SUBMITTED	RECOMMENDED	APPROVED	CONFERRED	SET NO.	SHEET NO.
	CONSTRUCTION OF INNOVATION INCUBATION CENTER BUILDING- PALOMPON INSTITUTE OF TECHNOLOGY	DETAIL OF PUBLIC TOILET	 AR. PAUL L. CONDE, UAP ARCHITECT	 LUCAS M. SACSAN CHIEF, MAINTENANCE DIVISION	 MA. MARGARITA C. JUMA, D.M. ASSISTANT REGIONAL DIRECTOR	 EDGAR B. TABACON, CESO III REGIONAL DIRECTOR	 DENNIS A. PALAR, Ed.D. UNIVERSITY REPRESENTATIVE		

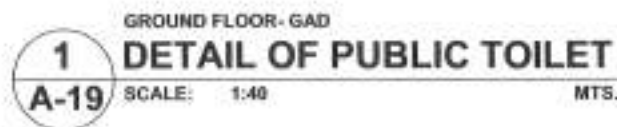

 Republic of the Philippines DEPARTMENT OF PUBLIC WORKS AND HIGHWAYS REGIONAL OFFICE NO. VIII GOVERNMENT CENTER, BARAS, PALO LEYTE	PROJECT TITLE:	SHEET CONTENTS:	PREPARED BY:	SUBMITTED:	RECOMMENDED:	APPROVED:	CONCURRED:	SET NO.	SHEET NO.
	CONSTRUCTION OF INNOVATION INCUBATION CENTER BUILDING- PALOMPOH INSTITUTE OF TECHNOLOGY	DETAIL OF PUBLIC TOILET	 AR PAUL L. COMDE, UAP ARCHITECT	 LUCAS M. SACSAN CHIEF, MAINTENANCE DIVISION	 MA. MARGARITA C. JUMA, DEM ASSISTANT REGIONAL DIRECTOR	 EDGAR B. TABACON, CESO IV REGIONAL ENGINEER	 DENNIS A. DELA CRUZ, Ed.D. UNIVERSITY REPRESENTATIVE	A 15 24	22 101
	LOCATION: BICAY, CUSAN, PALAMON, LEYTE		DATE:	DATE:	DATE:	DATE:	DATE:		

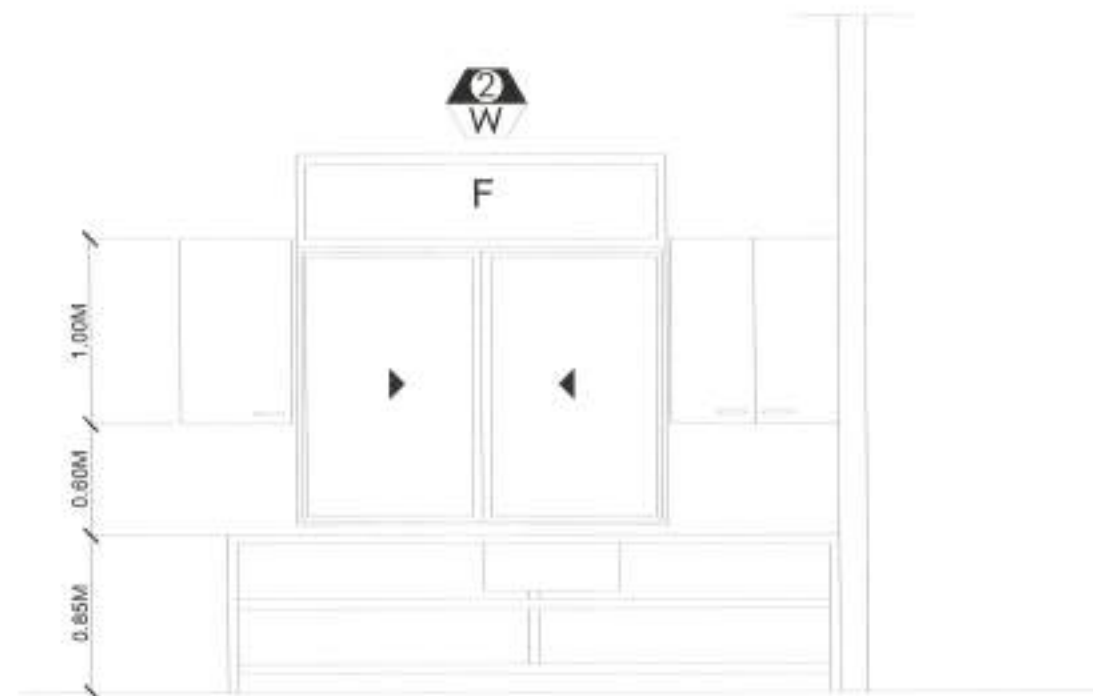

ELEVATION

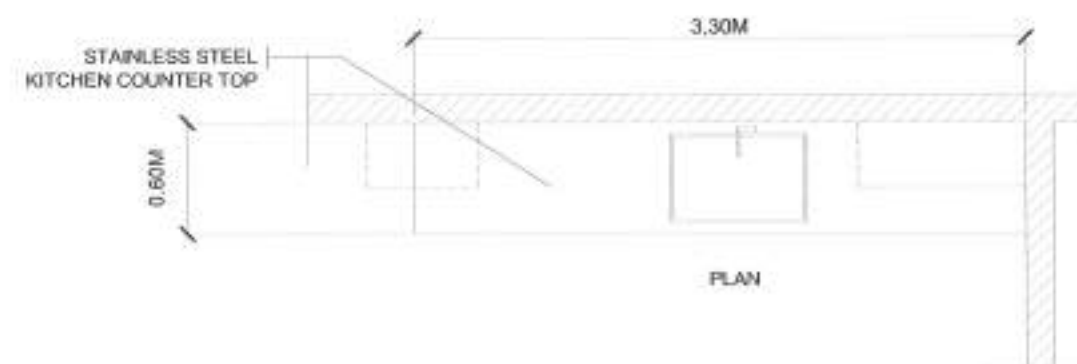

PLAN

GROUND FLOOR- CANTEEN

1

DETAIL OF COUNTERTOP

A-20

SCALE: 1:40

MTS.



Republic of the Philippines
DEPARTMENT OF PUBLIC WORKS AND HIGHWAYS
REGIONAL OFFICE NO. VIII
ISMAELANT CENTER, BAKAS, PALO-LUYTE

PROJECT TITLE:

CONSTRUCTION OF INNOVATION INCUBATION CENTER BUILDING-
PALOMPON INSTITUTE OF TECHNOLOGY

LOCATION: BRG. GUANILAN, PALOMPON, COTABATO

SHEET CONTENTS:

DETAIL OF COUNTERTOP

PREPARED:

AR. PAUL L. COMDE, UAP
ARCHITECT

DATE:

SUBMITTED:

LUCASIN BACSA,
CHIEF, MAINTENANCE DIVISION

DATE:

RECOMMENDED:

MA. NARCISWEE JUNA, D.M.,
REGIONAL PROJECT DIRECTOR

DATE:

APPROVED:

EDGAR B. TABACON, CESO IV
REGIONAL DIRECTOR

DATE:

CONCURRED:

DENNIS A. DELA LARA, E.O.
UNIVERSITY REPRESENTATIVE


DATE:

SET NO.

A
20/24


SHEET NO.

23
101



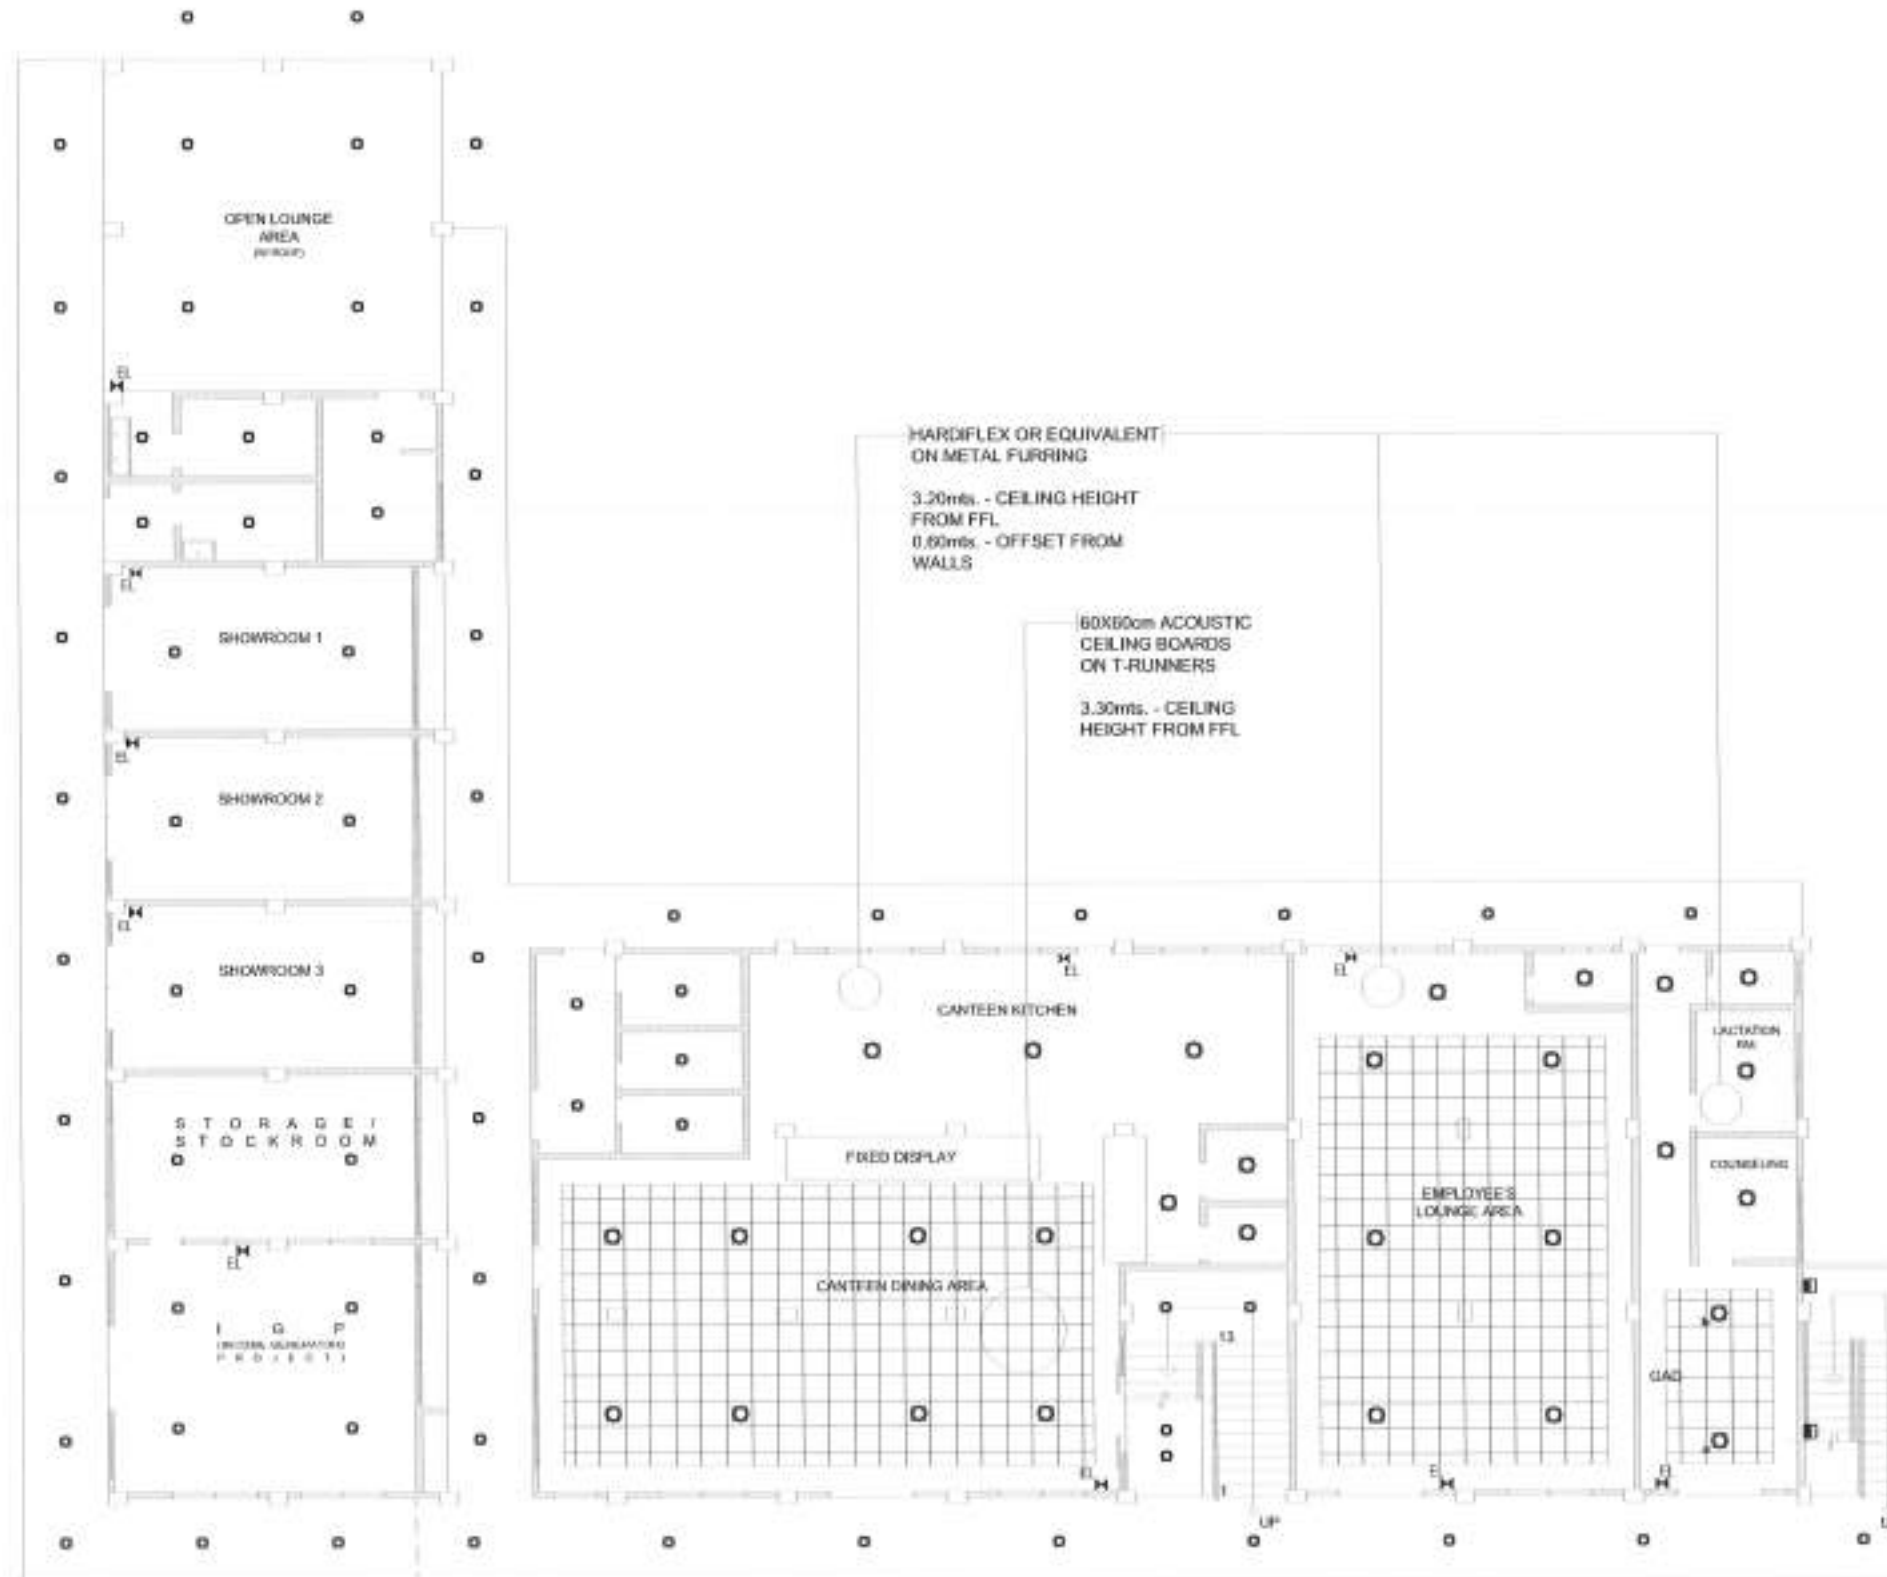



REFLECTED CEILING PLAN
1
A-21 **GROUND FLOOR**
 SCALE: 1:200 MTS.

 Republic of the Philippines DEPARTMENT OF PUBLIC WORKS AND HIGHWAYS REGIONAL OFFICE NO. VIII GOVERNMENT CENTER, DAVAO, S.M. D. LAYTE	PROJECT TITLE:	SHEET CONTENTS:	PREPARED:	SUBMITTED:	RECOMMENDED:	APPROVED:	CONCURRED:	SHEET NO.	SHEET NO.
	CONSTRUCTION OF INNOVATION INCUBATION CENTER BUILDING - PALAMPON INSTITUTE OF TECHNOLOGY	GROUND FLOOR REFLECTED CEILING PLAN	AN. MAUL L. CONDE, UAP ARCHITECT	LUCAS N. BARRAL CHIEF ENGINEER - CIVIL	MA. MARGARITA O. JUNIA, E.M. ASSISTANT REGIONAL DIRECTOR	EDGAR B. TABACON, CESO IV REGIONAL DIRECTOR	DENNIS A. DELA PLATA, Ed.D. UNIVERSITY PRESIDENT	A 21 24	25 101
	LOCATION: BRP, QUINCE, PALAMPON, ILO								

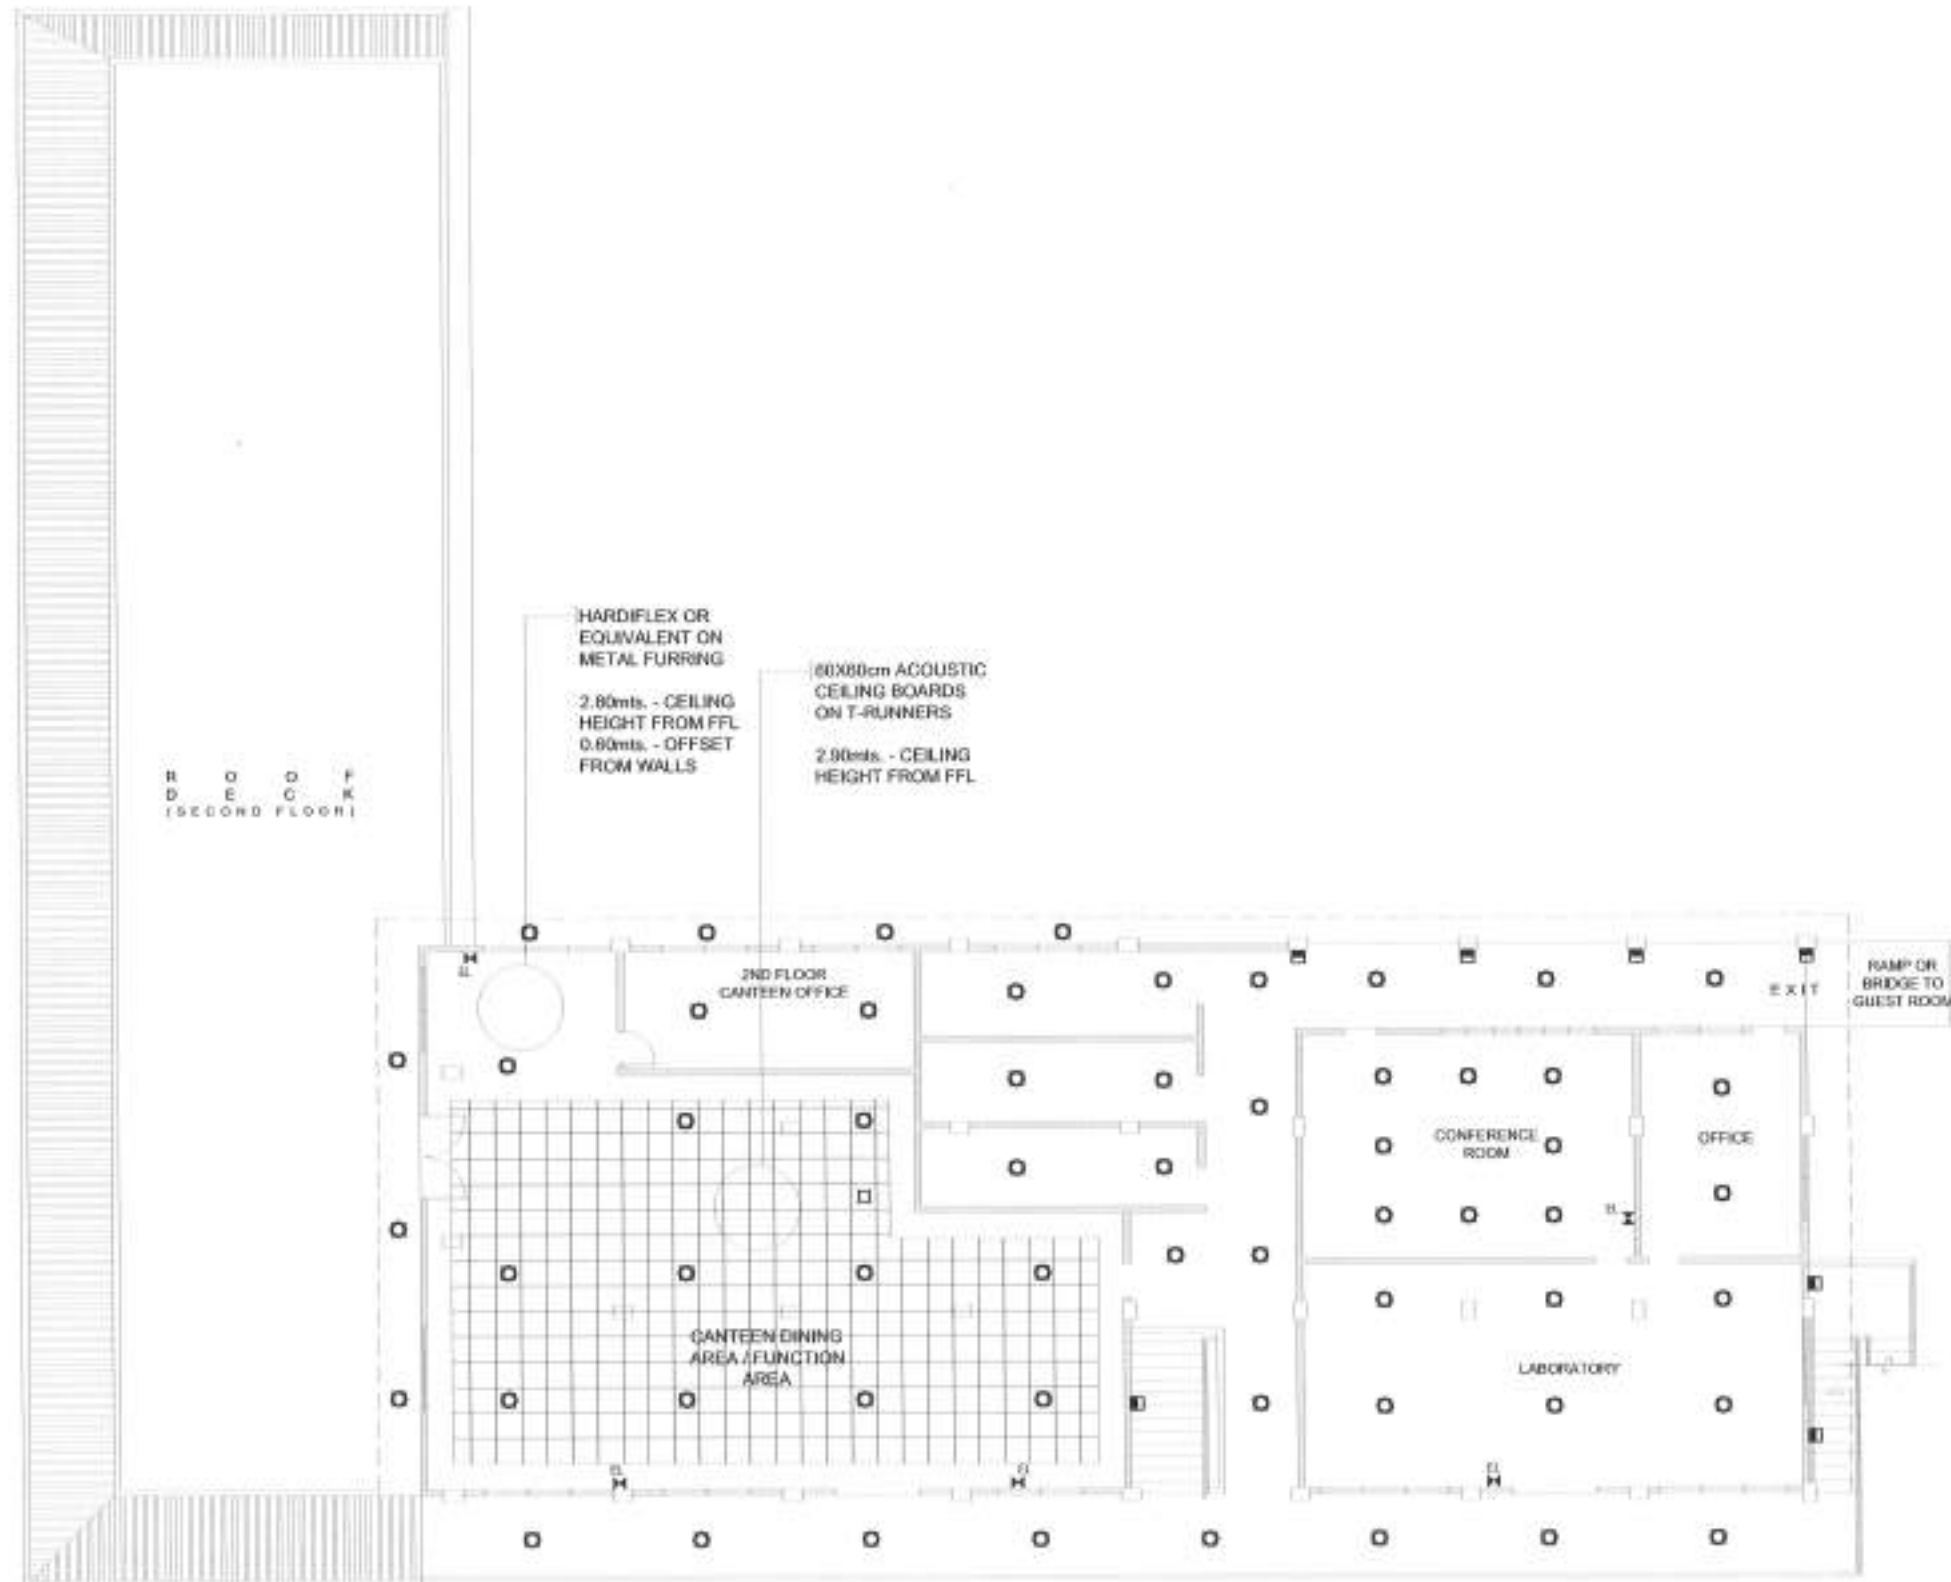

   
REFLECTED CEILING PLAN
1 SECOND FLOOR
A-22 SCALE: 1:200 MTS.

 Republic of the Philippines DEPARTMENT OF PUBLIC WORKS AND HIGHWAYS REGIONAL OFFICE NO. VIII GOVERNMENT CENTER, SARAL, PALO LEYTE	PROJECT TITLE: CONSTRUCTION OF INNOVATION INCUBATION CENTER BUILDING- PALAMPON INSTITUTE OF TECHNOLOGY	SHEET CONTENTS: SECOND FLOOR REFLECTED CEILING PLAN	PREPARED BY:  AR. PAUL L. COMDE, UAP ARCHITECT	SUBMITTED BY:  LUCAS M. SACSAL CHIEF ARCHITECT	RECOMMENDED BY:  MA. MARGARITA C. JUMA, UAP ASSISTANT REGIONAL DIRECTOR	APPROVED BY:  EDGAR S. TABACON, CESO IV REGIONAL DIRECTOR	CONFERRED BY:  DENNIS A. DEL PILAR, Ed.D. UNIVERSITY PRESIDENT	SET NO. SHEET NO. A 25 23 24 101
---	---	---	---	---	--	--	---	---

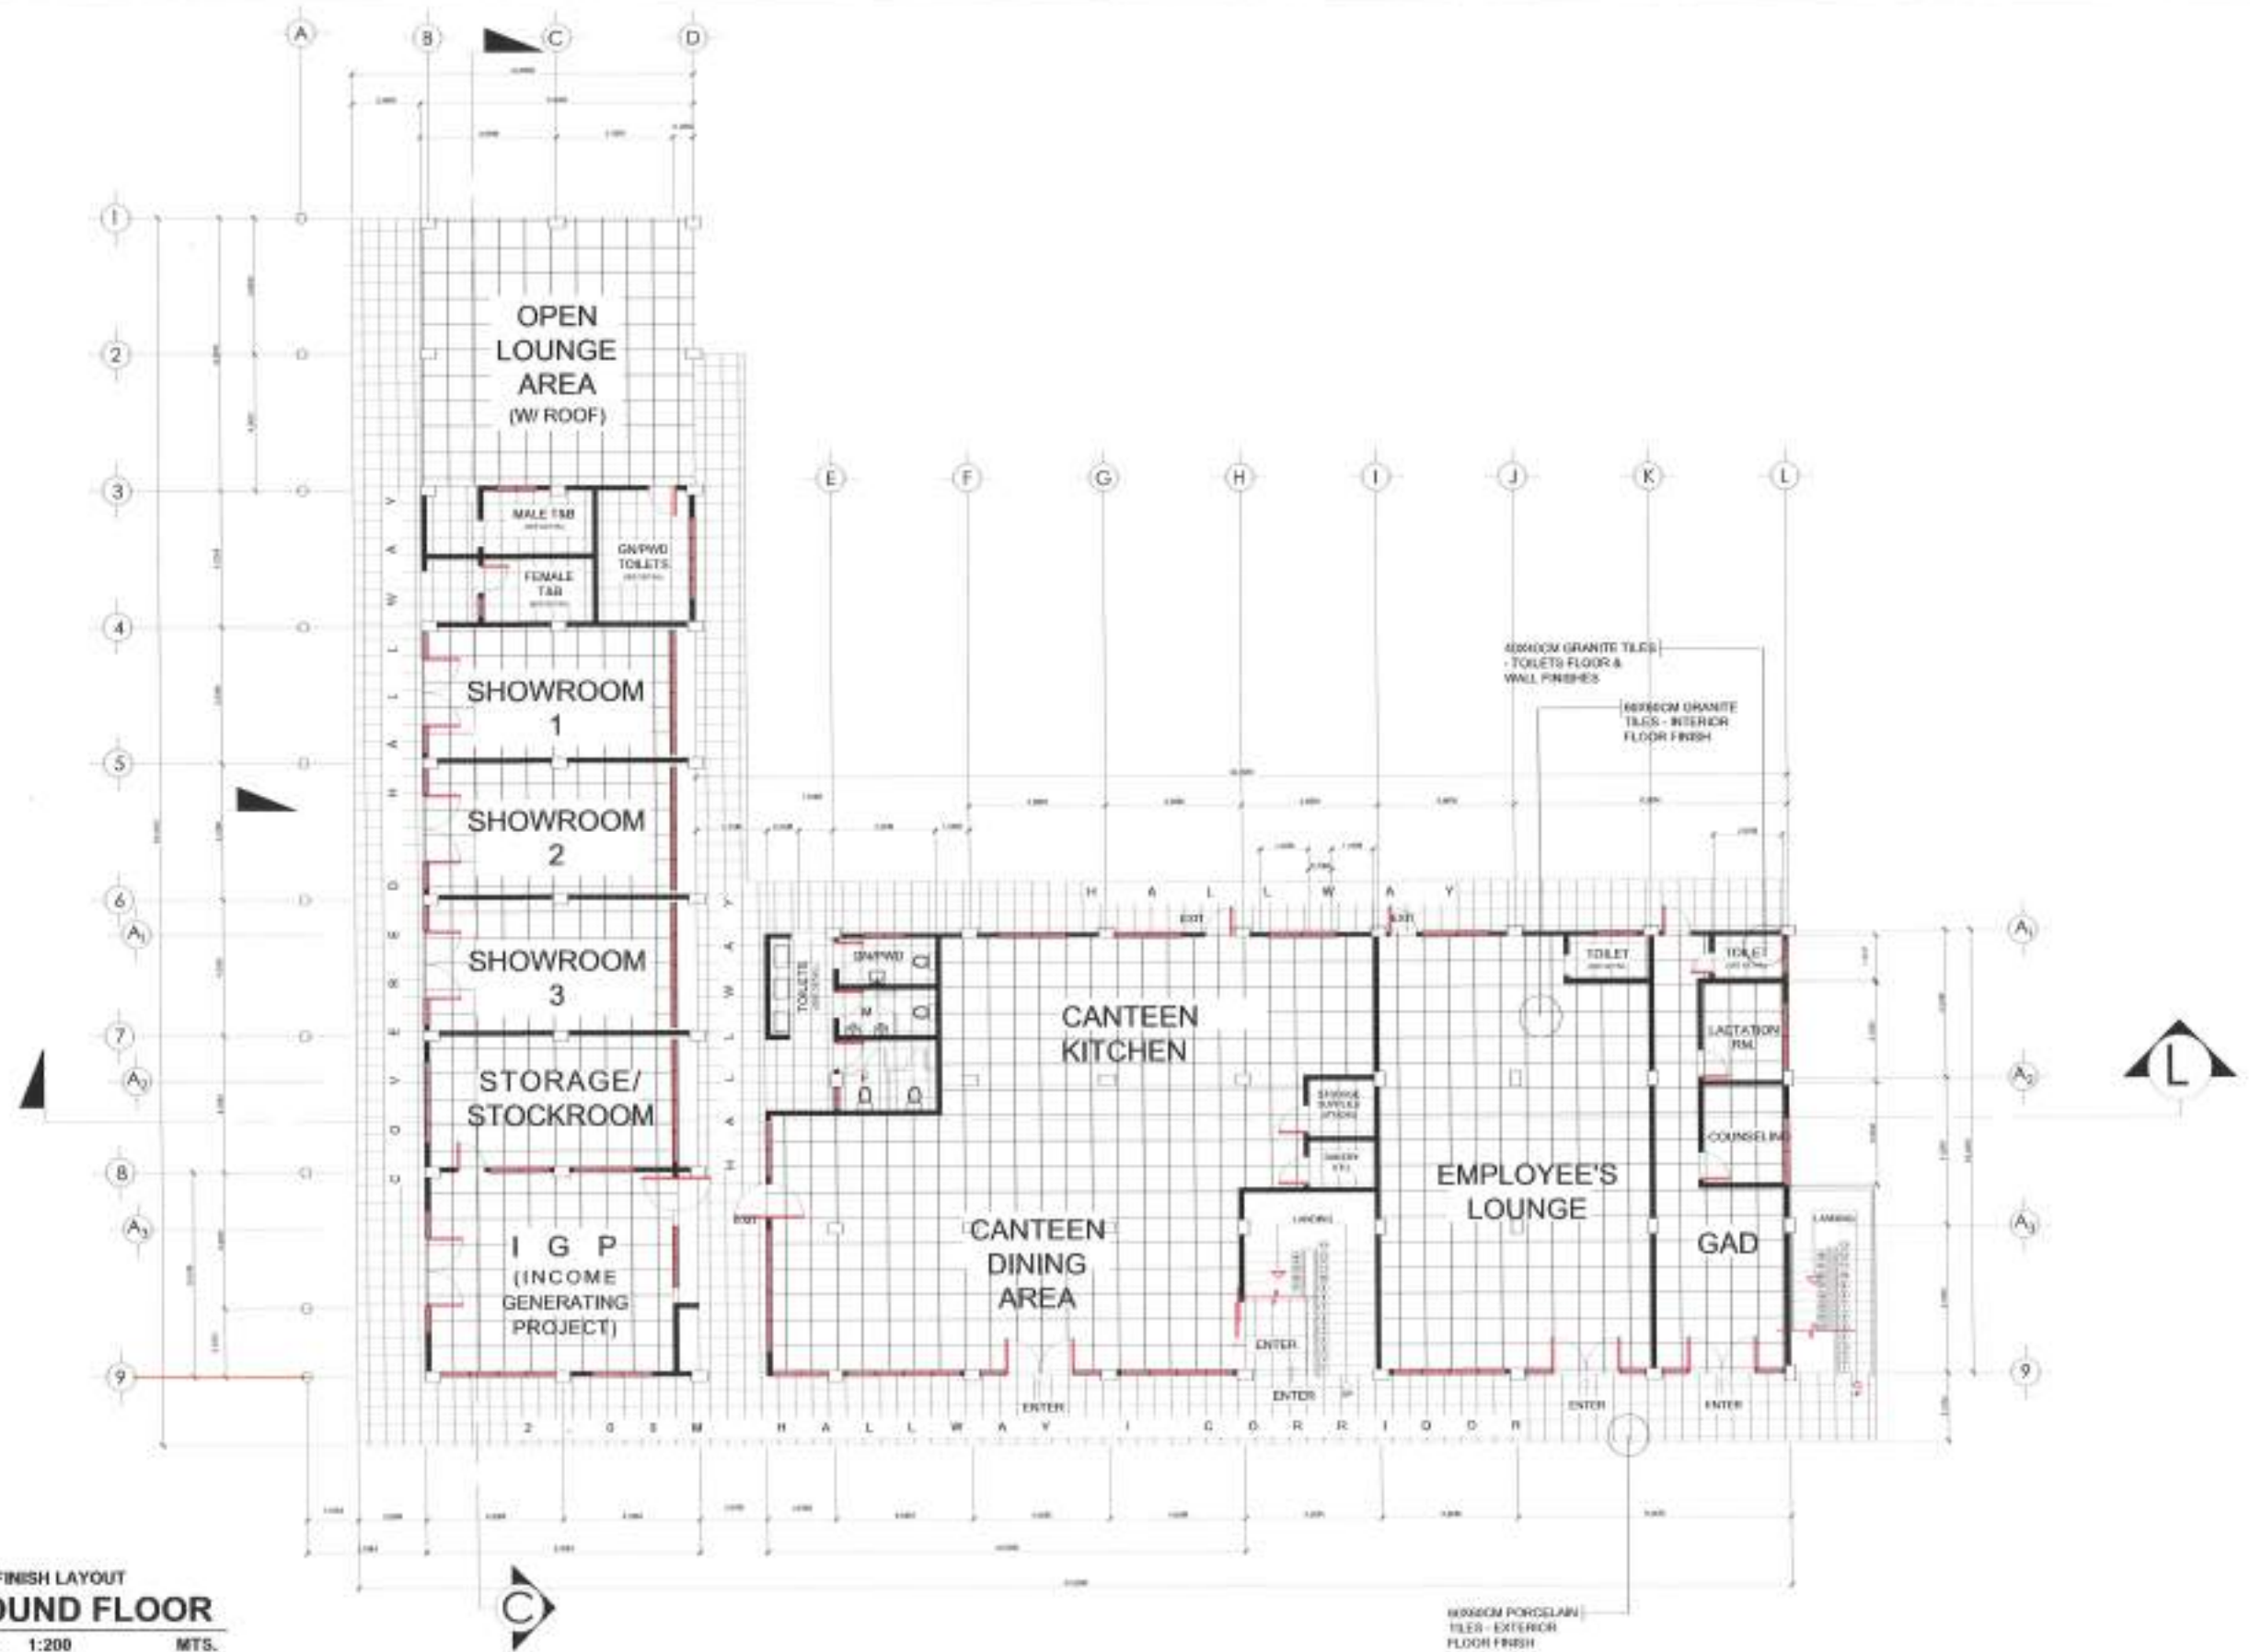



1
A-23 FLOOR FINISH LAYOUT
GROUND FLOOR
SCALE: 1:200 MTS.

 Republic of the Philippines DEPARTMENT OF PUBLIC WORKS AND HIGHWAYS REGIONAL OFFICE NO. VIII GOVERNMENT CENTER, ANRAZ, PALOYENTE	PROJECT TITLE: CONSTRUCTION OF INNOVATION INCUBATION CENTER BUILDING - PALOYENTE INSTITUTE OF TECHNOLOGY LOCATION: BRP, GUZMAN, PALOYENTE, ILOILO	SHEET CONTENTS: GROUND FLOOR FLOOR FINISH LAYOUT	PREPARED BY: ANPAUL L. CONDE, CAP ARCHITECT	SUBMITTED BY: LUCAS N. BACAL CHIEF, ARCHITECTURE DESIGN	RECOMMENDED BY: MA. MARGARITA C. JUNIA, D.E. HUMAN RESOURCE DIRECTOR	APPROVED BY: EDGAR R. TABACON, CESO IV REGIONAL DIRECTOR	CONCURRED BY: DOMINIC A. DELA CRUZ, E.S.O. UNIVERSITY SUPERVISOR	SHEET NO. 25 SET NO. 101
---	---	---	--	--	---	---	---	-------------------------------------

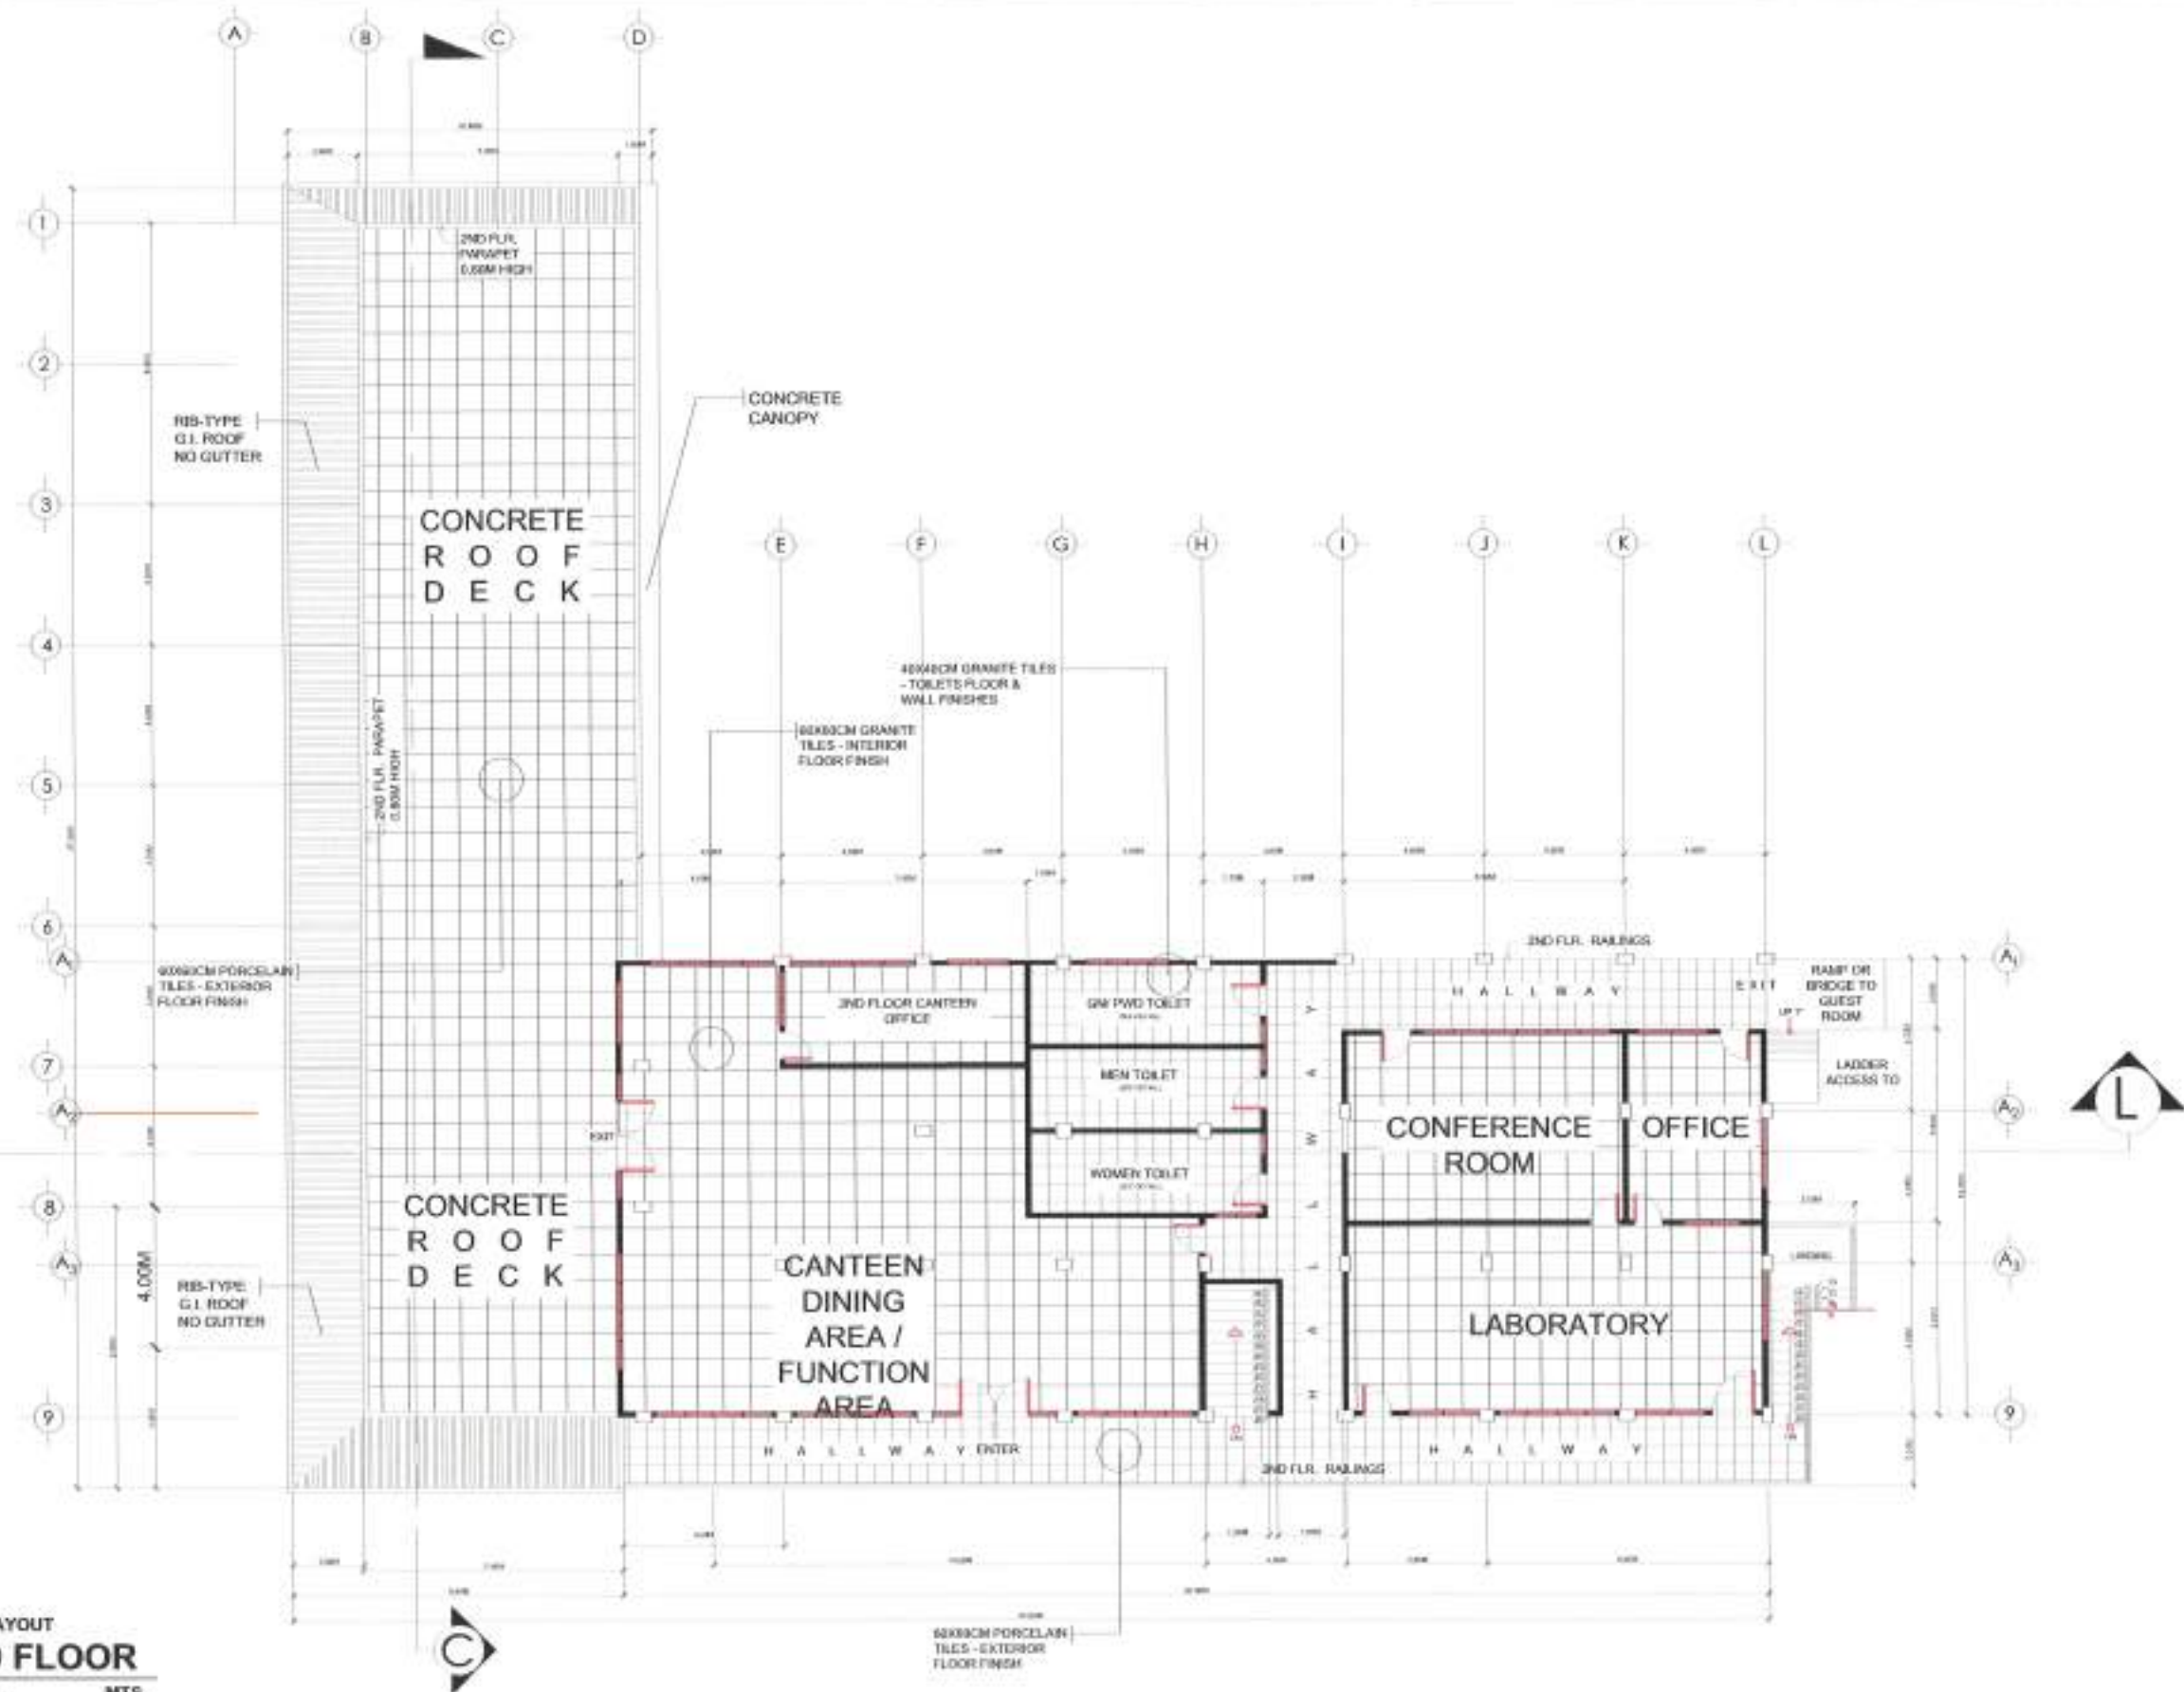

 1
A-24 FLOOR FINISH LAYOUT
SECOND FLOOR
SCALE: 1:200 MTS.

 Republic of the Philippines DEPARTMENT OF PUBLIC WORKS AND HIGHWAYS REGIONAL OFFICE NO. VIII GOVERNMENT CENTER, BALAL PAGO CITY	PROJECT TITLE: CONSTRUCTION OF INNOVATION INCUBATION CENTER BUILDING- PALOMPON INSTITUTE OF TECHNOLOGY LOCATION: DIST. DORAN & PALOMPON, LEYTE	SHEET CONTENTS: SECOND FLOOR FLOOR FINISH LAYOUT	PREPARED:  AR. PAUL L. COMDE, UAP (ARCHITECT)	SUBMITTED:  LUCAS M. BACSAI CHIEF ARCHITECT/DESIGNER	RECOMMENDED:  MEL M. MARITA, CESO IV REGIONAL ENGINEER - DISTRICT	APPROVED:  EDGAR B. TABACON, CESO IV REGIONAL DIRECTOR	CONCURRED:  DENNIS A. AGUILAR, E.L.D. LABORER/ASSISTANT	SHEET NO. 24 SHEET NO. 27
--	--	---	---	--	---	--	---	--------------------------------------

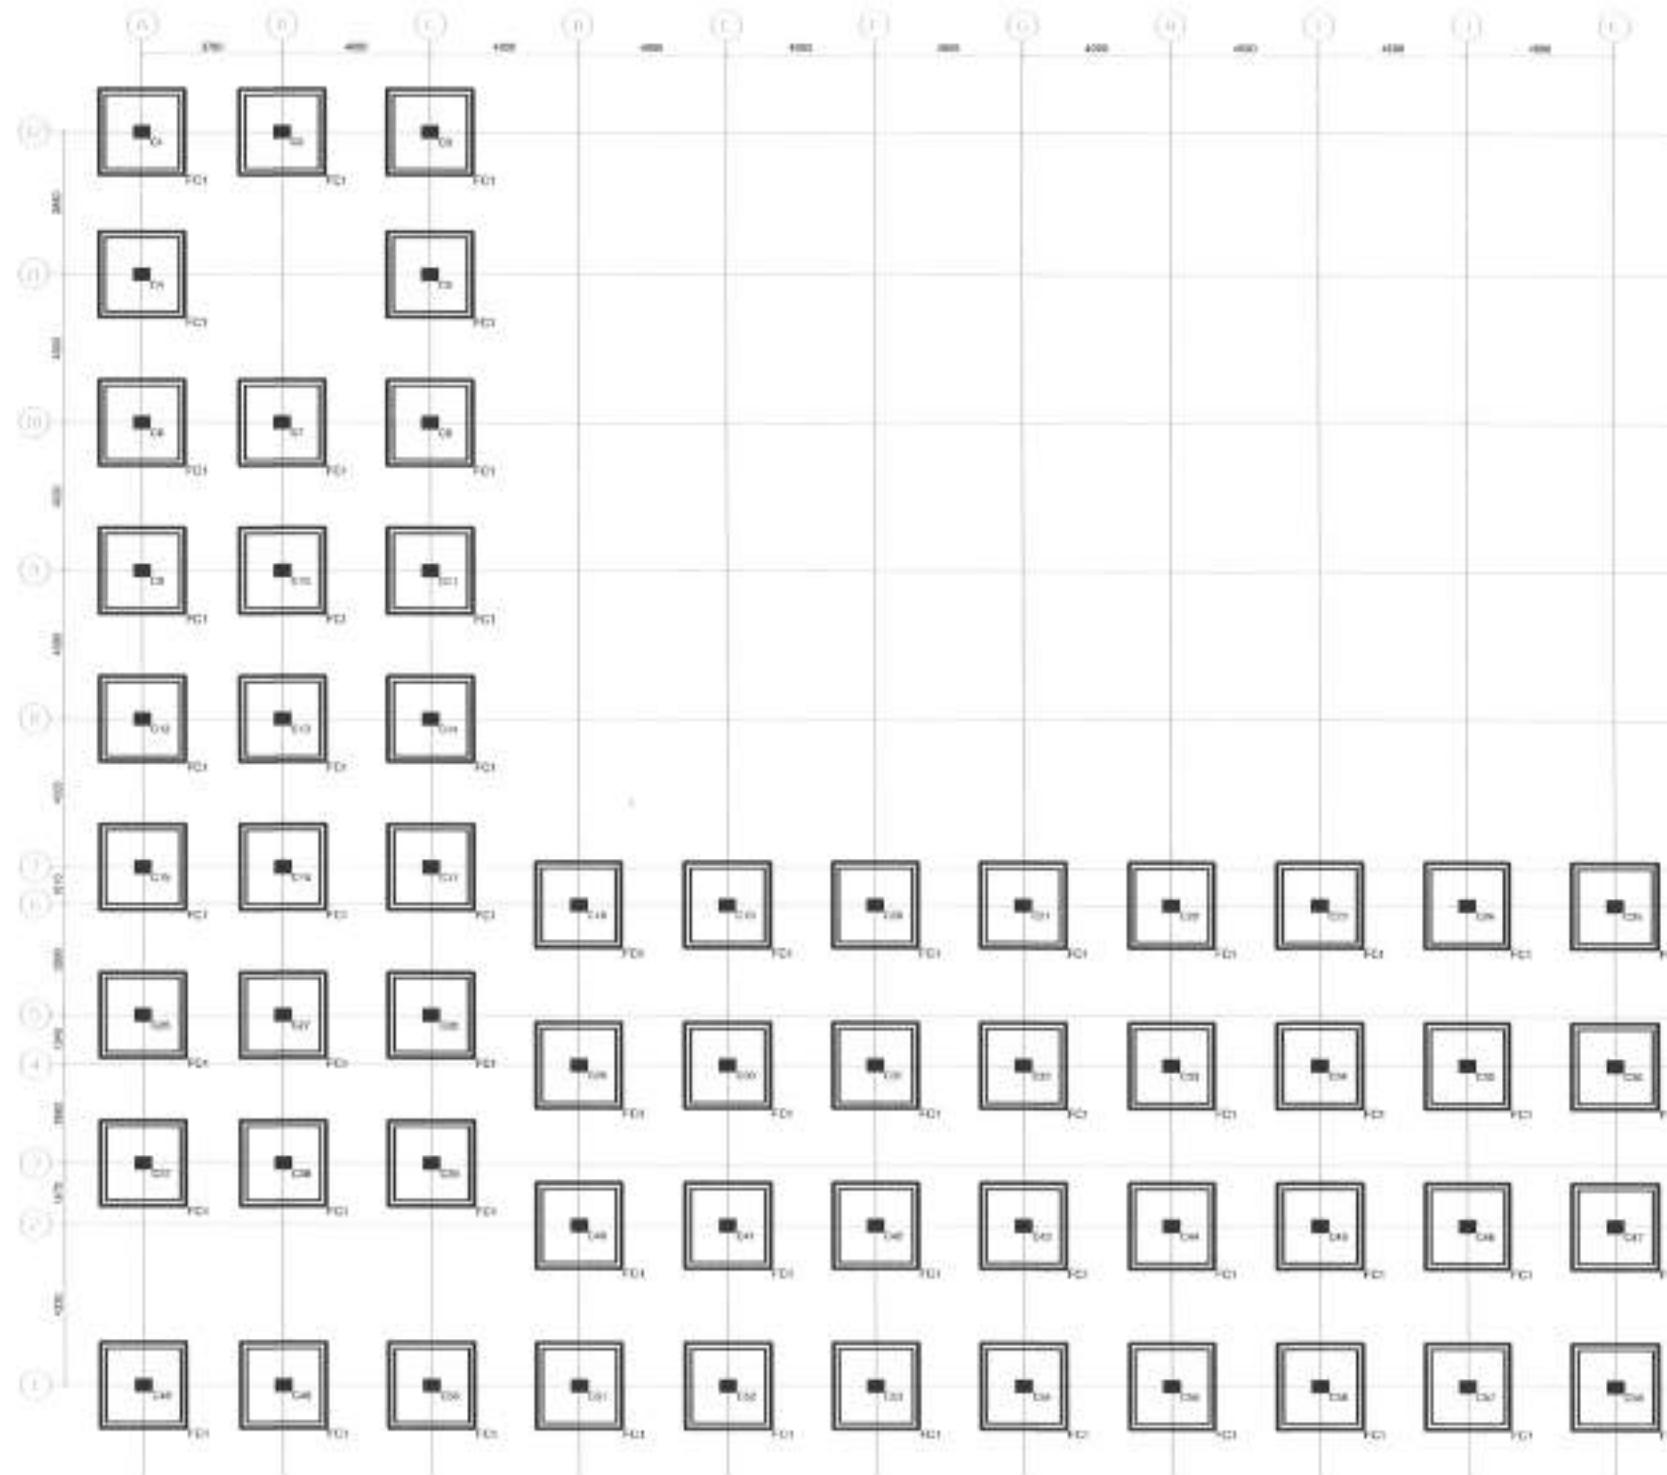

FOOTING	C45Fy414	SHORT DIR	#16@250 C/C
		LONG DIR	#16@250 C/C
		D.d	300
		SIZE	2000 x 2000
P.C.C		150 THK	2300 x 2300
COLUMNS MARKED			C1, C2, C3, C4 C5, C6, C7, C8 C9, C10, C11, C12 C13, C14, C15, C16 C17, C18, C19, C20 C21, C22, C23, C24 C25, C26, C27, C28 C29, C30, C31, C32 C33, C34, C35, C36 C37, C38, C39, C40 C41, C42, C43, C44 C45, C46, C47, C48 C49, C50, C51, C52 C53, C54, C55, C56 C57, C58

FOOTING SCHEDULE

1 FOUNDATION PLAN
S - 1 SCALE: 1:200 MTS.



Republic of the Philippines
DEPARTMENT OF PUBLIC WORKS AND HIGHWAYS
REGIONAL OFFICE NO. VIII
GOVERNMENT CENTER, DAVAO PALO LEYTE

PROJECT TITLE:
CONSTRUCTION OF INNOVATION INCUBATION CENTER BUILDING-
PALOMPON INSTITUTE OF TECHNOLOGY
LOCATION: BRP GUAN S. PALOMPON, DAVAO

SHEET CONTENTS:
FOUNDATION PLAN

PREPARED:
ENGR. ELZAR JOSEPH T. RAZLEA-AN
STRUCTURAL ENGINEER
DATE:




SUBMITTED:
JUAN K. BARRAL
CHIEF ARCHITECT, DESIGN
DATE:

RECOMMENDED:
MA MARGARITA O. JUHA, E.M.
REGISTERED ELECTRICAL ENGINEER
DATE:

APPROVED:
EDGAR S. TABACON, CESO IV
REGIONAL DIRECTOR
DATE:

CONCURRED:
DENNIS A. DELA LARA, Ed.D.
(BACD PRESIDENT)
DATE:

SHEET NO.
8
156
28
101

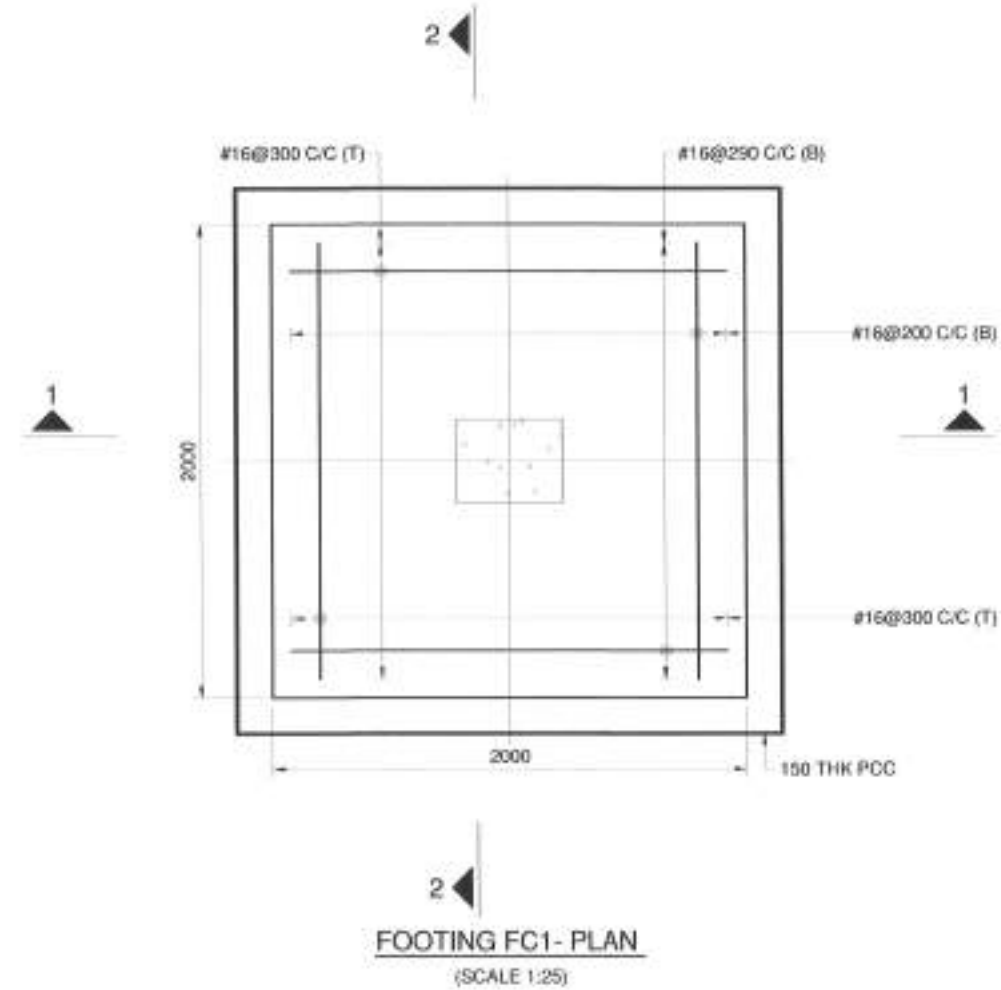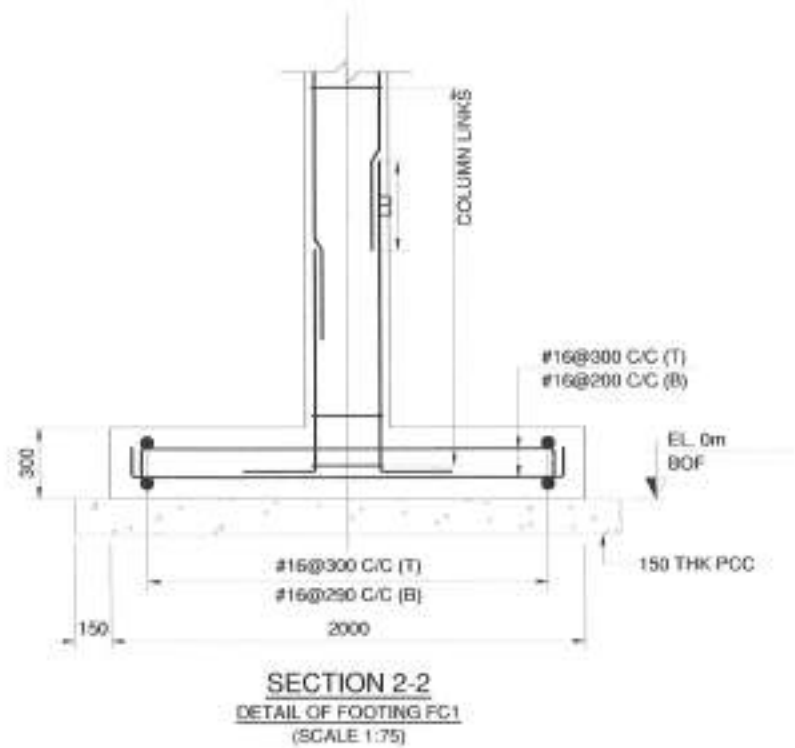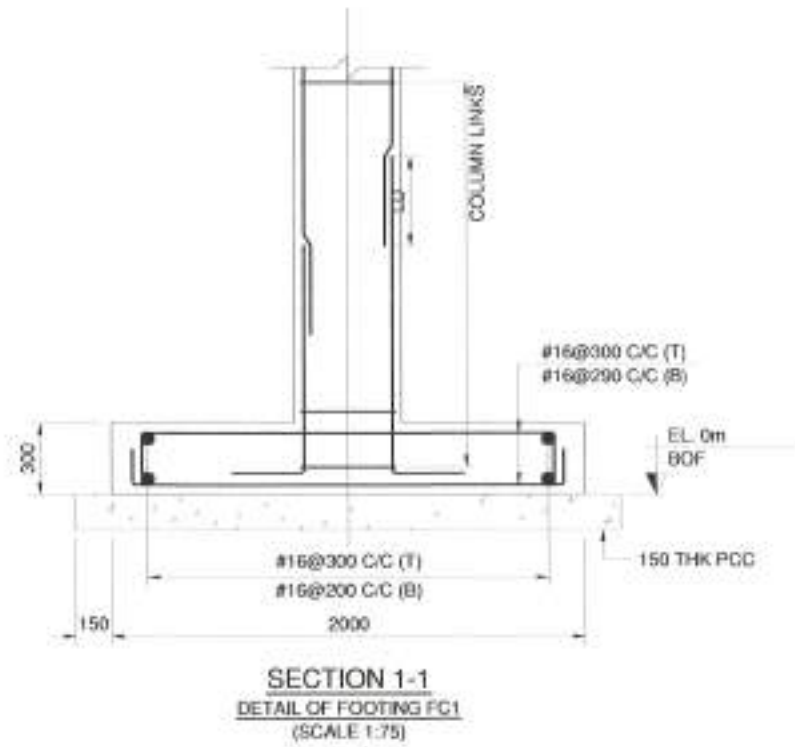

1 **DETAIL OF FOOTING**
S - 2 SCALE: 1:40 MTS.



Republic of the Philippines
DEPARTMENT OF PUBLIC WORKS AND HIGHWAYS
REGIONAL OFFICE NO. VIII
GOVERNMENT CENTER, SAKAL, PALO LEYTE

PROJECT TITLE:
CONSTRUCTION OF INNOVATION INCUBATION CENTER BUILDING
PALANPIN INSTITUTE OF TECHNOLOGY
LOCATION: BAY, CORDOBA, PALANPIN, LEYTE

SHEET CONTENTS:
DETAIL OF FOOTING

PREPARED:
ENGR. ELIZAR JEROME T. BACLEA-AN
STRUCTURAL ENGINEER
DATE:

SUBMITTED:
LUCAS R. BACSE
CHIEF ARCHITECT
DATE:

RECOMMENDED:
MA. MARGARITA C. JUNIA, D.E.
ASSISTANT REGIONAL DIRECTOR
DATE:

APPROVED:
EDGAR S. TABACON, JR.
REGIONAL ENGINEER
DATE:

CONCURRED:
DENNIS J. PILLAR, E.L.D.
LOCAL GOVERNMENT
DATE:


SET NO. 8
2 56
SHEET NO. 29
101

3.5 M	TO	3.5 M	C45-Fy14, COVER - 5MM	C45-Fy14, COVER - 5MM	C45-Fy14, COVER - 5MM	C45-Fy14, COVER - 5MM	C45-Fy14, COVER - 5MM	C45-Fy14, COVER - 5MM	C45-Fy14, COVER - 5MM	C45-Fy14, COVER - 5MM	
			1995 #12 @ 250	1995 #12 @ 250	1995 #12 @ 250	1995 #12 @ 250	1995 #12 @ 250	1995 #12 @ 250	1995 #12 @ 250	1995 #12 @ 250	
0.8 M	TO	3.5 M	C45-Fy14, COVER - 5MM	C45-Fy14, COVER - 5MM	C45-Fy14, COVER - 5MM	C45-Fy14, COVER - 5MM	C45-Fy14, COVER - 5MM	C45-Fy14, COVER - 5MM	C45-Fy14, COVER - 5MM	C45-Fy14, COVER - 5MM	
			1995 #12 @ 250	1995 #12 @ 250	1995 #12 @ 250	1995 #12 @ 250	1995 #12 @ 250	1995 #12 @ 250	1995 #12 @ 250	1995 #12 @ 250	
0.8 M	TO	0.8 M	C45-Fy14, COVER - 5MM	C45-Fy14, COVER - 5MM	C45-Fy14, COVER - 5MM	C45-Fy14, COVER - 5MM	C45-Fy14, COVER - 5MM	C45-Fy14, COVER - 5MM	C45-Fy14, COVER - 5MM	C45-Fy14, COVER - 5MM	
			1995 #12 @ 250	1995 #12 @ 250	1995 #12 @ 250	1995 #12 @ 250	1995 #12 @ 250	1995 #12 @ 250	1995 #12 @ 250	1995 #12 @ 250	
0.8 M	TO	0.8 M	C45-Fy14, COVER - 5MM	C45-Fy14, COVER - 5MM	C45-Fy14, COVER - 5MM	C45-Fy14, COVER - 5MM	C45-Fy14, COVER - 5MM	C45-Fy14, COVER - 5MM	C45-Fy14, COVER - 5MM	C45-Fy14, COVER - 5MM	
			1995 #12 @ 250	1995 #12 @ 250	1995 #12 @ 250	1995 #12 @ 250	1995 #12 @ 250	1995 #12 @ 250	1995 #12 @ 250	1995 #12 @ 250	
COLUMN MARKED			C1	C2, C3, C4, C57, C58	C19, C20	C25	C26, C46	C29	C47	C48	C56


COLUMN AND WALL SCHEDULE
SCALE 1:20

1
S - 3 **COLUMN SECTION DETAILS**
DRAWN NOT TO SCALE


	PROJECT TITLE:	SHEET CONTENTS:	PREPARED:	SUBMITTED:	RECOMMENDED:	APPROVED:	CONCURRED:	SET NO.	SHEET NO.
	CONSTRUCTION OF INNOVATION INCUBATION CENTER BUILDING - PALANGIN INSTITUTE OF TECHNOLOGY	COLUMN SECTION DETAILS	ENGR. ELIZABETH T. BACLEA-AN STRUCTURAL ENGINEER	LUCAS K. BACAL CHIEF ENGINEERING DESIGNER	MA. MARGARITA C. JUNA, D.M. ASSISTANT ENGINEERING DIRECTOR	EDGAR B. BACACON, CESO IV REGIONAL DIRECTOR	DEAN A. BACALAR, E.S.O. ADMINISTRATIVE OFFICER	3	30

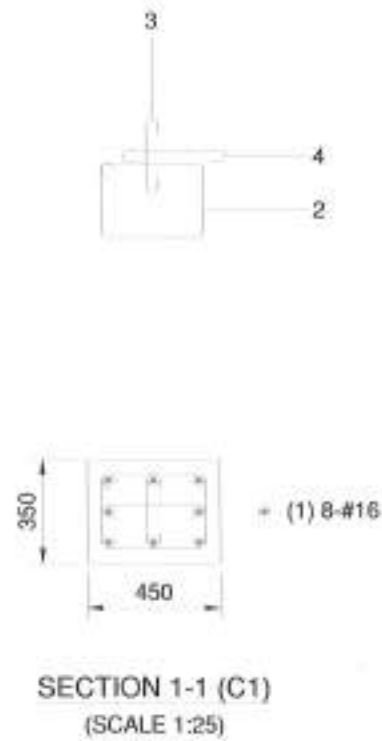

E1

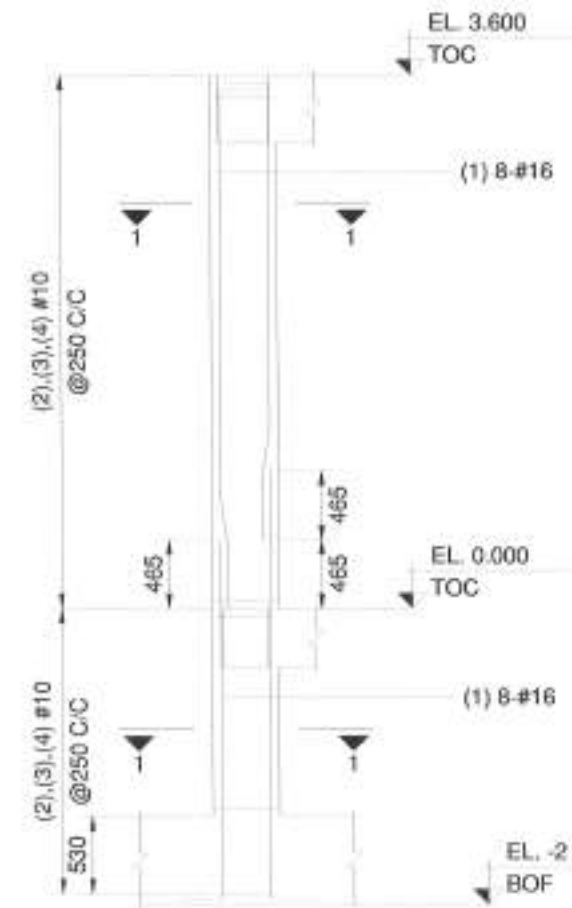

 Republic of the Philippines DEPARTMENT OF PUBLIC WORKS AND HIGHWAYS REGIONAL OFFICE NO. VIII GOVERNMENT CENTER, DAVAO PALO LUYTE	PROJECT TITLE: CONSTRUCTION OF INNOVATION INCUBATION CENTER BUILDING- PALOMPON INSTITUTE OF TECHNOLOGY LOCATION: STREET, DAVAO PALOMPON, DAVAO	SHEET CONTENTS: STRUCTURAL DETAIL OF COLUMNS	PREPARED: ENGR. ELIZABETH T. SACUBA-AN STRUCTURAL ENGINEER	SUBMITTED: LUCAS M. SANCIAL CHIEF ENGINEER	RECOMMENDED: MA. MARGARITA C. JUMA D.M. REGIONAL ENGINEER (STRUCTURE)	APPROVED: CESAR B. TABACON, CESO IV REGIONAL ENGINEER (STRUCTURE)	DATE: 10/10/2023	SHEET NO. 8 456	SHEET NO. 31 101
---	--	---	---	---	--	--	-------------------------	--------------------------------	---------------------------------

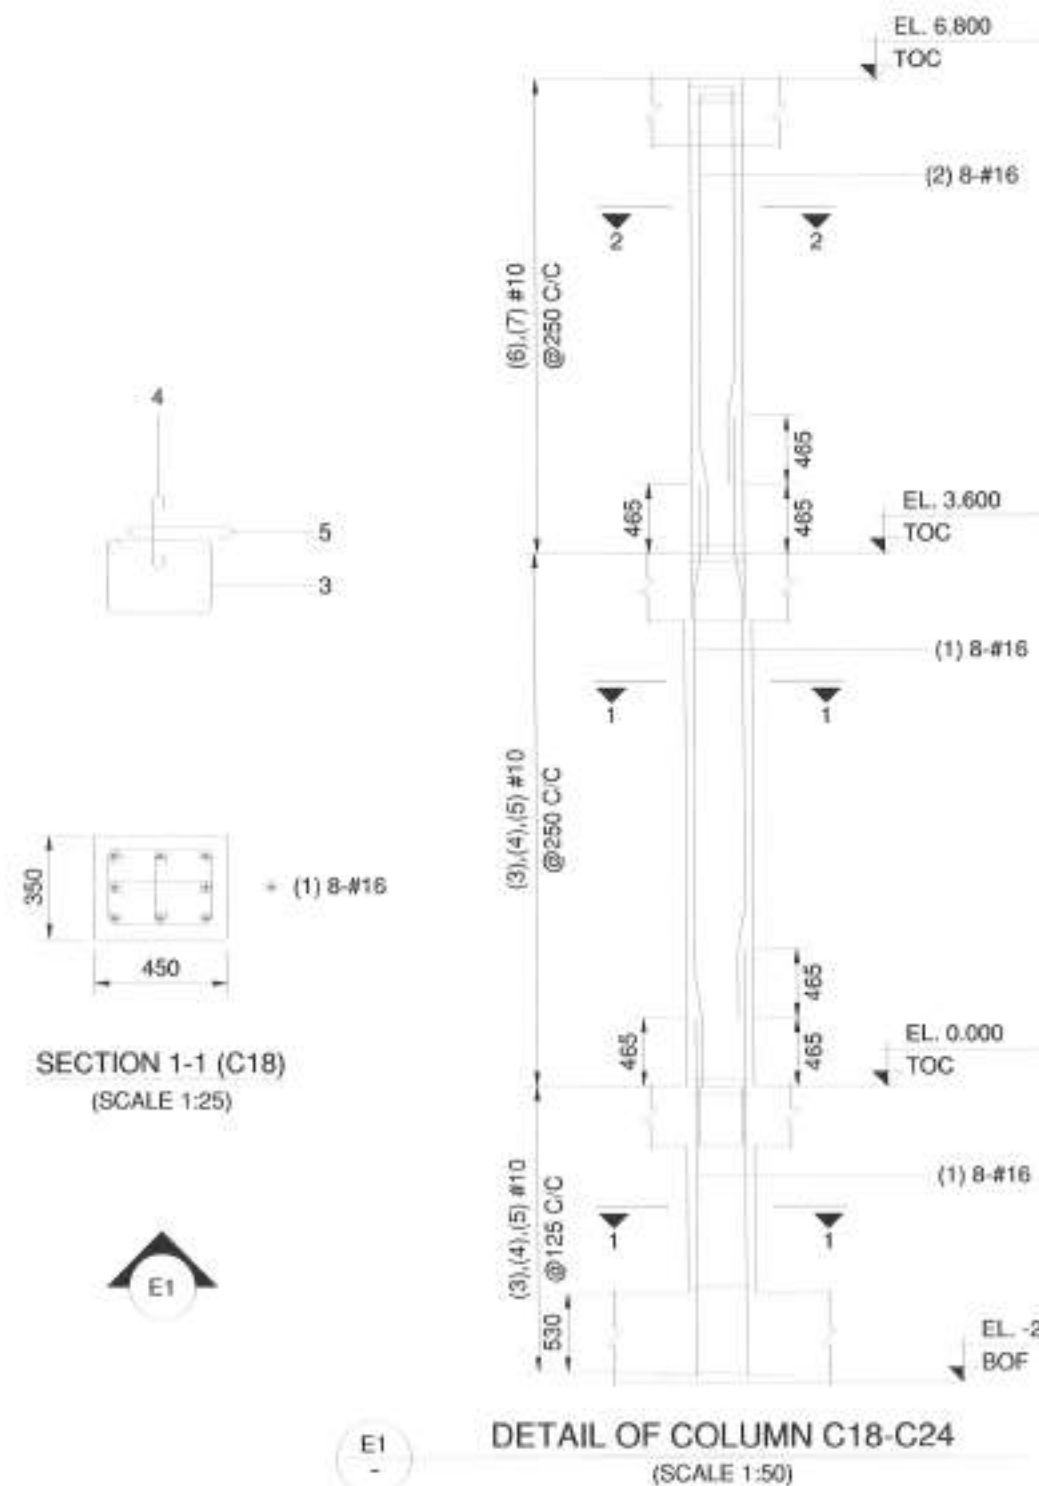

Republic of the Philippines
DEPARTMENT OF PUBLIC WORKS AND HIGHWAYS
REGIONAL OFFICE NO. VIII
GOVERNMENT CENTER, BANGAL, PALO CUYTE

PROJECT TITLE:	CONSTRUCTION OF INNOVATION INCUBATION CENTER BUILDING- PALOMPON INSTITUTE OF TECHNOLOGY
DESIGNER:	DR. EDGAR B. BARACON, CESO IV

SHEET CONTENTS:	STRUCTURAL DETAIL OF COLUMNS
PREPARED BY:	ENGR. ELIZABETH T. BACSA-AN STRUCTURAL ENGINEER


SUBMITTED BY:	LUCAS N. BACSA CIVIL ENGINEER
DATE:	2023

RECOMMENDED BY:	MA. MARICARITA C. DIAZ, O.M. ASSISTANT REGIONAL DIRECTOR
DATE:	2023


APPROVED BY:	EDGAR B. BARACON, CESO IV REGIONAL DIRECTOR
DATE:	2023

CONCURRED BY:	DENNIS A. DELA CRUZ, C.E.D. REGIONAL ENGINEER
DATE:	2023

SET NO.	32
SHEET NO.	101

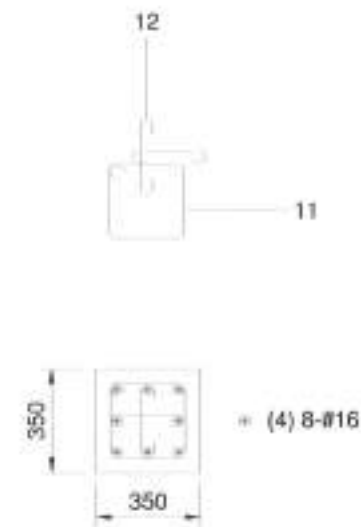


SECTION 3-3 (C25)
(SCALE 1:25)

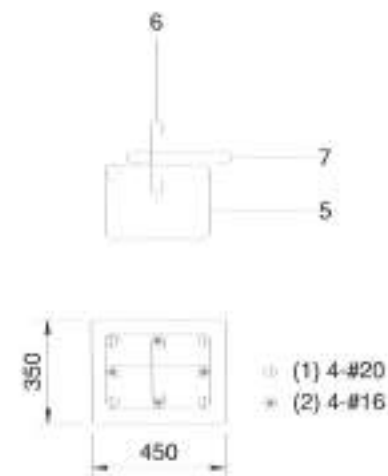

SECTION 1-1 (C25)
(SCALE 1:25)



E1

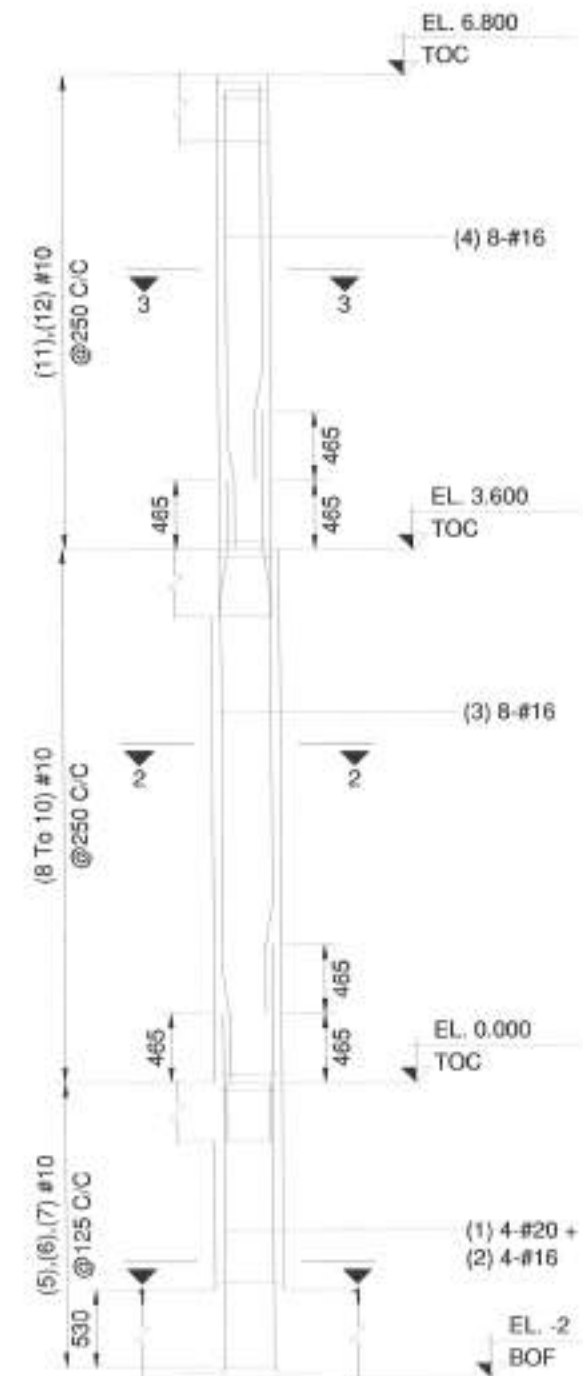

DETAIL OF COLUMN C25
(SCALE 1:50)



Republic of the Philippines
DEPARTMENT OF PUBLIC WORKS AND HIGHWAYS
REGIONAL OFFICE NO. VIII
GOVERNMENT CENTER, SARAL, PALO LUYTE

PROJECT TITLE:
CONSTRUCTION OF INNOVATION INCUBATION CENTER BUILDING-
PALOMPON INSTITUTE OF TECHNOLOGY

SHEET CONTENTS:
STRUCTURAL DETAIL OF COLUMNS

PREPARED:
ENGR. ELIZABETH T. BACALAN
STRUCTURAL ENGINEER

SUBMITTED:
LUCAS R. BACALAN
CHIEF ARCHITECT



RECOMMENDED:
MA. MARGARET C. JORDA, D.A.
REGIONAL REGIONAL DIRECTOR

APPROVED:
EDGAR S. TABACON, CESO IV
REGIONAL DIRECTOR

CONCURRED:
DENNIS A. DELA CRUZ, C.E.D.
UNIVERSITY PROFESSOR

SET NO.
8

SHEET NO.
33

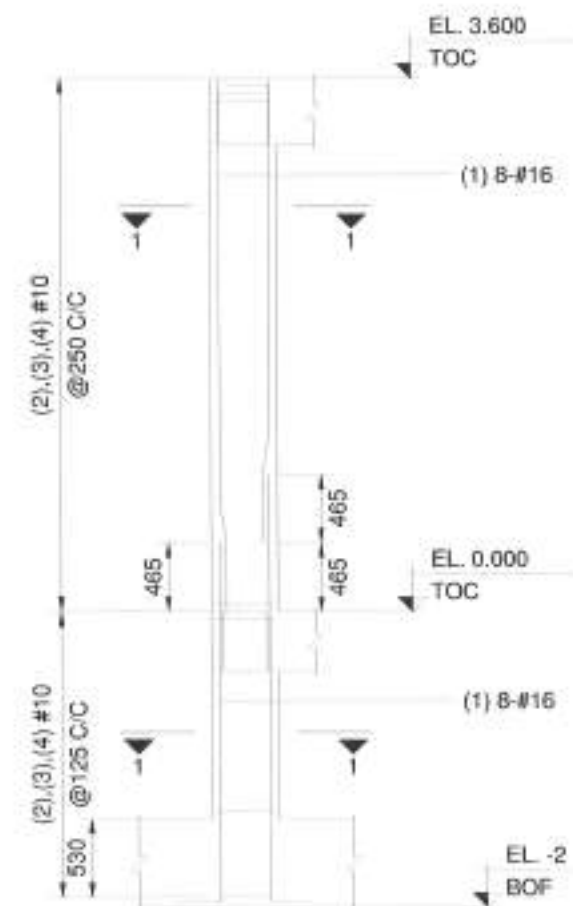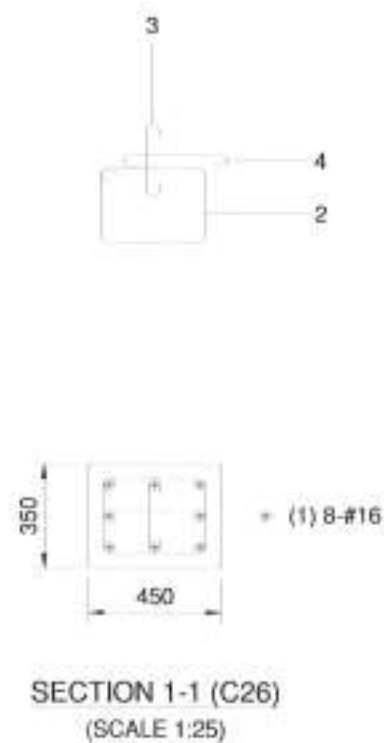

E1



Republic of the Philippines
DEPARTMENT OF PUBLIC WORKS AND HIGHWAYS
REGIONAL OFFICE NO. VIII
GOVERNMENT CENTER, DARR, PALO LITTE

PROJECT TITLE:
CONSTRUCTION OF INNOVATION INCUBATION CENTER BUILDING,
PALAMPON INSTITUTE OF TECHNOLOGY
LOCATION: BRP CUBAN E, PALAMPON CITY

SHEET CONTENTS:
STRUCTURAL DETAIL OF COLUMNS

PREPARED:
ENGR. ELIZABETH T. BACLEA-AN
STRUCTURAL ENGINEER
DATE: _____

SUBMITTED:
LUCAS N. BACAL
CHIEF-IDENTIFICATION DIVISION
DATE: _____

RECOMMENDED:
MA. MARGARET C. JURAN, D.M.
ASSISTANT REGIONAL DIRECTOR
DATE: _____

APPROVED:
EDGAR B. TABACON, CESO IV
REGIONAL DIRECTOR
DATE: _____

CONCURRED:
DENNIS A. ALAR, E.J.D.
UNIVERSITY PROJECT
DATE: _____

SET NO. 5
SHEET NO. 34
7 56 101