


25110084

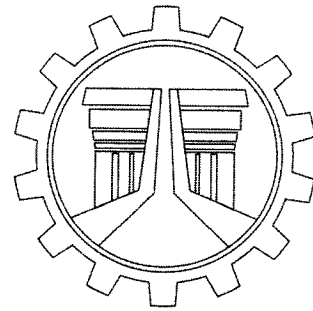

REPUBLIC OF THE PHILIPPINES
DEPARTMENT OF PUBLIC WORKS AND HIGHWAYS
REGIONAL OFFICE NO. VIII
TACLOBAN CITY DISTRICT ENGINEERING OFFICE
NEW BUS TERMINAL, BRGY. 91, ABUCAY, TACLOBAN CITY

C.Y. 2025 PROJECT
DETAILED ENGINEERING DESIGN PLAN FOR
REPAIR/MAINTENANCE OF DILG BUILDING BUREAU OF FIRE PROTECTION -
TACLOBAN CITY FIRE STATION
TACLOBAN CITY, LEYTE

SUBMITTED:



CHARLIE B. TAMPIL
CHIEF, MAINTENANCE SECTION
DATE: 07-03-2025

RECOMMENDED:

CHARLIE B. TAMPIL
OIC - OFFICE OF THE ASSISTANT DISTRICT ENGINEER
DATE: 07-03-2025

APPROVED:

RAY PINATE
OIC - OFFICE OF THE DISTRICT ENGINEER
DATE: 07-04-2025

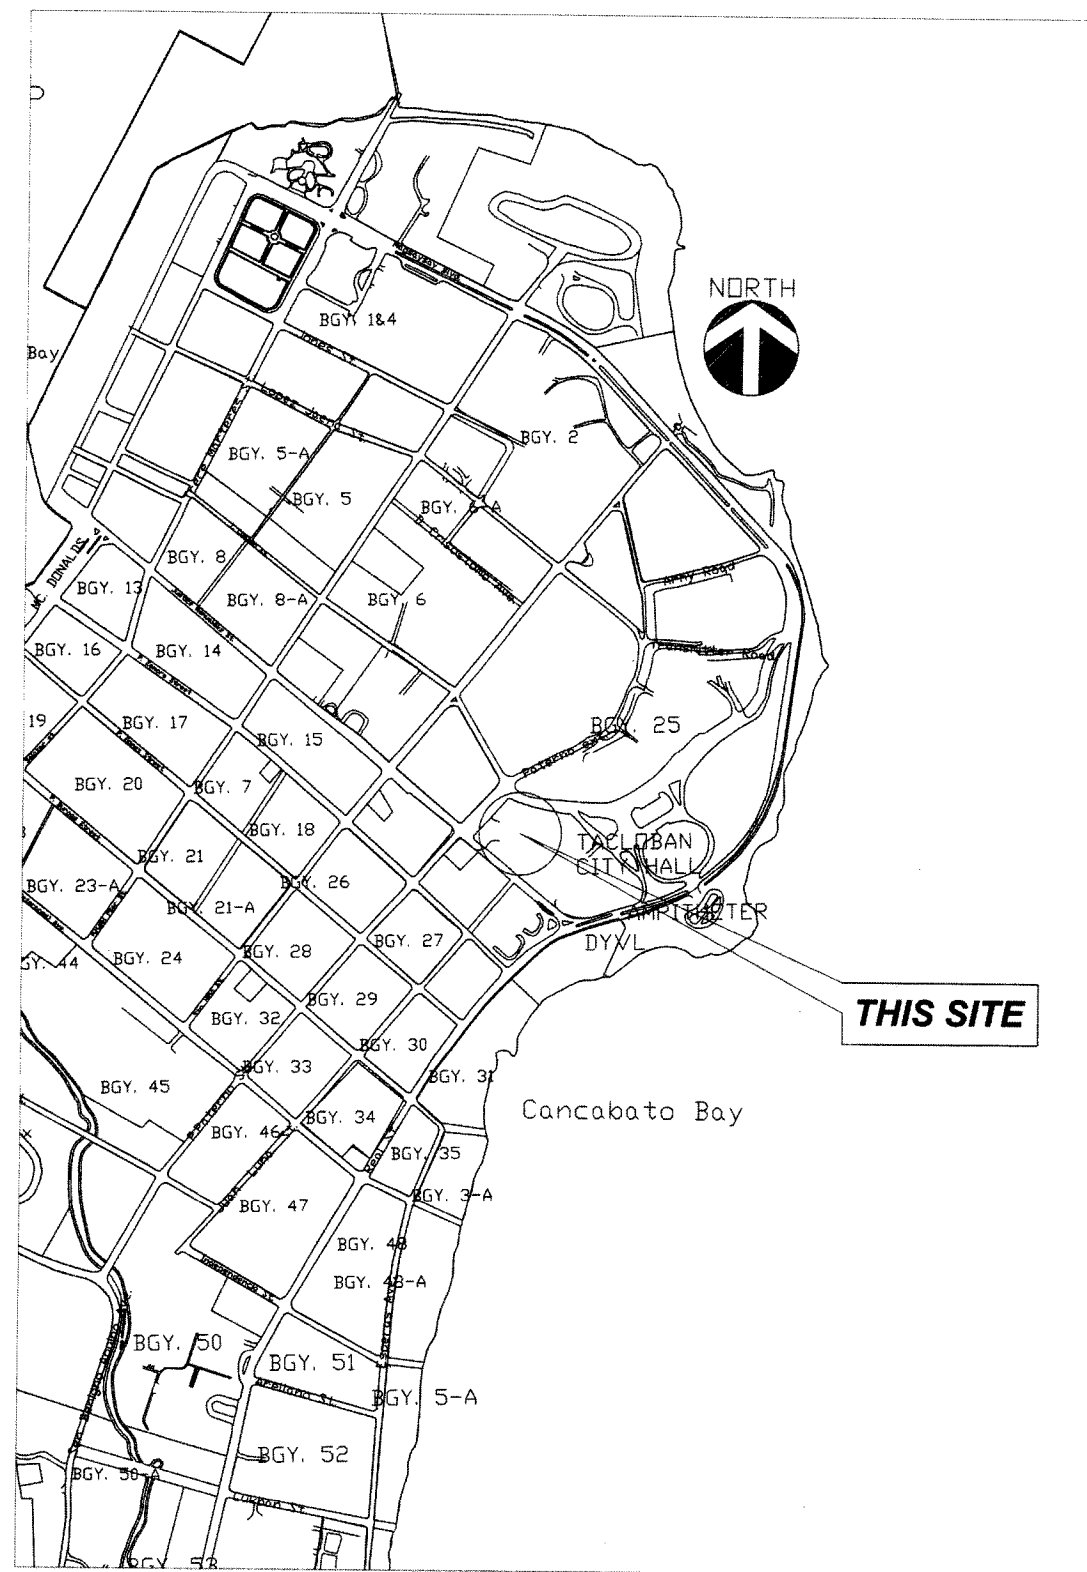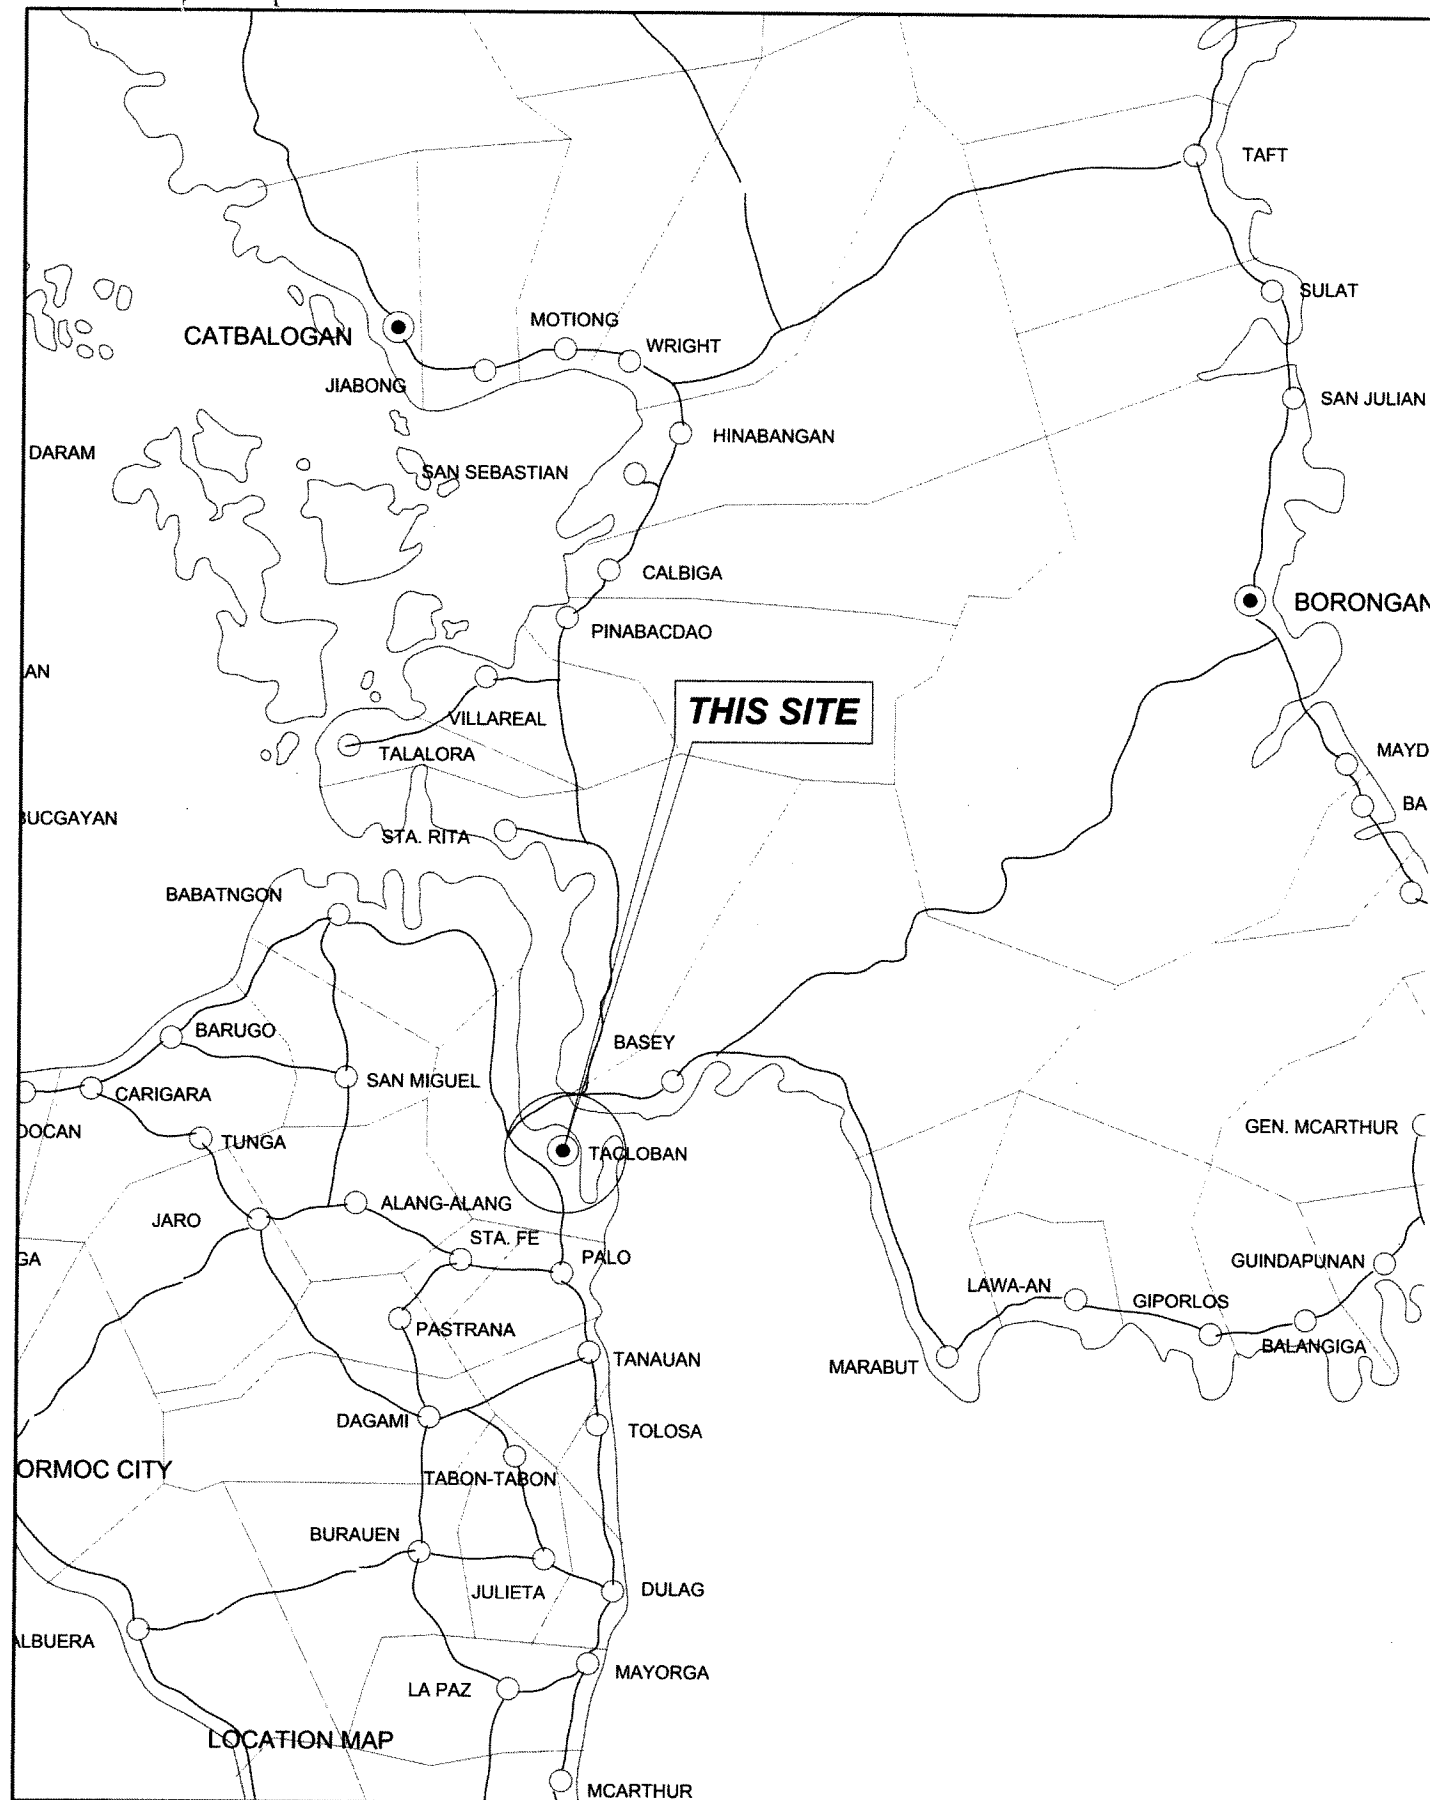

VICINITY MAP

REPUBLIC OF THE PHILIPPINES DEPARTMENT OF PUBLIC WORKS AND HIGHWAYS REGION VIII TACLOBAN CITY DISTRICT ENGINEERING OFFICE NEW BUS TERMINAL, BRGY. 91, ABUCAY, TACLOBAN CITY	PROJECT NAME AND LOCATION:	SHEET CONTENTS:	DRAFTED:	REVIEWED:	SUBMITTED:	RECOMMENDED:	APPROVED:	SET NO.	SHEET NO.
	REPAIR/MAINTENANCE OF DILG BUILDING BUREAU OF FIRE PROTECTION - TACLOBAN CITY FIRE STATION, TACLOBAN CITY, LEYTE	- VICINITY MAP - LOCATION MAP	DRAFTED: <i>Marianne Paulette D. Plimaco</i> MARIANNE PAULETTE D. PLIMACO ENGINEER I, P.E. PREPARED: <i>Marianne Paulette D. Plimaco</i> MARIANNE PAULETTE D. PLIMACO ENGINEER I, P.E.	REVIEWED: <i>Mary Grace L. Gaddi</i> MARY GRACE L. GADDI ENGINEER II DATE: 07-03-2025	SUBMITTED: <i>Charles S. Tampil</i> CHARLES S. TAMPIL CHIEF, MAINTENANCE SECTION DATE: 07-04-2025	RECOMMENDED: <i>Charles S. Tampil</i> CHARLES S. TAMPIL OFFICE OF THE ASST. DISTRICT ENGINEER/OIC - OFFICE OF THE DISTRICT ENGINEER DATE: 07-04-2025	APPROVED: <i>Ray P. Nave</i> RAY P. NAVE OFFICE OF THE DISTRICT ENGINEER DATE: 07-04-2025		


INDEX OF DRAWINGS

SHEET NO. 1	TITLE PAGE
SHEET NO. 2	LOCATION MAP
	VICINITY MAP
SHEET NO. 3	INDEX OF SHEETS
	SUMMARY OF QUANTITIES
SHEET NO. 4	GROUND FLOOR PLAN
	SECOND FLOOR PLAN
SHEET NO. 5	ROOF PLAN
SHEET NO. 6	GROUND FLOOR REFLECTED CEILING PLAN
	SECOND FLOOR REFLECTED CEILING PLAN
SHEET NO. 7	GROUND FLOOR LIGHTING LAYOUT
	SECOND FLOOR LIGHTING LAYOUT
SHEET NO. 8	FRONT ELEVATION PLAN
	REAR ELEVATION PLAN
	RIGHT SIDE ELEVATION PLAN
	LEFT SIDE ELEVATION PLAN
SHEET NO. 9	COA BILLBOARD
SHEET NO. 10	STANDARD DPWH PROJECT BILLBOARD


SUMMARY OF QUANTITIES

ITEM NO.	DESCRIPTION	UNIT	QUANTITY	REMARKS
B.3 (1)	PERMITS AND CLEARANCES	L.S.	1.00	
B.5 (1)	PROJECT BILLBOARD / SIGNBOARD	EA.	1.00	
B.7(1)	OCCUPATIONAL SAFETY AND HEALTH PROGRAM	L.S.	1.00	
B.9 (1)	MOBILIZATION / DEMOBILIZATION	L.S.	1.00	
B.24 (1)	GENERAL SCAFFOLDING AND SHORING AND NETTING	L.S.	1.00	
801(1)	REMOVAL OF STRUCTURES AND OBSTRUCTION	L.S.	1.00	
1018(2)	UNGLAZED TILES	SQ.M.	76.17	
1027(1)	CEMENT PLASTER FINISH	SQ.M.	26.46	
1007(1)b	ALUMINUM GLASS DOOR (SWING TYPE)	L.S.	10.88	
1032(1)a	PAINTING WORKS (MASONRY / CONCRETE)	SQ.M.	745.73	
1032(1)c	PAINTING WORKS (STEEL)	L.S.	194.47	
1014(1)a2	PREPAINTED METAL SHEETS (ABOVE 0.427MM CORRUGATED TYPE , LONG TYPE	SQ.M.	231.53	
1103(1)	LIGHTING FIXTURES AND LAMPS	L.S.	1.00	
1200(13)a	AIR CONDITIONING SYSTEM (PACKAGE /SPLIT TYPE)	L.S.	1.00	


	REPUBLIC OF THE PHILIPPINES DEPARTMENT OF PUBLIC WORKS AND HIGHWAYS REGION VIII TACLOBAN CITY DISTRICT ENGINEERING OFFICE NEW BUS TERMINAL, BRGY. 91, ABUCAY, TACLOBAN CITY	PROJECT NAME AND LOCATION: REPAIR/MAINTENANCE OF DILG BUILDING BUREAU OF FIRE PROTECTION - TACLOBAN CITY FIRE STATION, TACLOBAN CITY, LEYTE	SHEET CONTENTS: • INDEX OF SHEETS • SUMMARY OF QUANTITIES	DRAFTED: MARIANNE PAULETTE D. PLIMACO ENGINEER - I.O. DATE: 07-07-2025	REVIEWED: MARY GRACE L. GADDI ENGINEER II DATE: 07-07-2025	SUBMITTED: CHARLIE B. TAMPIL CHIEF MAINTENANCE SECTION DATE: 07-07-2025	RECOMMENDED: CHARLIE B. TAMPIL OFFICE OF THE ASST. DISTRICT ENGINEER/OIC DATE: 07-07-2025	APPROVED: RAY P. [Signature] OFFICE OF THE DISTRICT ENGINEER DATE: 07-04-2025	SET NO. 	SHEET NO. 

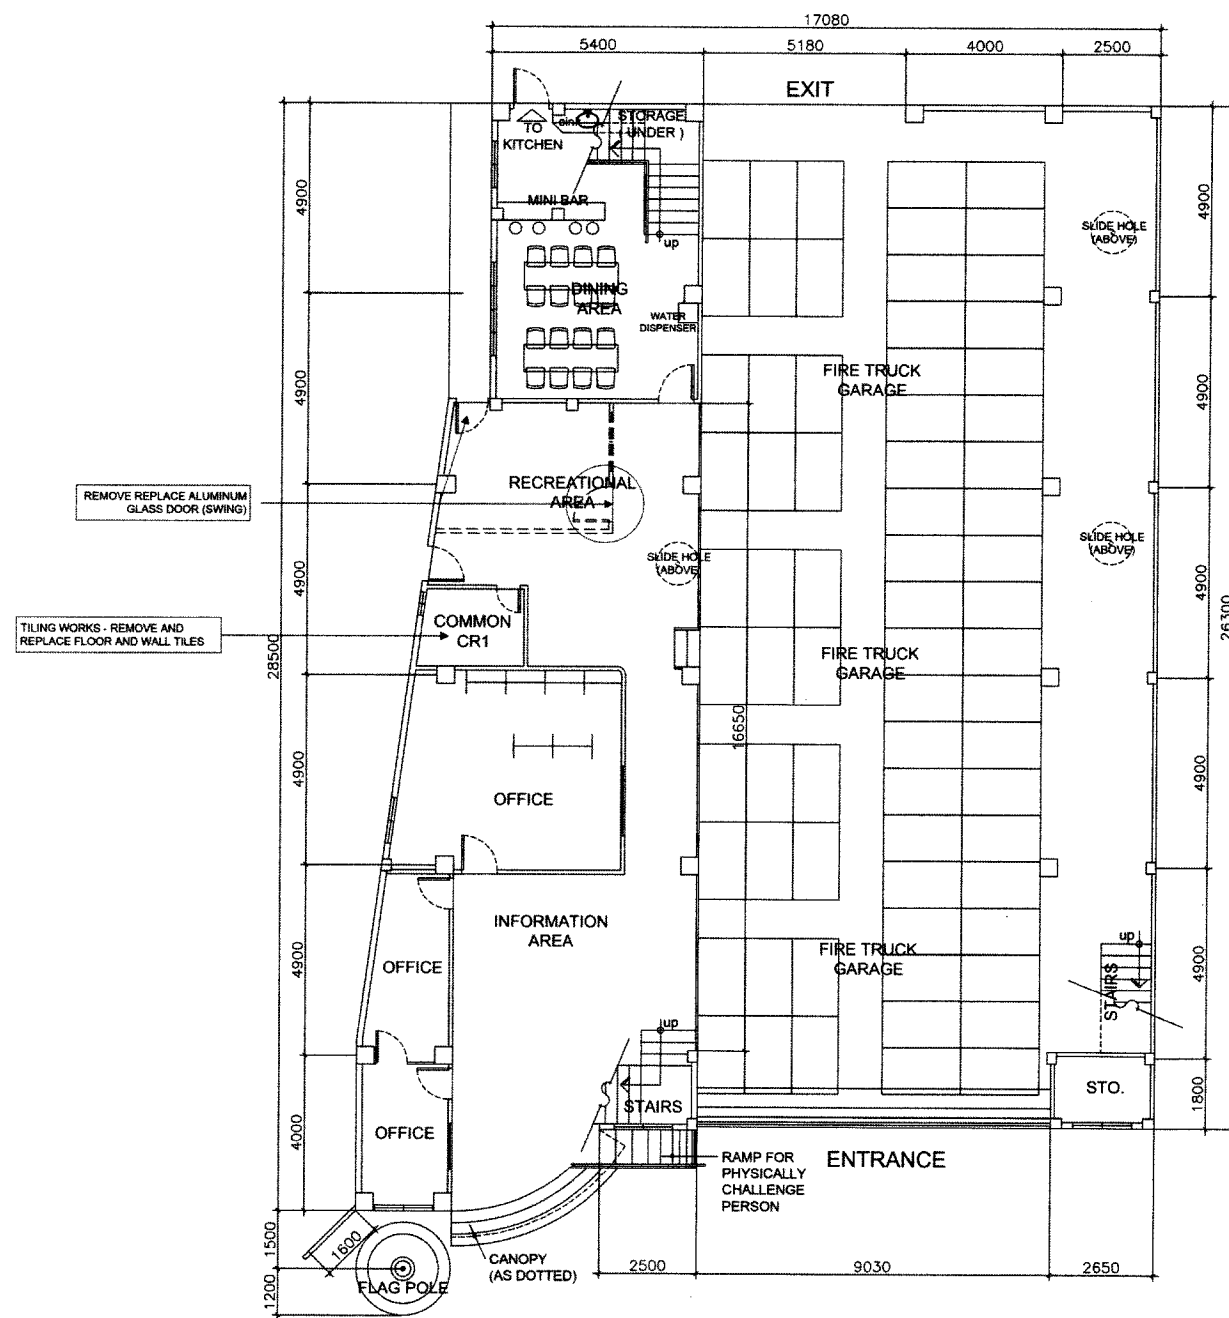

A
1 **GROUND FLOOR PLAN**
SCALE : 1:100 MTS.

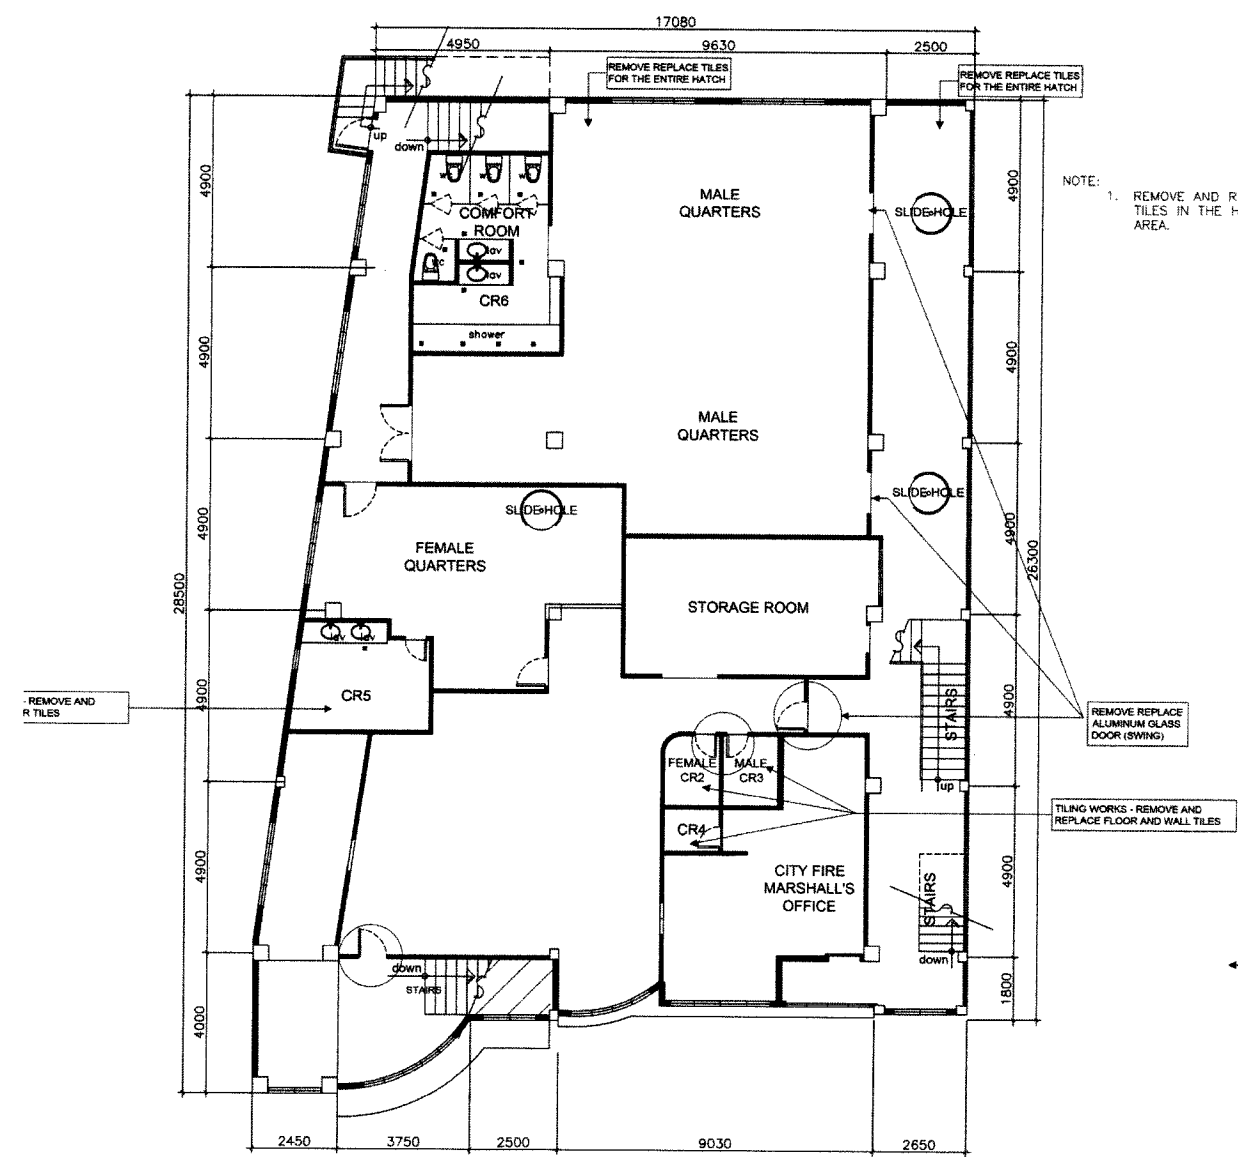

A
2 **SECOND FLOOR PLAN**
SCALE : 1:100 MTS.

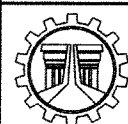

REPUBLIC OF THE PHILIPPINES
DEPARTMENT OF PUBLIC WORKS AND HIGHWAYS
REGION VIII
**TACLOBAN CITY DISTRICT
ENGINEERING OFFICE**
NEW BUS TERMINAL, BRGY. 91, ABUCAY, TACLOBAN CITY

PROJECT NAME AND LOCATION:

REPAIR/MAINTENANCE OF DILG BUILDING BUREAU OF
FIRE PROTECTION - TACLOBAN CITY FIRE STATION,
TACLOBAN CITY, LEYTE

SHEET CONTENTS:

- GROUND FLOOR PLAN
- SECOND FLOOR PLAN

DRAFTED:
Marianne Paullette D. Plimaco
MARIANNE PAULLETTE D. PLIMACO
ENGINEER I - JO
PREPARED:
Marianne Paullette D. Plimaco
MARIANNE PAULLETTE D. PLIMACO
ENGINEER I - JO


REVIEWED:
Mary Grace L. Gaddi
MARY GRACE L. GADDI
ENGINEER II
DATE: 07-07-2023

SUBMITTED:
Charlie B. Tampil
CHARLIE B. TAMPIL
CHIEF, MAINTENANCE SECTION
DATE: 07-07-2023


RECOMMENDED:
Charlie B. Tampil
CHARLIE B. TAMPIL
OFFICE OF THE ASST. DISTRICT ENGINEER/OIC - OFFICE OF THE DISTRICT ENGINEER
DATE: 07-07-2023

APPROVED:
Ray A. Tate
RAY A. TATE
OFFICE OF THE DISTRICT ENGINEER
DATE: 07-07-2023

SET NO. SHEET NO.
4 10

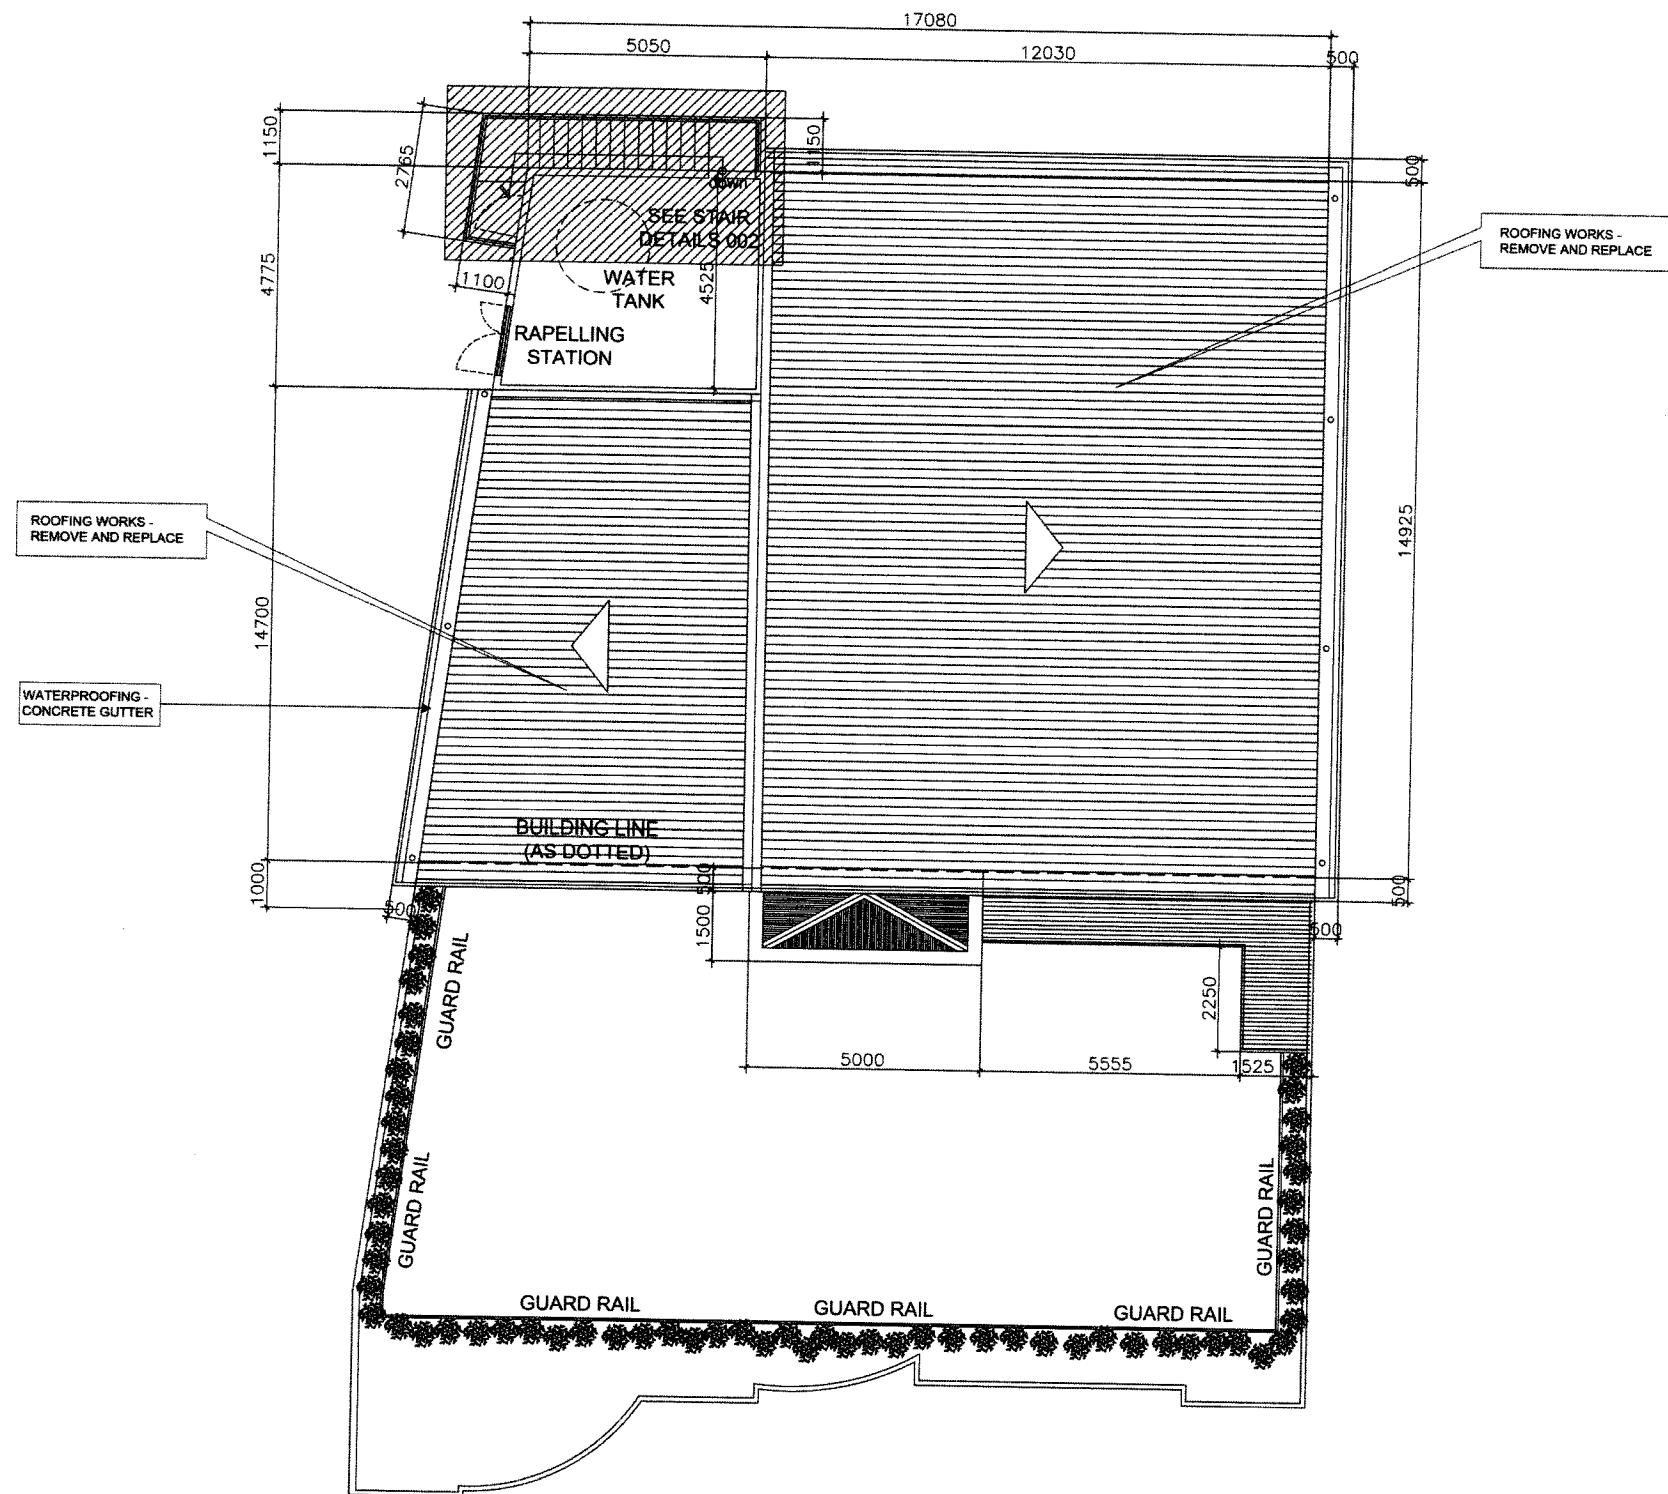

A
3 **ROOF PLAN**
SCALE 1:100 MTS.

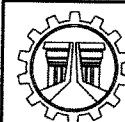

REPUBLIC OF THE PHILIPPINES
DEPARTMENT OF PUBLIC WORKS AND HIGHWAYS
REGION VIII
**TACLOBAN CITY DISTRICT
ENGINEERING OFFICE**
NEW BUS TERMINAL, BRGY. 91, ABUCAY, TACLOBAN CITY

PROJECT NAME AND LOCATION:

REPAIR/MAINTENANCE OF DILG BUILDING BUREAU OF
FIRE PROTECTION - TACLOBAN CITY FIRE STATION,
TACLOBAN CITY, LEYTE

SHEET CONTENTS:

- GROUND FLOOR REFLECTED CEILING PLAN
- SECOND FLOOR REFLECTED CEILING PLAN

DRAFTED:

MARIANNE PAULETTE D. PLIMACO
ENGINEER - I.O.

PREPARED:
MARIANNE PAULETTE D. PLIMACO
ENGINEER - I.O.

REVIEWED:

MARY GRACE L. GADDI
ENGINEER II
DATE: 07-09-2023

SUBMITTED:

CHARLIE B. TAMPIL
CHIEF, MAINTENANCE SECTION
DATE: 07-09-2023

RECOMMENDED:

CHARLIE B. TAMPIL
OFFICE OF THE ASST. DISTRICT ENGINEER - OIC - OFFICE OF THE DISTRICT ENGINEER
DATE: 07-09-2023

APPROVED:


RAY MATE
DATE: 07-09-2023

SET NO.


5

SHEET NO.

10

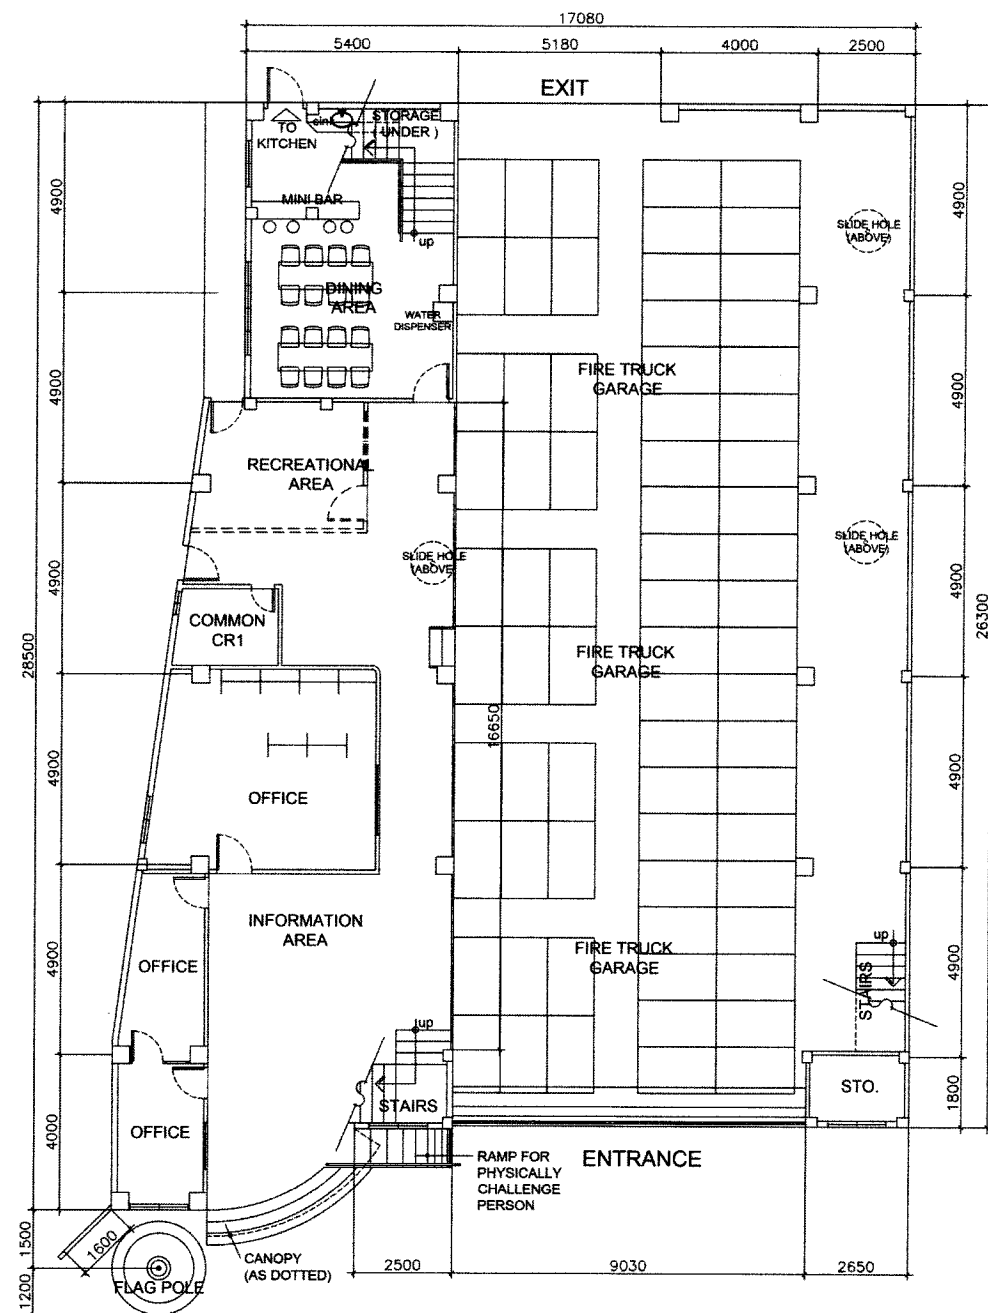

A4 GROUND FLOOR REFLECTED CEILING PLAN
SCALE 1:100 MTS.

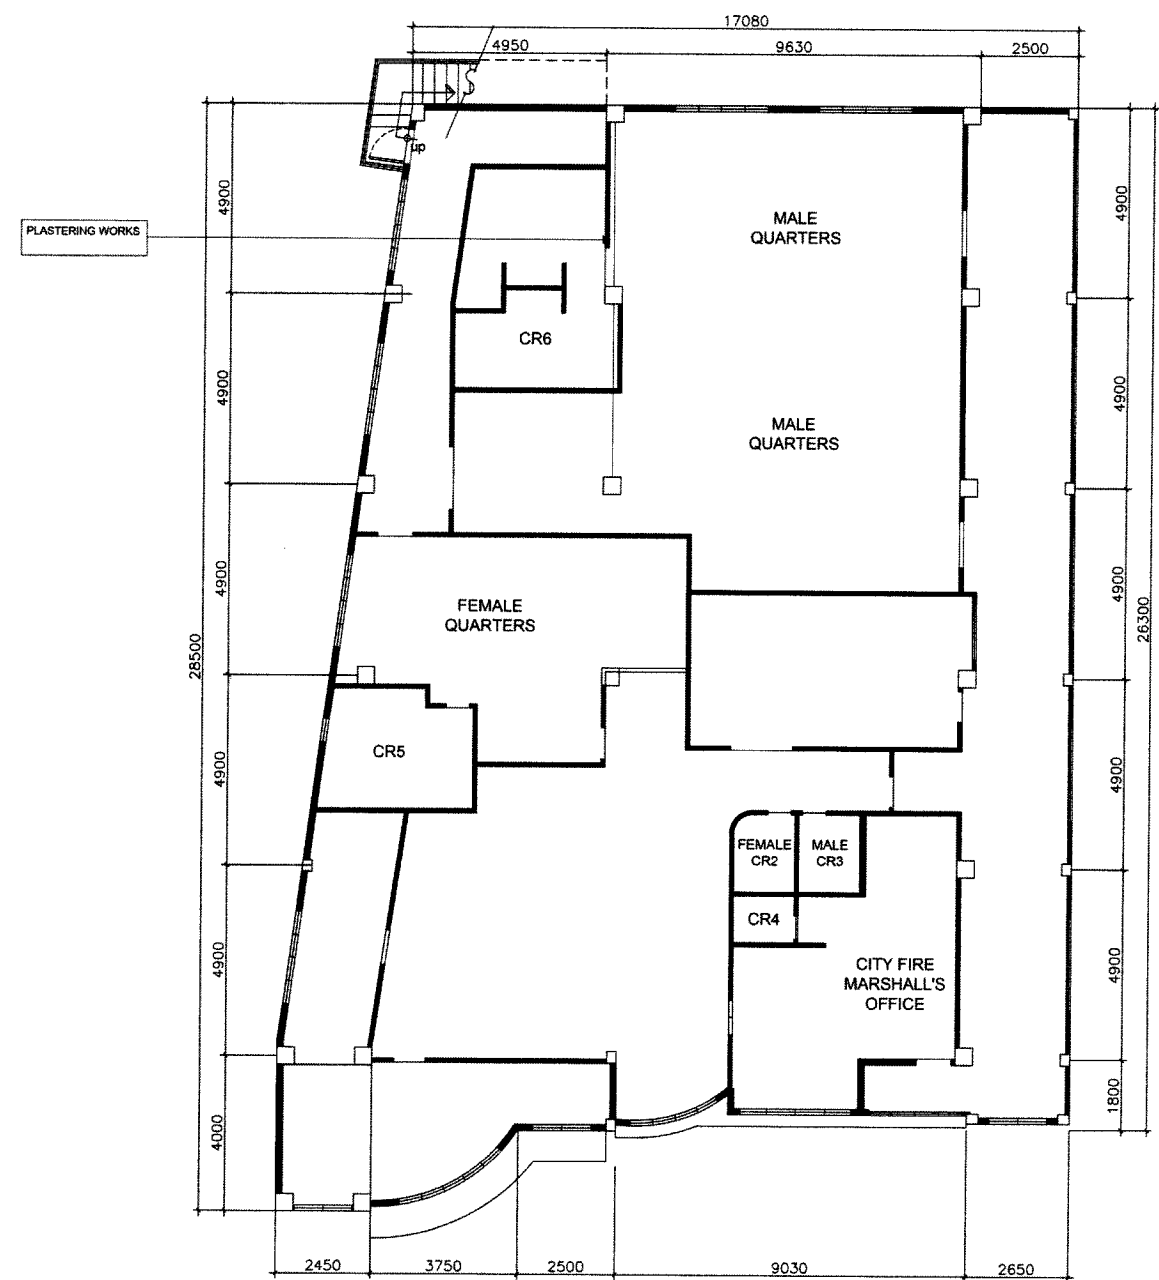

A5 SECOND FLOOR REFLECTED CEILING PLAN
SCALE 1:100 MTS.



REPUBLIC OF THE PHILIPPINES
DEPARTMENT OF PUBLIC WORKS AND HIGHWAYS
REGION VII
TACLOBAN CITY DISTRICT
ENGINEERING OFFICE
NEW BUS TERMINAL, BRGY. 91, ABUCAY, TACLOBAN CITY

PROJECT NAME AND LOCATION:
REPAIR/MAINTENANCE OF DILG BUILDING BUREAU OF
FIRE PROTECTION - TACLOBAN CITY FIRE STATION,
TACLOBAN CITY, LEYTE

SHEET CONTENTS:
• GROUND FLOOR REFLECTED CEILING PLAN
• SECOND FLOOR REFLECTED CEILING PLAN

DRAFTED:
MARIANNE CAULETTE D. PLIMACO
ENGINEER I - I.O.
PREPARED:
MARIANNE CAULETTE D. PLIMACO
ENGINEER I - I.O.


REVIEWED:
MARY GRACE L. GADDI
ENGINEER II
DATE: 07-09-2023

SUBMITTED:
CHARLIE B. TAMPIL
CHIEF, MAINTENANCE SECTION
DATE: 02-09-2023


RECOMMENDED:
CHARLIE B. TAMPIL
OFFICE OF THE ASST. DISTRICT ENGINEER - OIC
DATE: 07-09-2023

APPROVED:
RAYMUNTE
OFFICE OF THE DISTRICT ENGINEER
DATE: 07-09-2023


SET NO. SHEET NO.
6 10

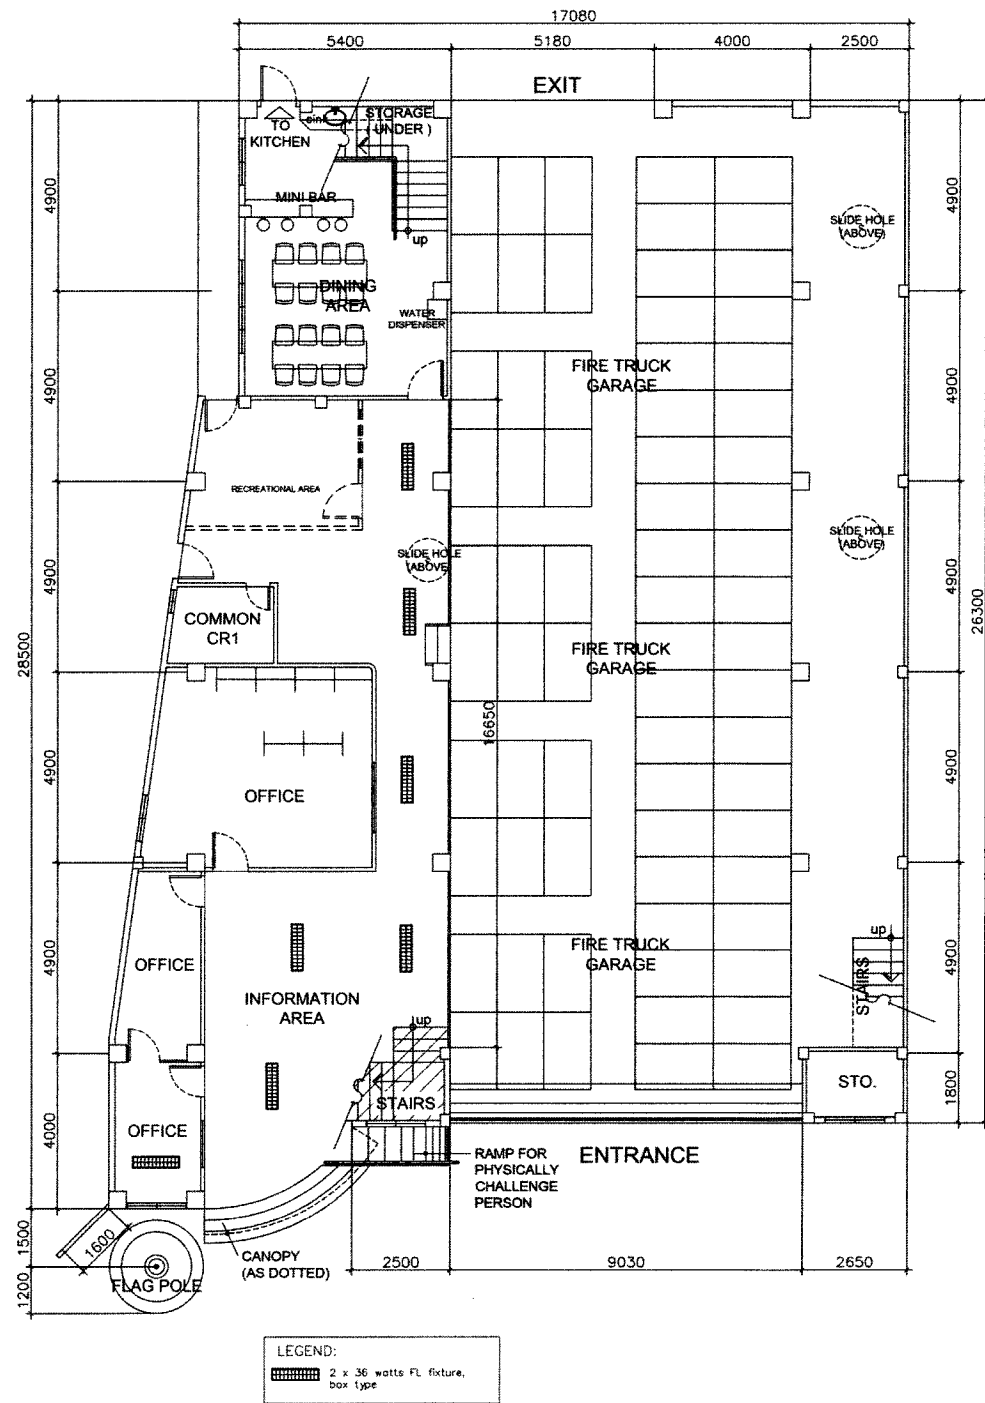


A **GROUND FLOOR LIGHTING LAYOUT**
6 SCALE 1:100 MTS.

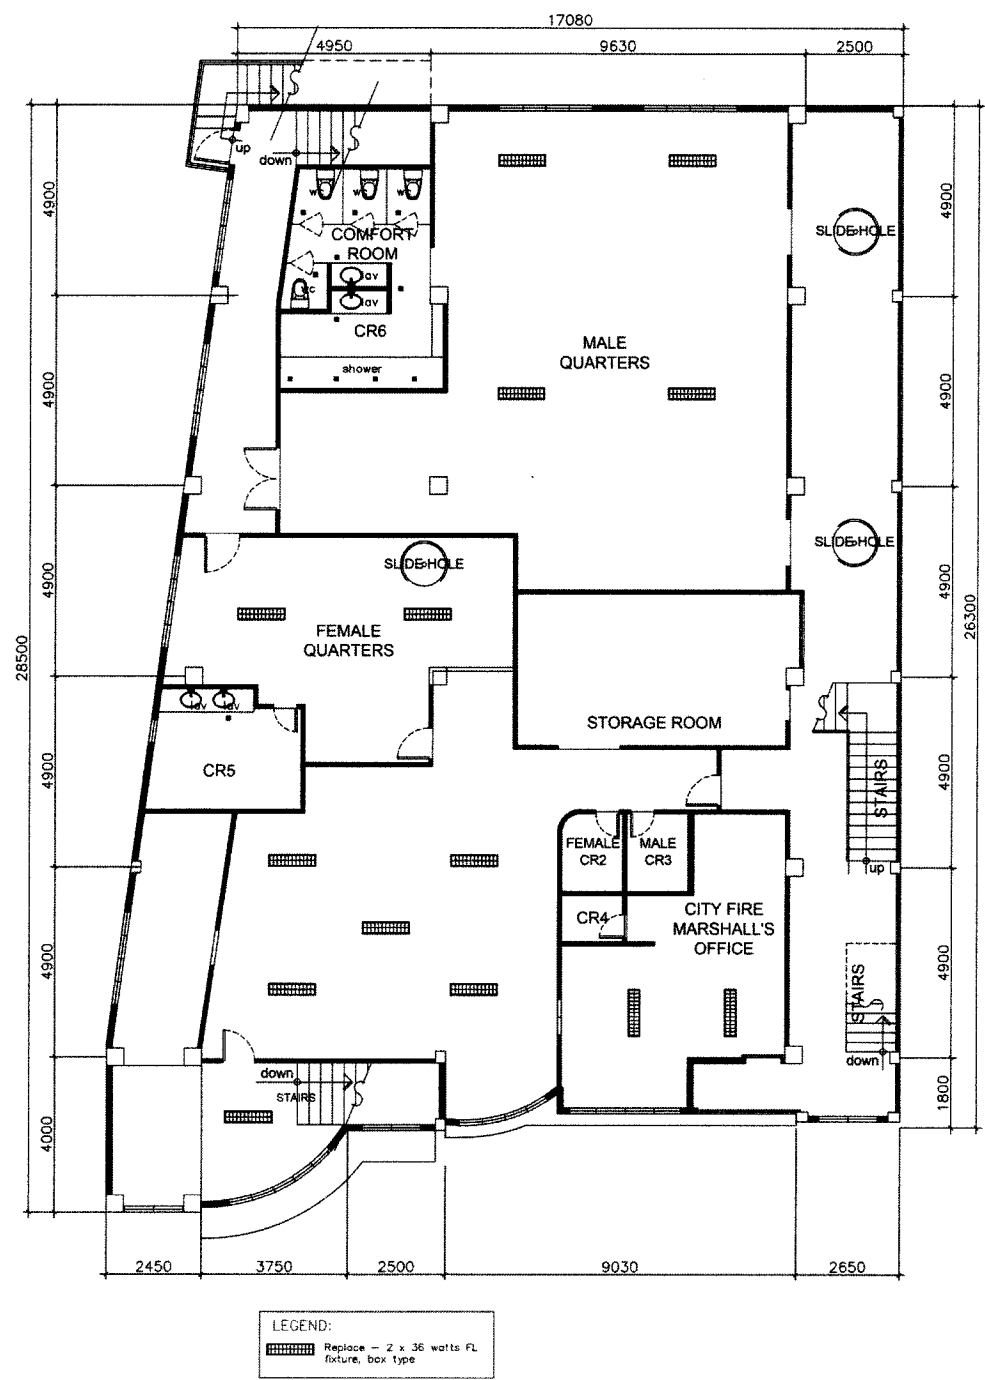


A **SECOND FLOOR LIGHTING LAYOUT**
7 SCALE 1:100 MTS.

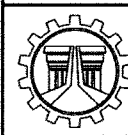
 REPUBLIC OF THE PHILIPPINES DEPARTMENT OF PUBLIC WORKS AND HIGHWAYS REGION VIII TACLOBAN CITY DISTRICT ENGINEERING OFFICE NEW BUS TERMINAL, BRGY. 91, ABUCAY, TACLOBAN CITY	PROJECT NAME AND LOCATION: REPAIR/MAINTENANCE OF DILG BUILDING BUREAU OF FIRE PROTECTION - TACLOBAN CITY FIRE STATION, TACLOBAN CITY, LEYTE	SHEET CONTENTS: • GROUND FLOOR LIGHTING LAYOUT • SECOND FLOOR LIGHTING LAYOUT	DRAFTED: <i>Marianne Paulete D. Plimaco</i> MARIANNE PAULETE D. PLIMACO ENGINEER I, J.O. PREPARED: <i>Marianne Paulete D. Plimaco</i> MARIANNE PAULETE D. PLIMACO ENGINEER I, J.O.	REVIEWED: <i>Mary Grace L. Gaddi</i> MARY GRACE L. GADDI ENGINEER II DATE: 07-07-2025	SUBMITTED: <i>Charlie B. Tampil</i> CHARLIE B. TAMPIL CHIEF MAINTENANCE SECTION DATE: 07-07-2025	RECOMMENDED: <i>Charlie B. Tampil</i> CHARLIE B. TAMPIL OFFICE OF THE ASST. DISTRICT ENGINEER - OIC - OFFICE OF THE DISTRICT ENGINEER DATE: 07-07-2025	APPROVED: <i>Raymundo</i> RAYMUNDO OFFICE OF THE DISTRICT ENGINEER DATE: 07-07-2025	SET NO. SHEET NO. 7 10
--	---	--	--	--	---	---	--	---

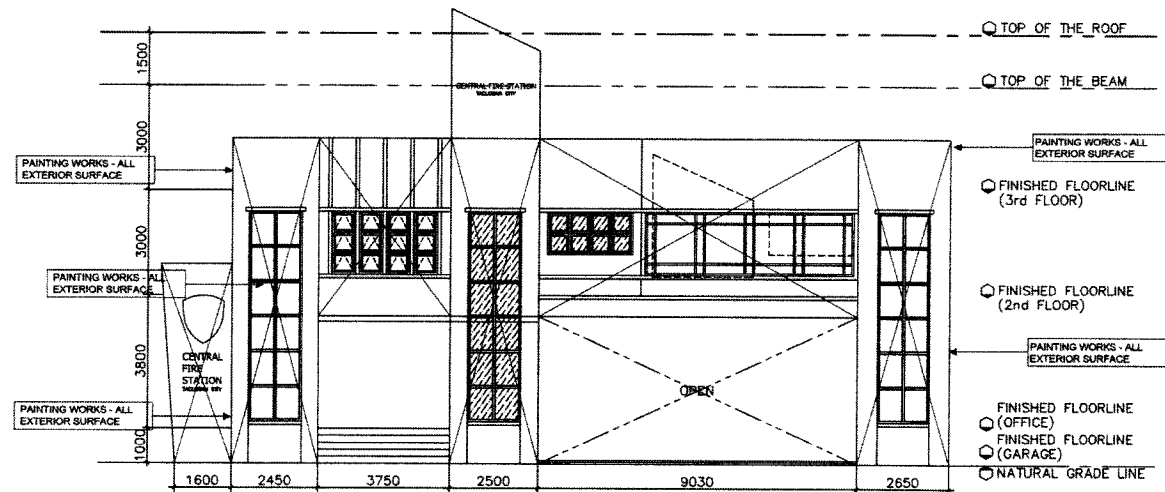


A FRONT ELEVATION PLAN
8 SCALE 1:100 MTS.

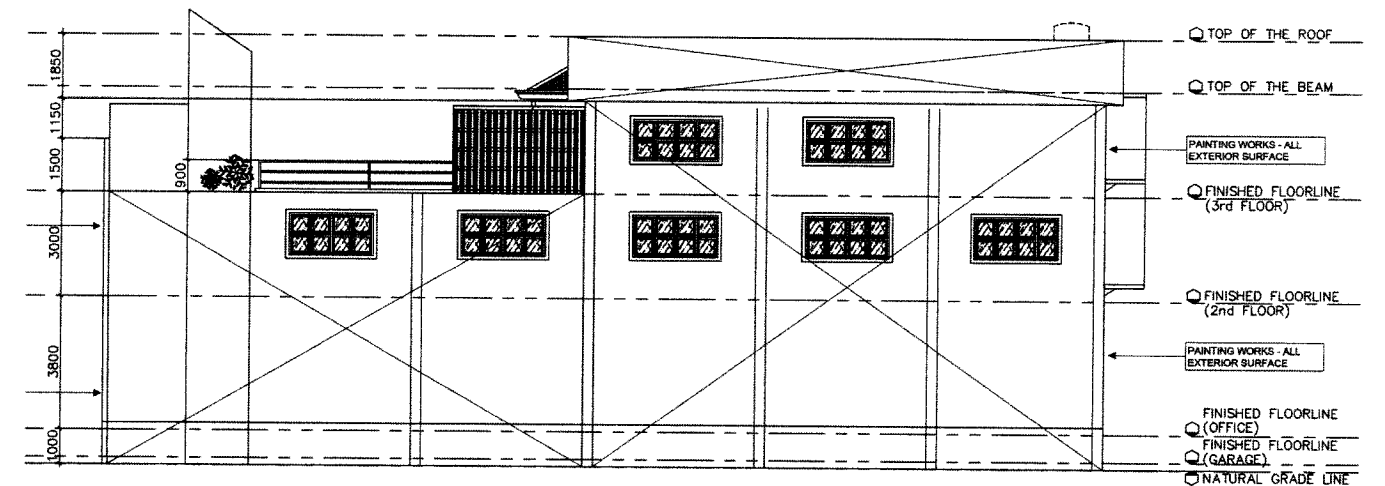


A RIGHT SIDE ELEVATION PLAN
10 SCALE 1:100 MTS.

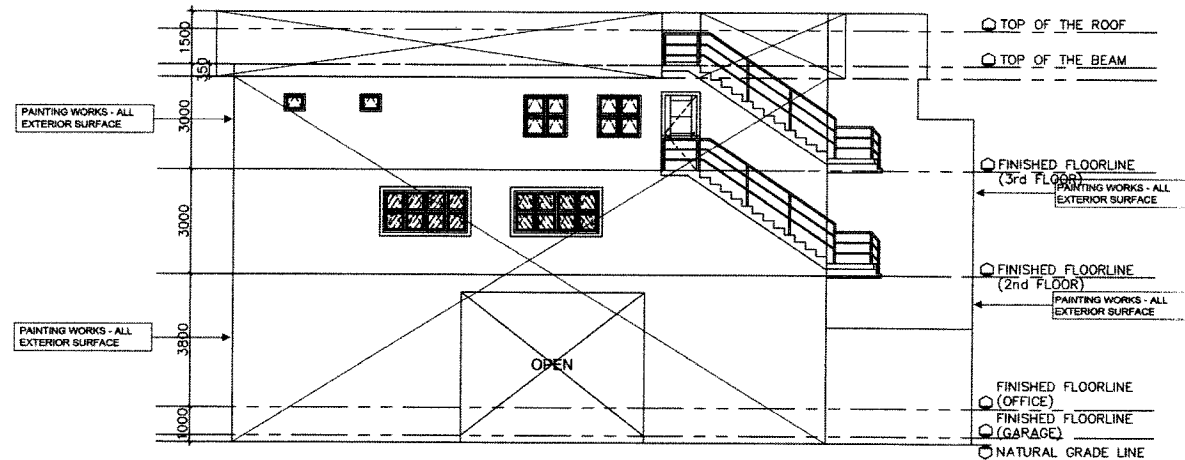

A REAR ELEVATION PLAN
9 SCALE 1:100 MTS.

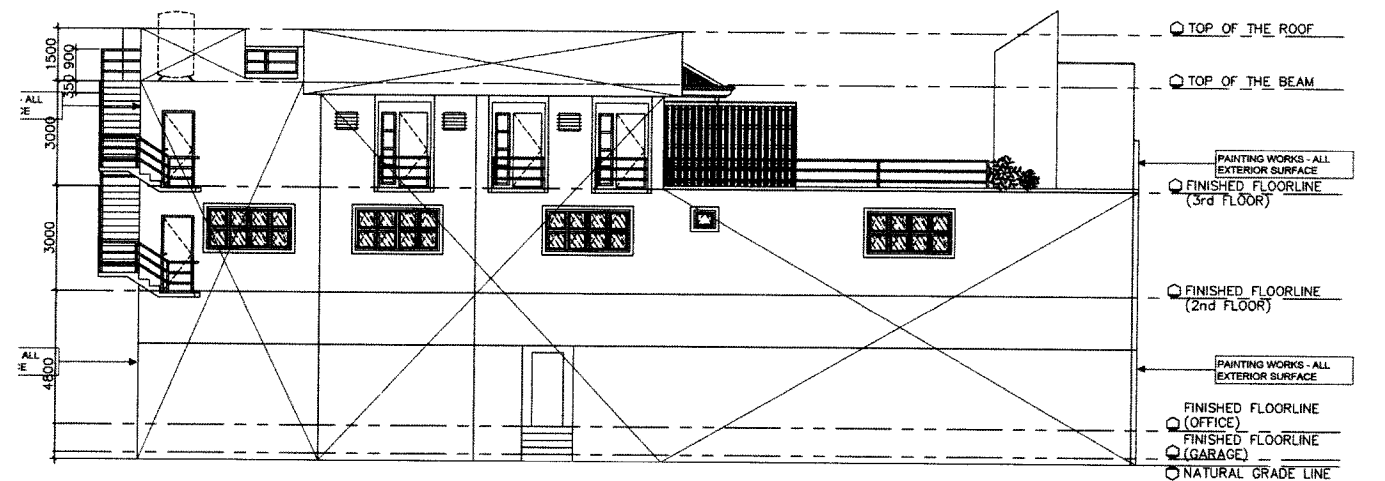

A LEFT SIDE ELEVATION PLAN
11 SCALE 1:100 MTS.

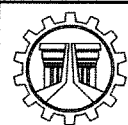

REPUBLIC OF THE PHILIPPINES
DEPARTMENT OF PUBLIC WORKS AND HIGHWAYS
REGION VIII
TACLOBAN CITY DISTRICT
ENGINEERING OFFICE
NEW BUS TERMINAL, BRGY. 91, ABUCAY, TACLOBAN CITY

PROJECT NAME AND LOCATION:

REPAIR/MAINTENANCE OF DILG BUILDING BUREAU OF
FIRE PROTECTION - TACLOBAN CITY FIRE STATION,
TACLOBAN CITY, LEYTE

SHEET CONTENTS:

- FRONT ELEVATION PLAN
- REAR ELEVATION PLAN
- RIGHT SIDE ELEVATION PLAN
- LEFT SIDE ELEVATION PLAN

DRAWN BY:

MARIANNE PAULETE D. PLIMACCO
ENGINEER I - J.O.

PREPARED BY:

MARIANNE PAULETE D. PLIMACCO
ENGINEER I - J.O.

REVIEWED:

MARY GRACE L. GADDI
ENGINEER II

SUBMITTED:

CHARLIE B. TAMPIL
CHIEF MAINTENANCE SECTION

RECOMMENDED:

CHARLIE B. TAMPIL
OFFICE OF THE ASST. DISTRICT ENGINEER

APPROVED:

RAY F. MATE
OFFICE OF THE DISTRICT ENGINEER

SET NO.

8

10