
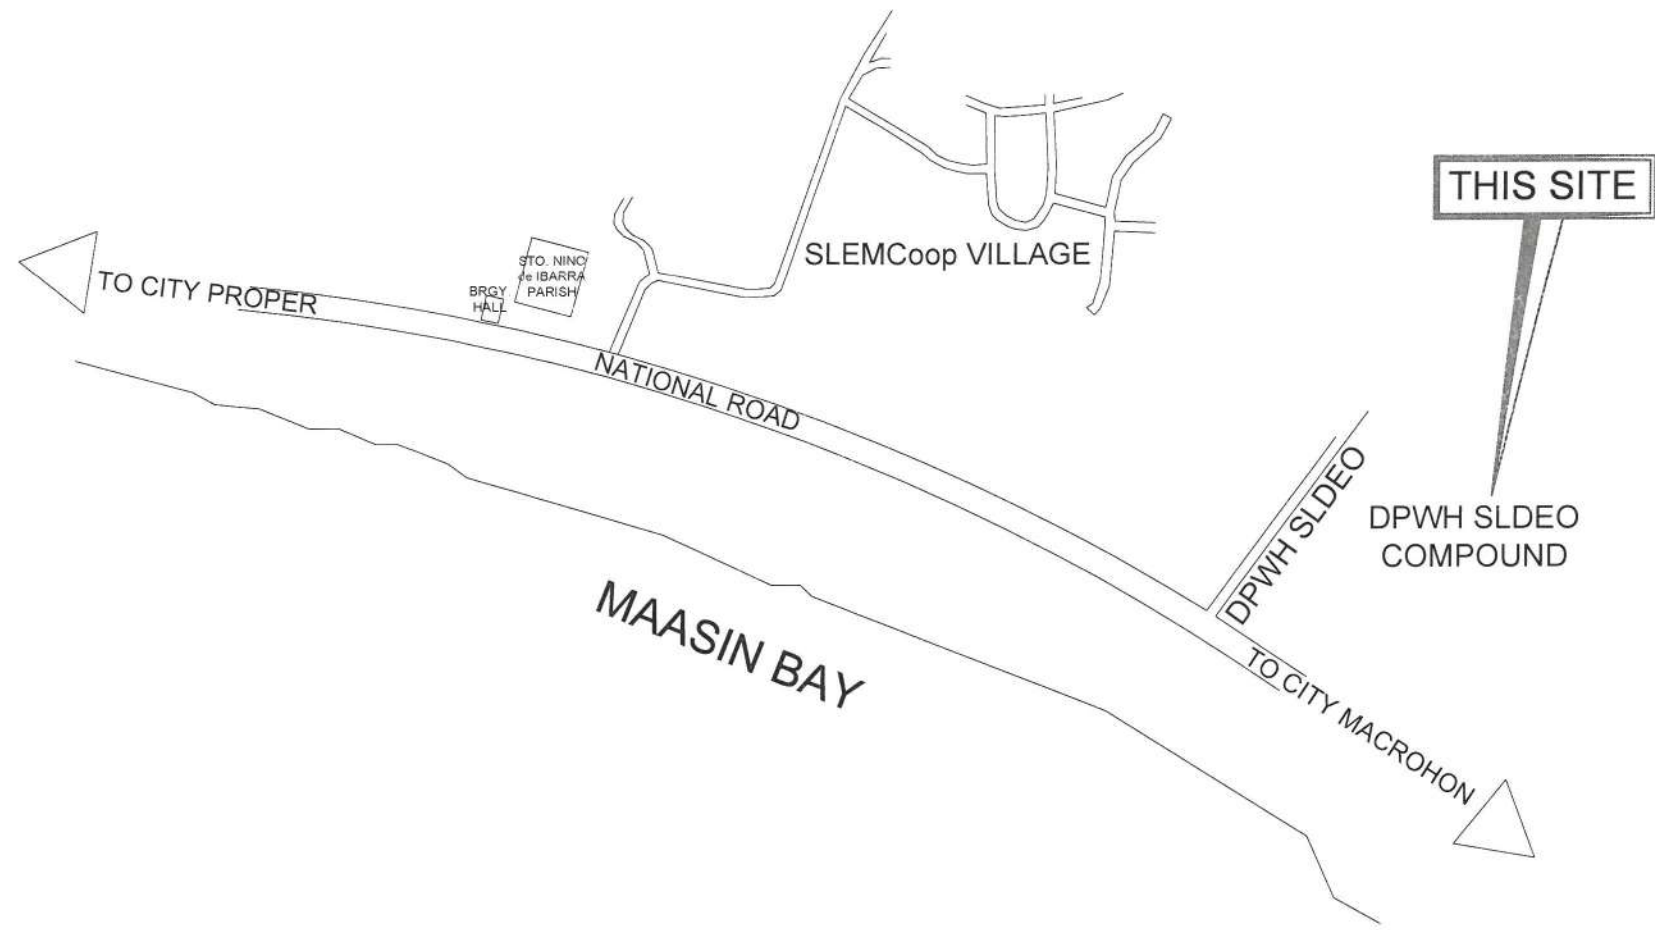


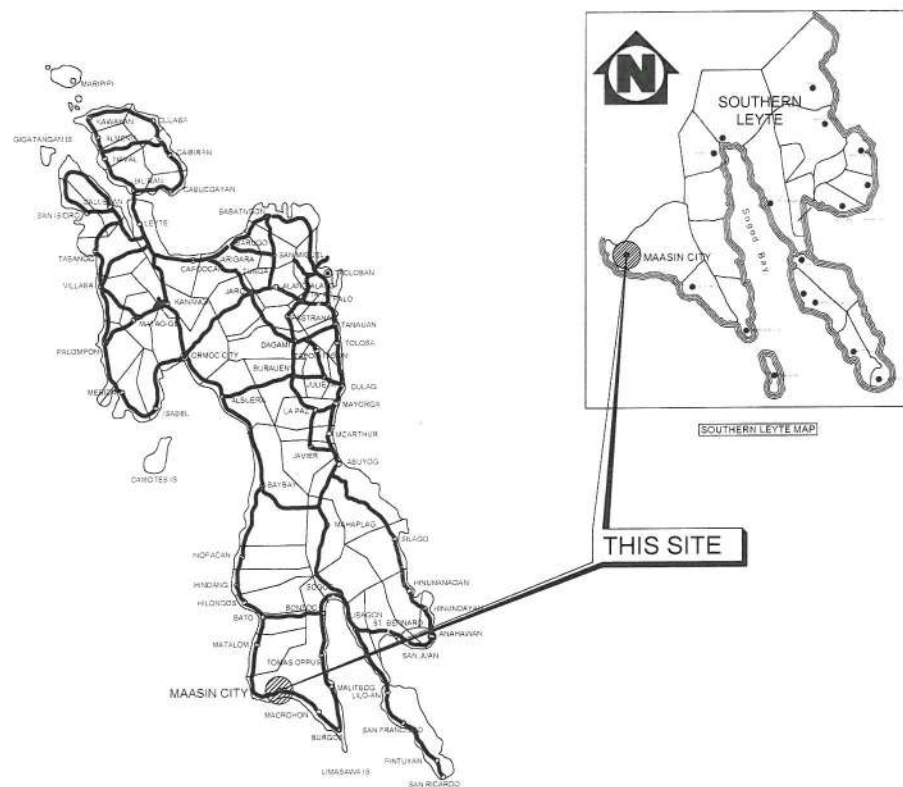

REPUBLIC OF THE PHILIPPINES  
DEPARTMENT OF PUBLIC WORKS AND HIGHWAYS  
REGION VIII  
SOUTHERN LEYTE 1<sup>ST</sup> DISTRICT ENGINEERING OFFICE  
IBARRA, MAASIN CITY, SOUTHERN LEYTE

PROJECT NAME AND LOCATION:  
SUPPLY AND INSTALLATION OF INDOOR AND OUTDOOR  
SEATS/ PLATFORMS FOR AIR CONDITIONING UNIT IN  
DPWH SLIDEO MULTI-PURPOSE BUILDING  
BRGY. IBARRA, MAASIN, SOUTHERN LEYTE

SHEET CONTENTS:  
VICINITY MAP  
LOCATION MAP

PREPARED:  
JOSEF ANTHONY P. CAPAO  
DATE: \_\_\_\_\_  
ARCHITECT II

REVIEWED:  
CHRISTOPHER C. ARBIOL, PMP, PHD  
DATE: \_\_\_\_\_  
ENGINEER II


SUBMITTED:  
DENNIS E. ORAIS  
DATE: \_\_\_\_\_  
CHIEF, PLANNING AND DESIGN SECTION

RECOMMENDED:  
GIDEON C. SACRO  
DATE: \_\_\_\_\_  
ASSISTANT DISTRICT ENGINEER

APPROVED:  
MANOLO A. ROJAS  
DATE: \_\_\_\_\_  
DISTRICT ENGINEER

SHEET NO.  
1  
6



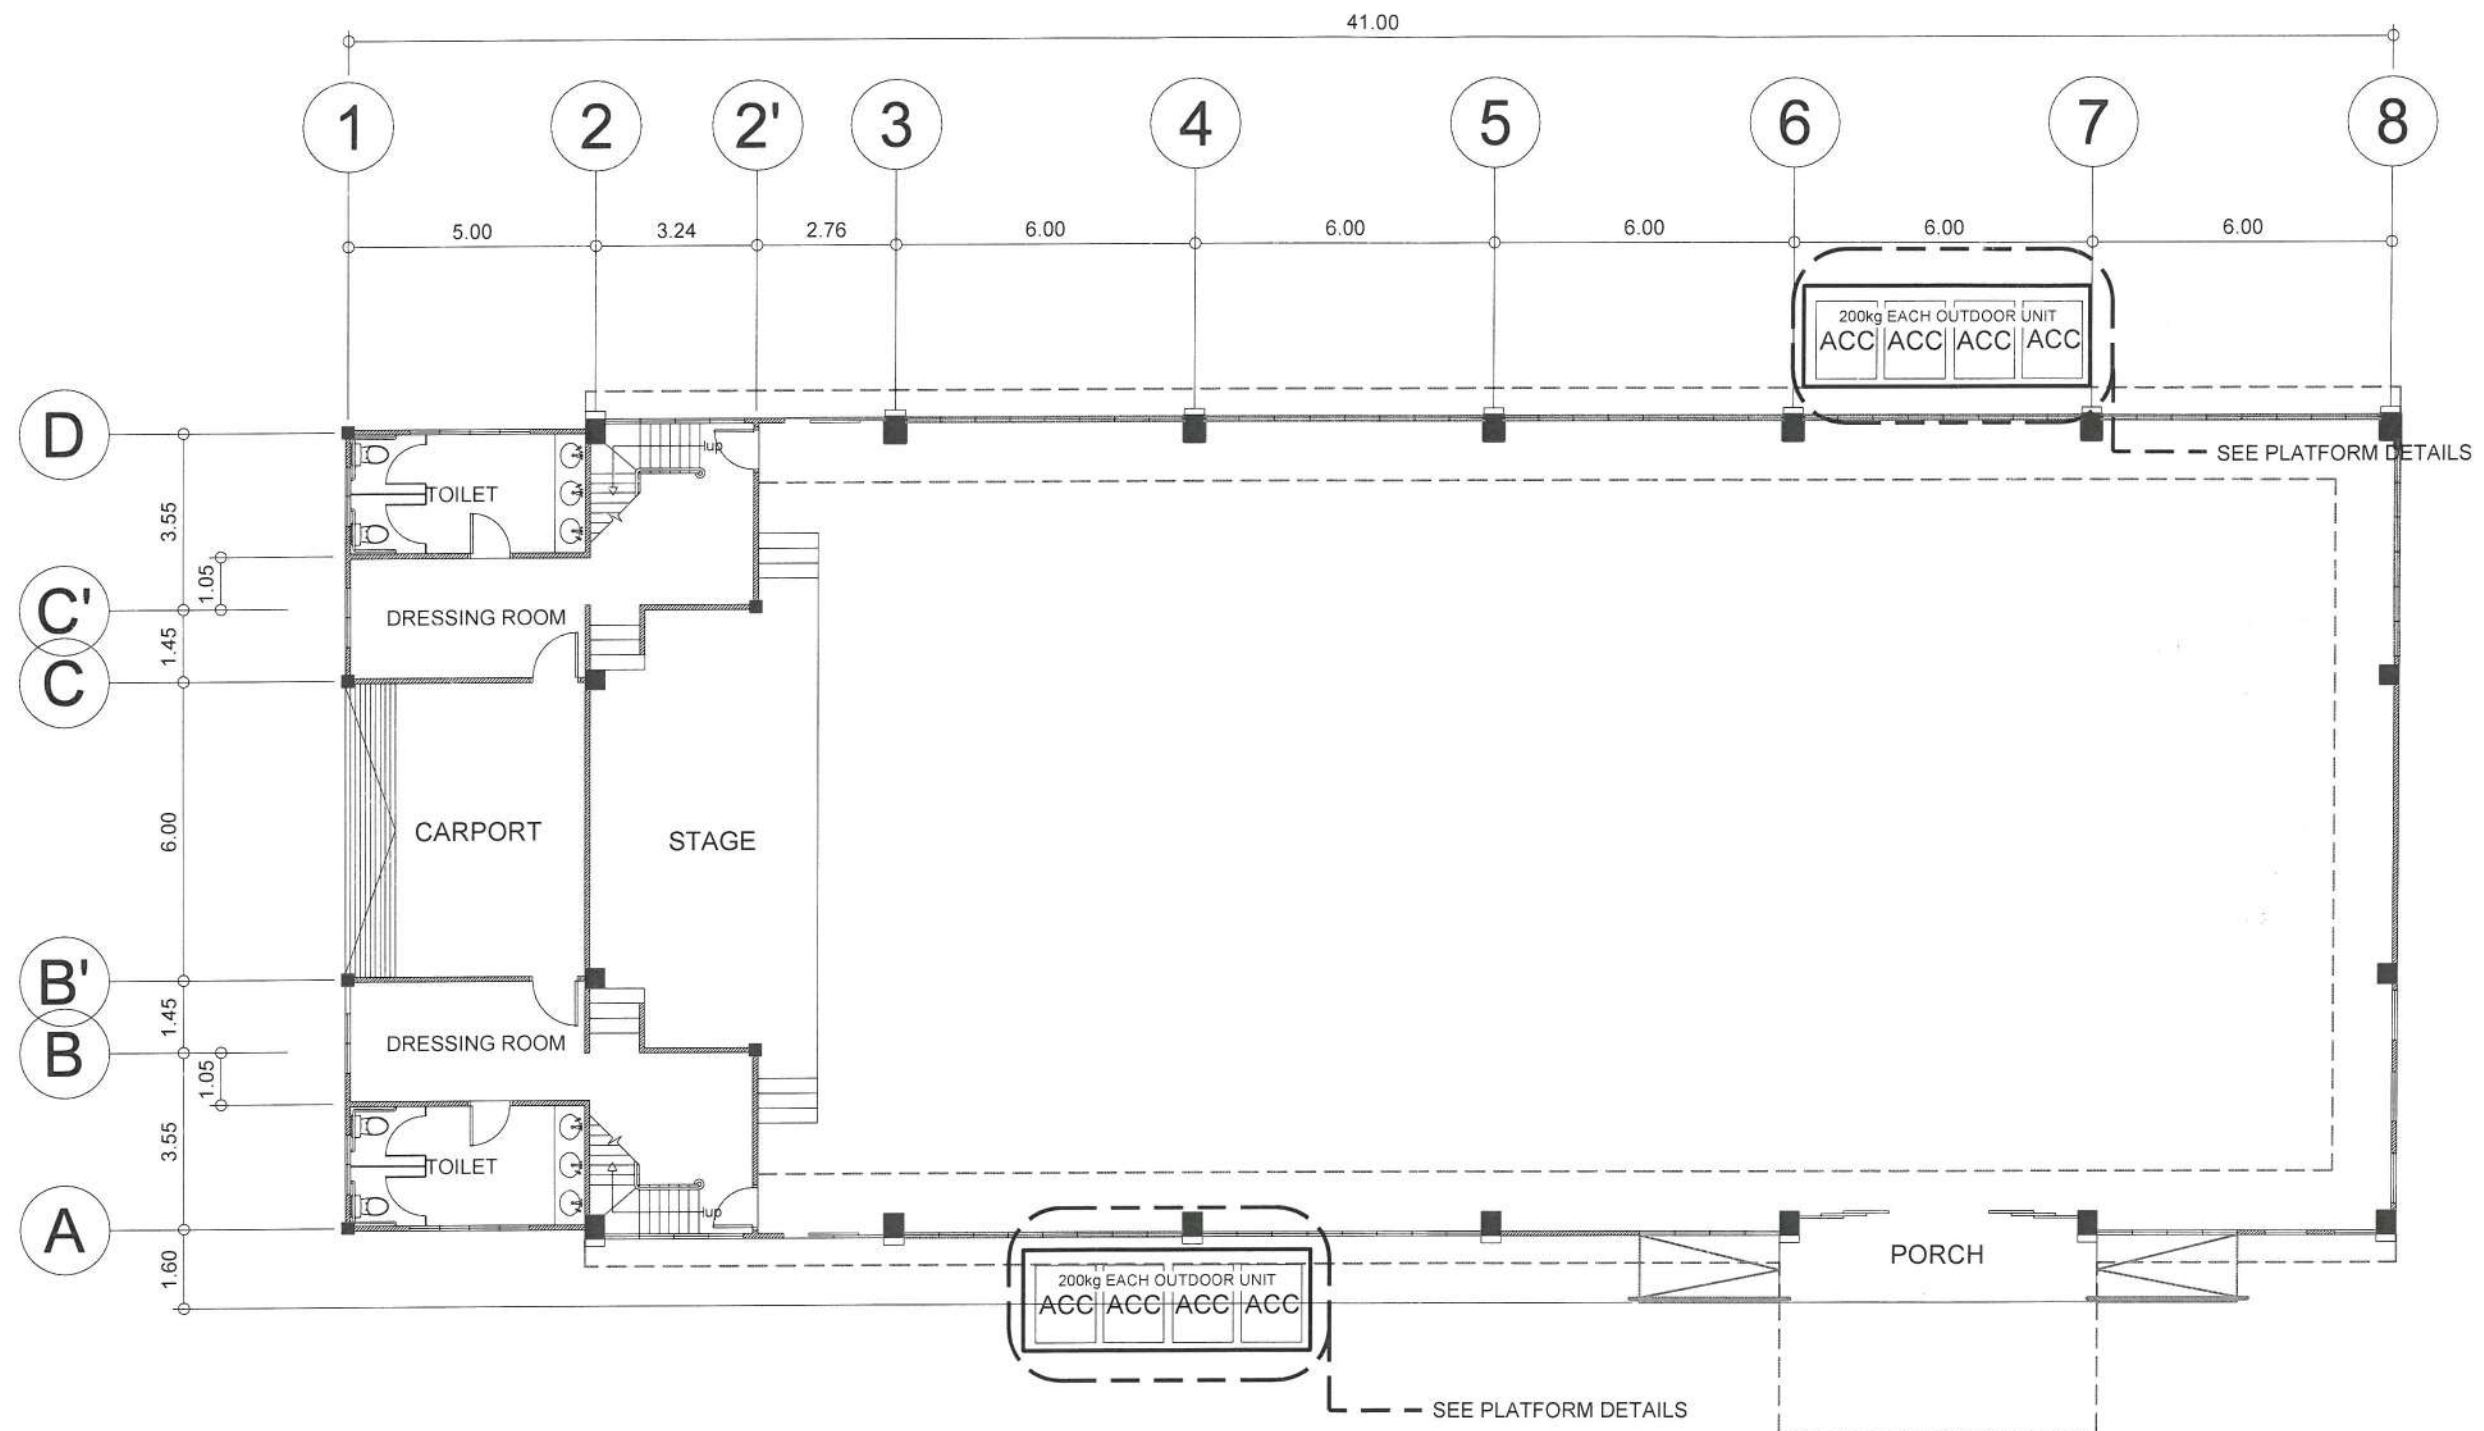

LEGEND:

|      |                            |
|------|----------------------------|
| ACCU | AIR COOLED CONDENSING UNIT |
| ACU  | AIR CONDITIONING UNIT      |



REPUBLIC OF THE PHILIPPINES  
 DEPARTMENT OF PUBLIC WORKS AND HIGHWAYS  
 REGION VIII  
 SOUTHERN LEYTE 1<sup>ST</sup> DISTRICT ENGINEERING OFFICE  
 IBARRA, MAASIN CITY, SOUTHERN LEYTE

PROJECT NAME AND LOCATION:  
 SUPPLY AND INSTALLATION OF INDOOR AND OUTDOOR  
 SEATS/ PLATFORMS FOR AIR CONDITIONING UNIT IN  
 DPWH SLIDEO MULTI-PURPOSE BUILDING  
 BRGY. IBARRA, MAASIN, SOUTHERN LEYTE

SHEET CONTENTS:  
 ACCU LOCATION PLAN

PREPARED:  
 JOSEF ANTHONY P. CARAO  
 ARCHITECT II  
 DATE: \_\_\_\_\_


REVIEWED:  
 CHRISTOPHER C. ARBIOL, PMP,PHD  
 ENGINEER II  
 DATE: \_\_\_\_\_

SUBMITTED:  
 DENNIS E. ORAIS  
 CHIEF PLANNING AND DESIGN SECTION  
 DATE: \_\_\_\_\_

RECOMMENDED:  
 GIDEON C. SACRO  
 ASSISTANT DISTRICT ENGINEER  
 DATE: \_\_\_\_\_

APPROVED:  
 MANOLO A. ROJAS  
 DISTRICT ENGINEER  
 DATE: \_\_\_\_\_

|          |           |
|----------|-----------|
| SET NO.  | SHEET NO. |
| A<br>1 3 | 3<br>6    |

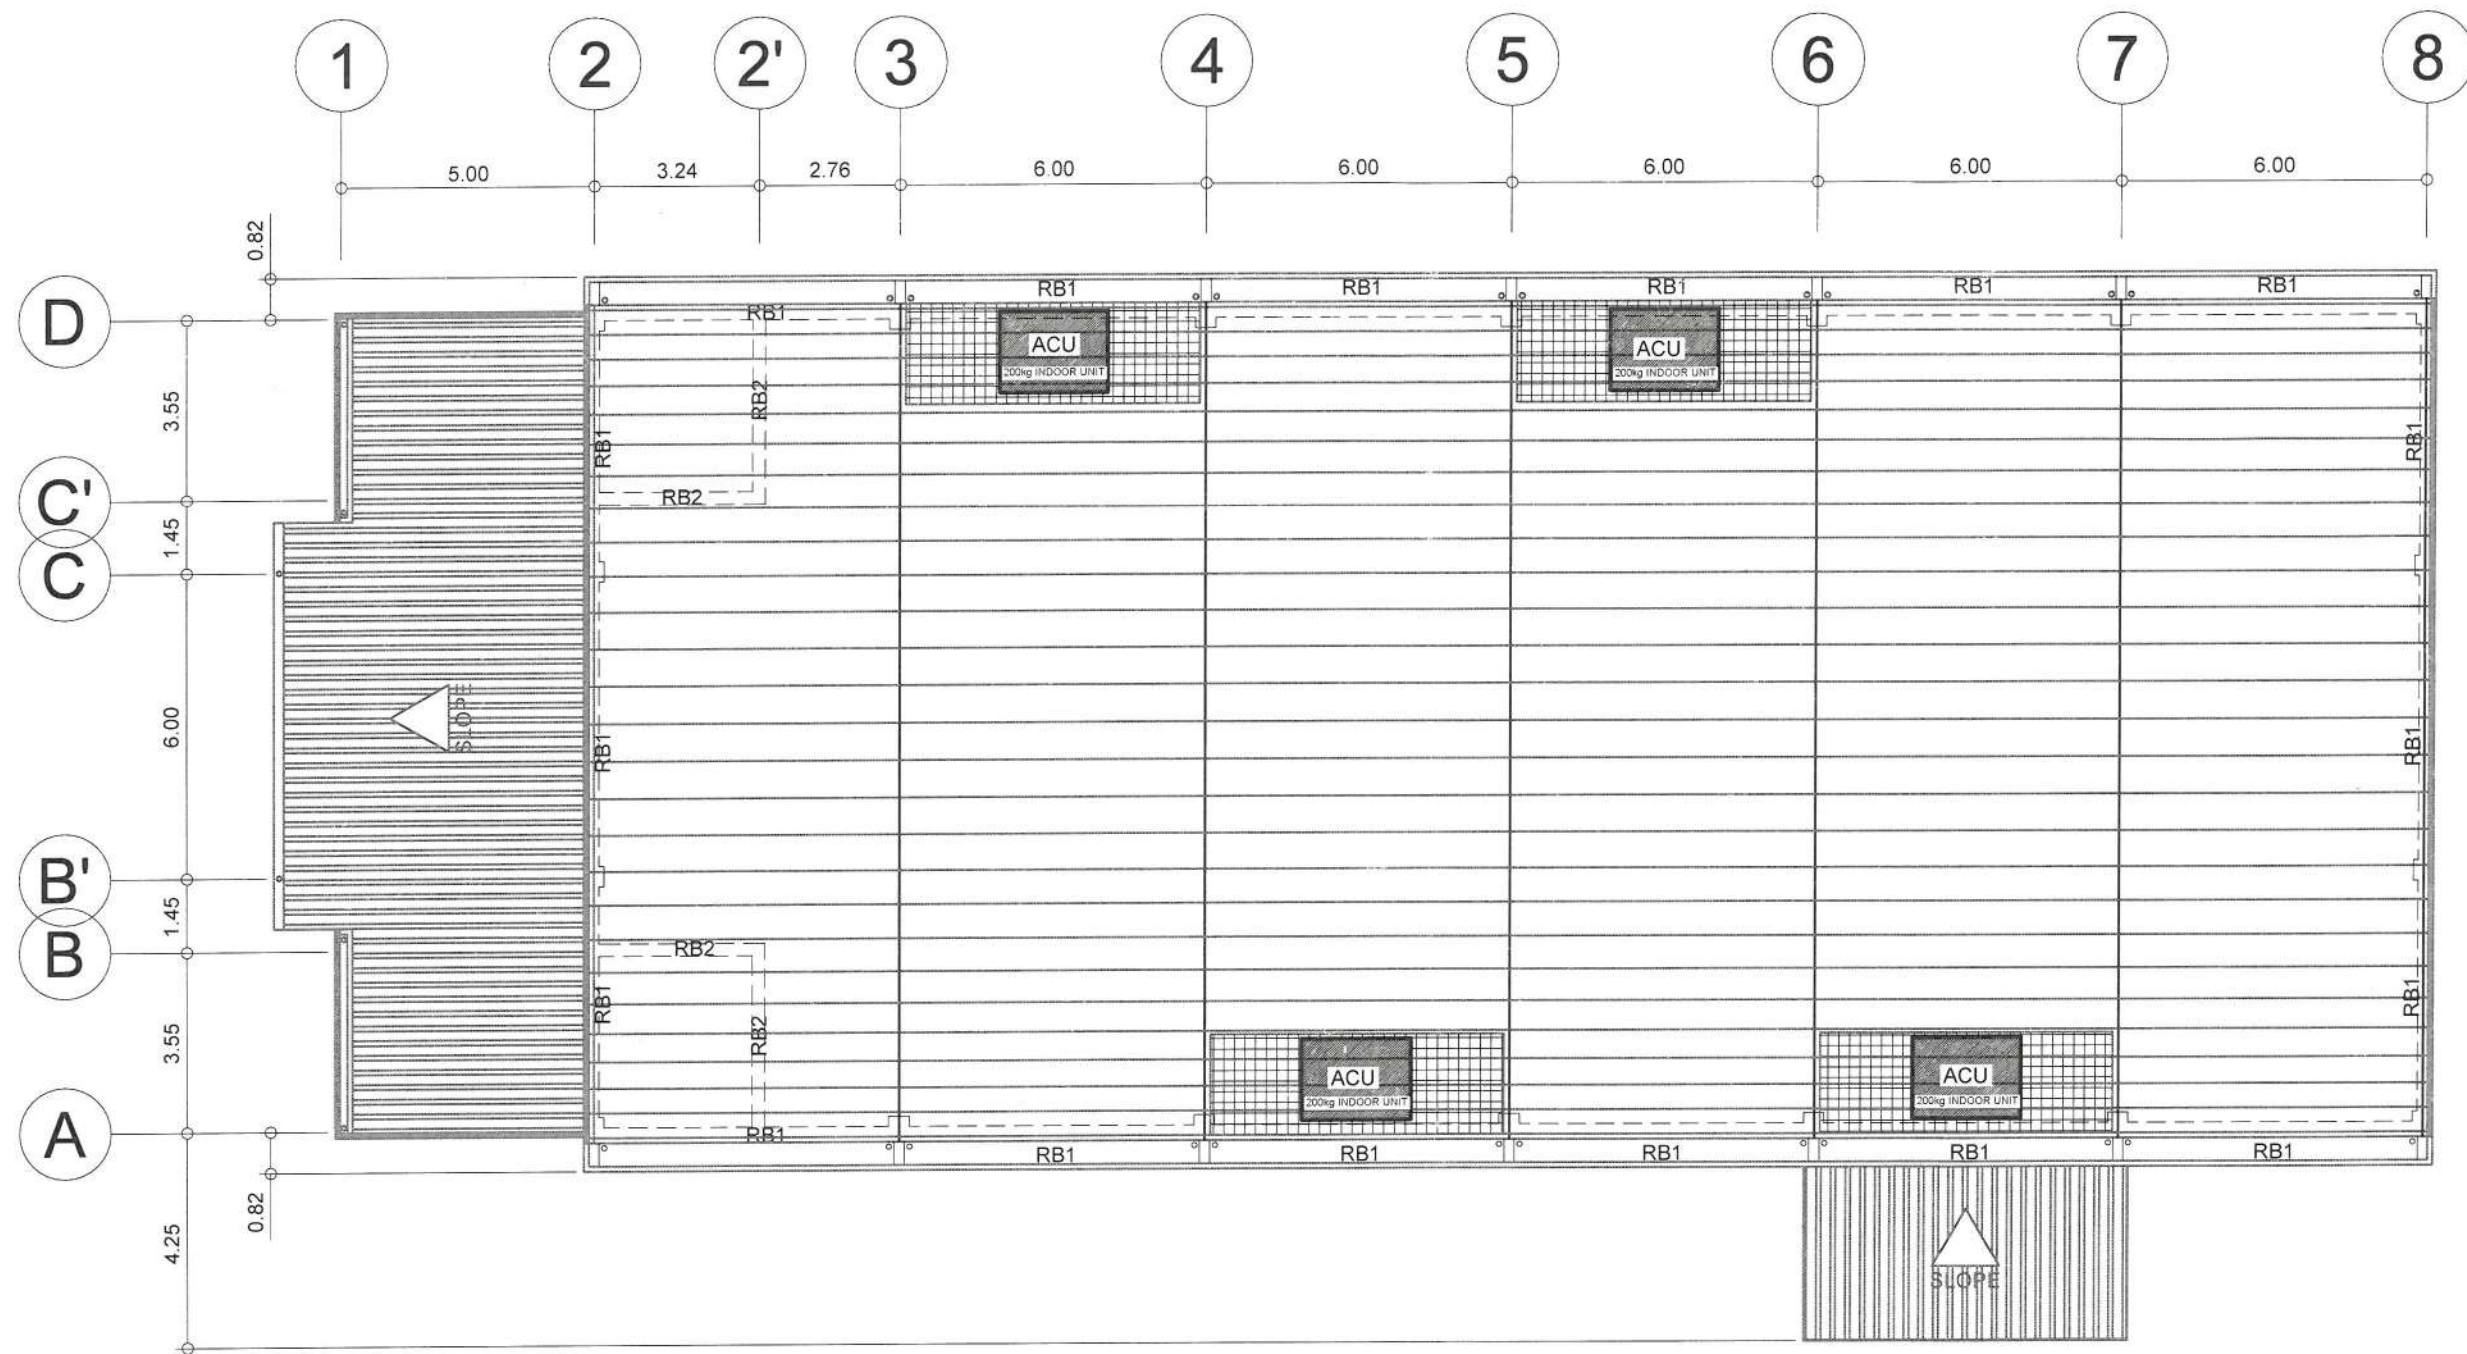

**ACU LOCATION PLAN**  
SCALE 1 : 150 MTS

LEGEND:

|      |                            |
|------|----------------------------|
| ACCU | AIR COOLED CONDENSING UNIT |
| ACU  | AIR CONDITIONING UNIT      |



REPUBLIC OF THE PHILIPPINES  
DEPARTMENT OF PUBLIC WORKS AND HIGHWAYS  
REGION VIII  
SOUTHERN LEYTE 1<sup>ST</sup> DISTRICT ENGINEERING OFFICE  
IBARRA, MAASIN CITY, SOUTHERN LEYTE

PROJECT NAME AND LOCATION:

SUPPLY AND INSTALLATION OF INDOOR AND OUTDOOR  
SEATS/ PLATFORMS FOR AIR CONDITIONING UNIT IN  
DPWH SLIDEO MULTI-PURPOSE BUILDING

BRGY. IBARRA, MAASIN, SOUTHERN LEYTE

SHEET CONTENTS:

ACCU LOCATION PLAN

PREPARED:

JOSEF ANTHONY P. CAPAO  
ARCHITECT II  
DATE:

REVIEWED:

CHRISTOPHER C. ARBIOL, PMP, PHD  
ENGINEER II  
DATE:

SUBMITTED:

DENNISE E. ORAIS  
CHIEF PLANNING AND DESIGN SECTION  
DATE:

RECOMMENDED:

GIDEON C. SACRO  
ASSISTANT DISTRICT ENGINEER  
DATE:

APPROVED:


MANDLO A. ROJAS  
DISTRICT ENGINEER  
DATE:

SET NO.


A  
2 3

SHEET NO.

4  
6

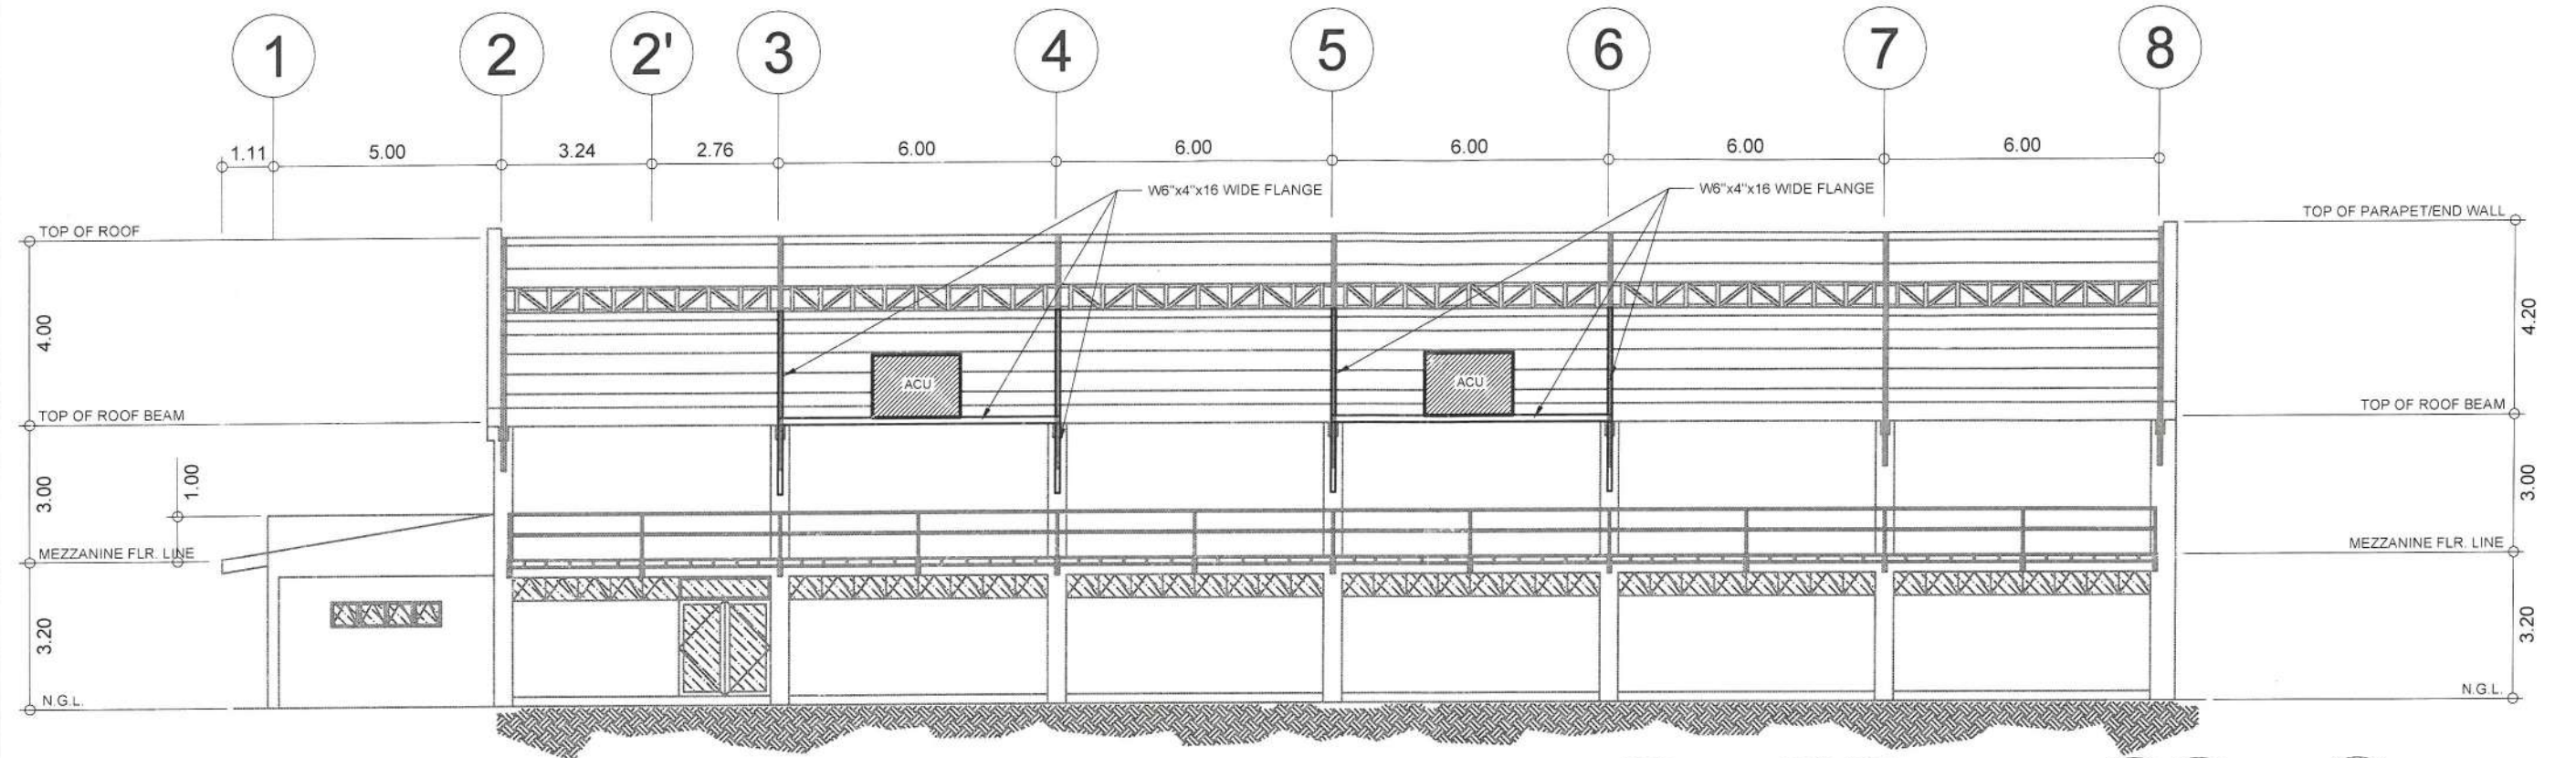

**LONGITUDINAL SECTION**  
SCALE 1:150 MTS

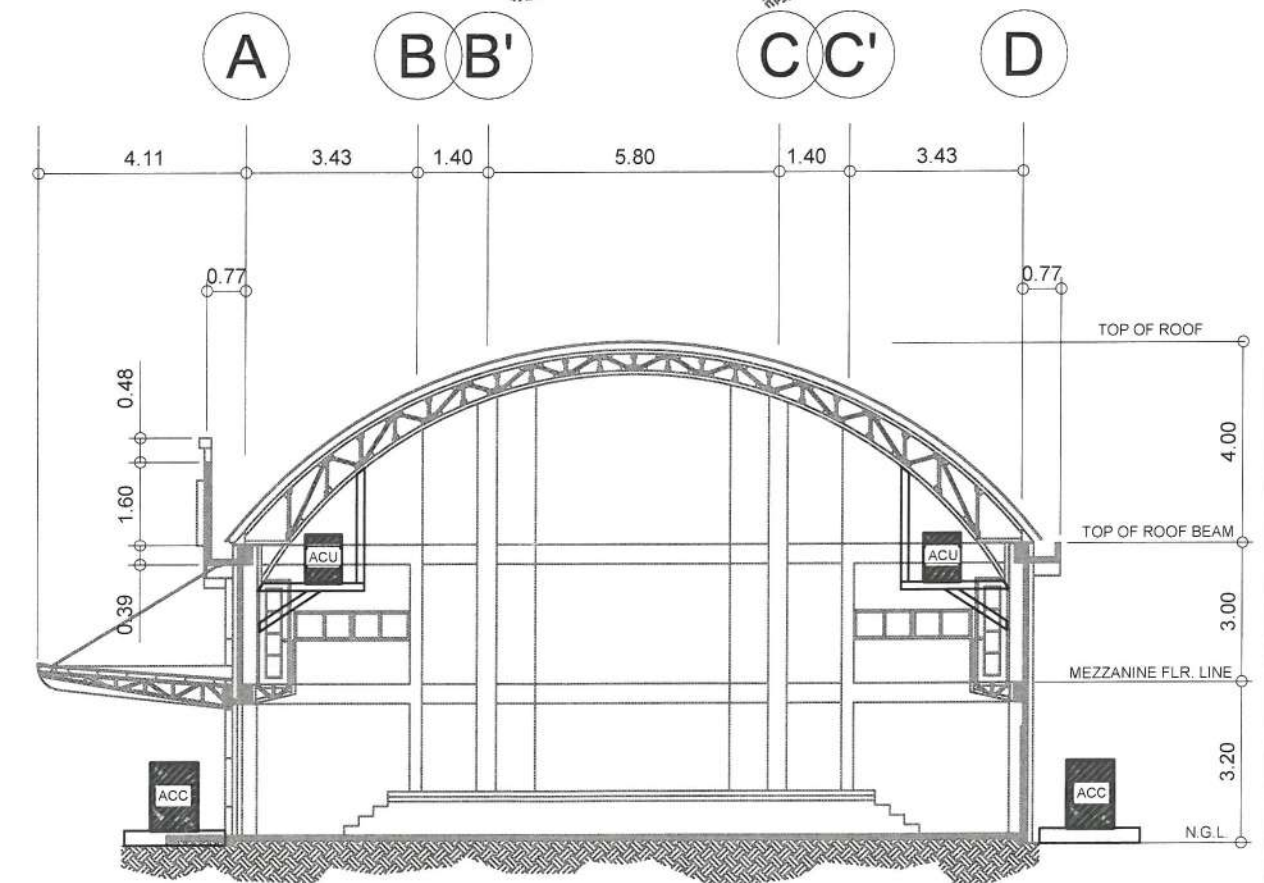

**CROSS SECTION**  
SCALE 1:150 MTS

LEGEND:

|     |                            |
|-----|----------------------------|
| ACC | AIR COOLED CONDENSING UNIT |
| ACU | AIR CONDITIONING UNIT      |



REPUBLIC OF THE PHILIPPINES  
DEPARTMENT OF PUBLIC WORKS AND HIGHWAYS  
REGION VIII  
SOUTHERN LEYTE 1<sup>ST</sup> DISTRICT ENGINEERING OFFICE  
IBARRA, MAASIN CITY, SOUTHERN LEYTE

PROJECT NAME AND LOCATION:

SUPPLY AND INSTALLATION OF INDOOR AND OUTDOOR  
SEATS/ PLATFORMS FOR AIR CONDITIONING UNIT IN  
DPWH SLIDEO MULTI-PURPOSE BUILDING

BRGY. IBARRA, MAASIN, SOUTHERN LEYTE

SHEET CONTENTS:

LONGITUDINAL SECTION  
CROSS SECTION

PREPARED:

JOSEF ANTHONY P. CAPAO

DATE:

ARCHITECT

REVIEWED:

CHRISTOPHER C. ARRIOL, PMP,PHD

ENGINEER

SUBMITTED:

DENNIS E. ORAIS

CHIEF PLANNING AND DESIGN SECTION

RECOMMENDED:

GIDEON O. SACRO

ASSISTANT DISTRICT ENGINEER

APPROVED:

MANOLO A. ROJAS


DISTRICT ENGINEER

SET NO.


A  
3 3

SHEET NO.

5  
6

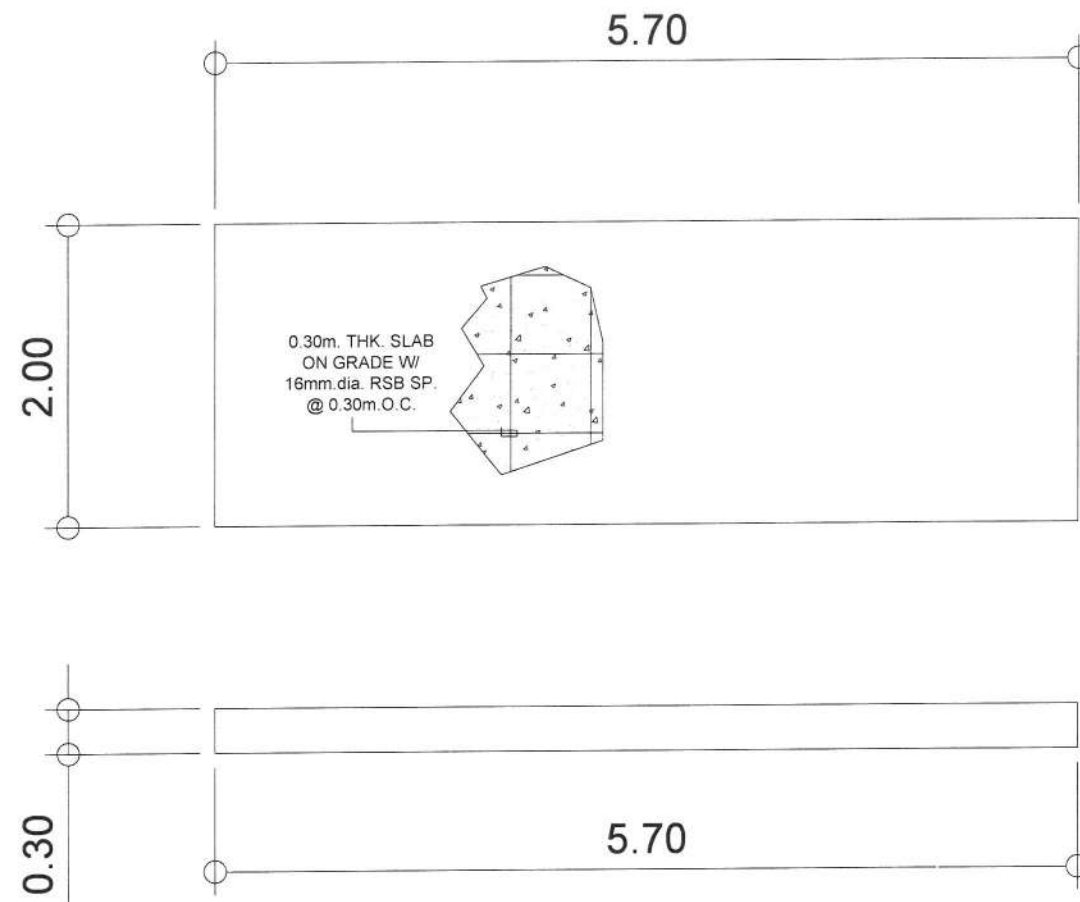


GROUND FLOOR PLAN  
**PLATFORM DETAILS**  
SCALE 1:50 MTS

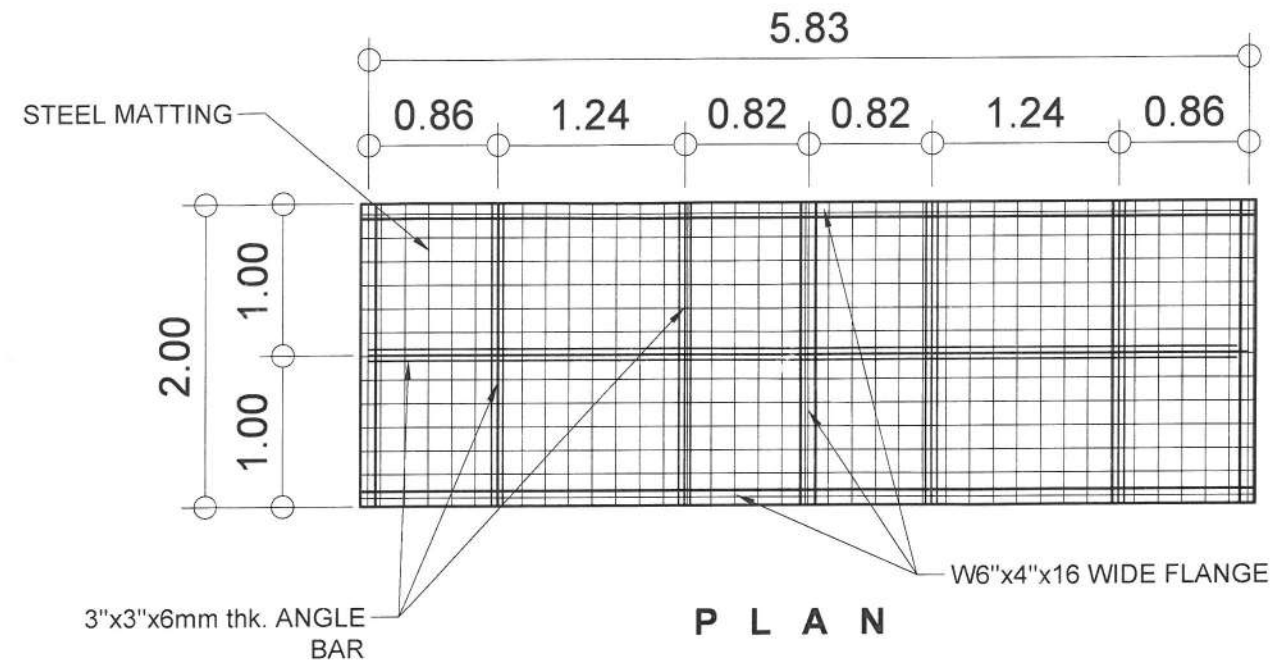


**P L A N**

6- 16mm Ø x 300mm ANCHOR BOLT AND NUTS

100mm x 100mm x 12mm thk. STEEL BASE PLATE(BOLTED TO CONC. COL.)

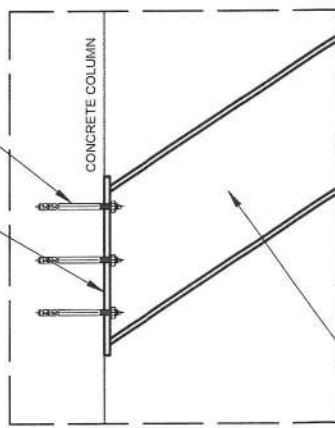

100mm x 100mm x 12mm thk. STEEL BASE PLATE(WELDED TO EXISTING TRUSS)

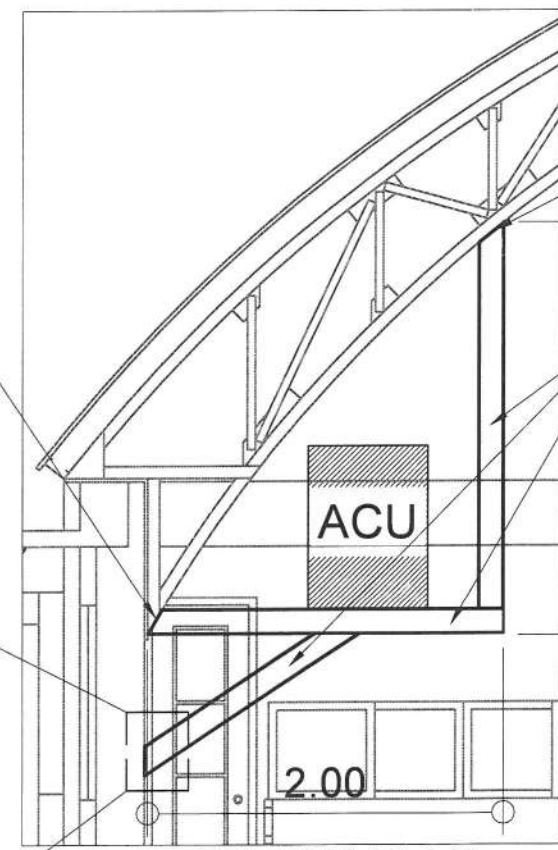

**ELEVATION**

**INDOOR BRACKET DETAILS**  
SCALE 1:50 MTS



REPUBLIC OF THE PHILIPPINES  
DEPARTMENT OF PUBLIC WORKS AND HIGHWAYS  
REGION VIII  
SOUTHERN LEYTE 1<sup>ST</sup> DISTRICT ENGINEERING OFFICE  
IBARRA, MAASIN CITY, SOUTHERN LEYTE

PROJECT NAME AND LOCATION:  
SUPPLY AND INSTALLATION OF INDOOR AND OUTDOOR SEATS/ PLATFORMS FOR AIR CONDITIONING UNIT IN DPWH SLIDEO MULTI-PURPOSE BUILDING  
BRGY. IBARRA, MAASIN, SOUTHERN LEYTE

SHEET CONTENTS:  
PLATFORM DETAILS  
INDOOR BRACKET DETAILS

PREPARED:  
EDDIE B. SALVEDRA JR.  
ENGINEER II  
DATE

REVIEWED:  
CHRISTOPHER C. ARBOL, PMP,PHD  
ENGINEER  
DATE

SUBMITTED:  
DENNIS E. ORAIS  
CHIEF, PLANNING AND DESIGN SECTION  
DATE

RECOMMENDED:  
GIDEON CUSACRO  
ASSISTANT DISTRICT ENGINEER  
DATE

APPROVED:  
MANOLO A. ROJAS  
DISTRICT ENGINEER  
DATE

| SET NO.  | SHEET NO. |
|----------|-----------|
| S<br>1 1 | 6<br>6    |